

PROPOSED FLOOR PLAN LEGEND

B1/F FLOOR LEGEND

SYMBOL	DESCRIPTION	REMARKS
①	DISPLAY AREA	NO PUBLIC ACCESS
②	METAL WORKSPACE	MAX. CAPACITY: 4 PEOPLE

G/F FLOOR LEGEND

SYMBOL	DESCRIPTION	REMARKS
③	OFFICE	STAFF ACCESS ONLY MAX. CAPACITY: 12 PEOPLE
④	RECEPTION	/
⑤	EXHIBITION ROOM	PRIOR REGISTRATION REQUIRED MAX. CAPACITY: 8 PEOPLE
⑥	DRIVEWAY TO CAR PARK	LOCATED OUT OF SITE BOUNDARY & BELONGED TO OTHER BUILDINGS
⑦	DISCUSSION AREA	MAX. CAPACITY: 10 PEOPLE
⑧	UNISEX RESTROOM	/
⑨	MATERIAL LIBRARY	/
⑩	SERVICE COUNTER	/
⑪	CAFÉ	MAX. CAPACITY: 6 PEOPLE
⑫	OUTDOOR GARDEN	/
⑬	EVENT SPACE	/
⑭	WOODWORK WORKSPACE	APPOINTMENT REQUIRED MAX. CAPACITY: 10 PEOPLE
⑮	WOODWORK WORKSHOP	APPOINTMENT REQUIRED MAX. CAPACITY: 5 PEOPLE
⑯	JEWELLERY WORKSPACE	APPOINTMENT REQUIRED MAX. CAPACITY: 2 PEOPLE
⑰	METALWORK WORKSHOP	APPOINTMENT REQUIRED MAX. CAPACITY: 2 PEOPLE
⑱	MEDICAL ROOM	MAX. CAPACITY: 3 PEOPLE
⑲	UNISEX RESTROOM	/
⑳	POST OFFICE	MAX. CAPACITY: 5 PEOPLE
㉑	STORE ROOM	/
㉒	STORE ROOM	/
㉓	MATERIAL SHOP	MAX. CAPACITY: 5 PEOPLE
㉔	OFFICE	STAFF ACCESS ONLY MAX. CAPACITY: 5 PEOPLE
㉕	COURTYARD	/
㉖	CRAFTS SHOP	MAX. CAPACITY: 5 PEOPLE
㉗	JEWELLERY WORKSPACE	MAX. CAPACITY: 2 PEOPLE
㉘	JEWELLERY WORKSPACE	MAX. CAPACITY: 2 PEOPLE
㉙	METALWORK / JEWELLERY WORKSHOP	MAX. CAPACITY: 5 PEOPLE

1/F FLOOR LEGEND

SYMBOL	DESCRIPTION	REMARKS
⑳	RESEARCH CENTRE	STAFF ACCESS ONLY MAX. CAPACITY: 8 PEOPLE
㉑	STAFF PANTRY	MAX. CAPACITY: 3 PEOPLE
㉒	UNISEX RESTROOM	/
㉓	REST AREA	MAX. CAPACITY: 3 PEOPLE
㉔	CONFERENCE ROOM (1)	APPOINTMENT REQUIRED MAX. CAPACITY: 8 PEOPLE
㉕	CONFERENCE ROOM (2)	APPOINTMENT REQUIRED MAX. CAPACITY: 4 PEOPLE
㉖	PRIVATE STUDYING ROOM	APPOINTMENT REQUIRED MAX. CAPACITY: 6 PEOPLE
㉗	CAFÉ ROOF GARDEN	MAX. CAPACITY: 12 PEOPLE
㉘	READING AREA & PUBLIC STUDYING AREA	/
㉙	INFORMATION KIOSK	/
㉚	JEWELLERY WORKSHOP	APPOINTMENT REQUIRED MAX. CAPACITY: 3 PEOPLE
㉛	GLASSWORK WORKSHOP	APPOINTMENT REQUIRED MAX. CAPACITY: 4 PEOPLE
㉜	JEWELLERY WORKSHOP	APPOINTMENT REQUIRED MAX. CAPACITY: 2 PEOPLE
㉝	GLASSWORK WORKSHOP	APPOINTMENT REQUIRED MAX. CAPACITY: 6 PEOPLE
㉞	SUPPORTING CENTRE	MAX. CAPACITY: 8 PEOPLE
㉟	STORE ROOM	/
㊱	CERAMICS WORKSHOP	APPOINTMENT REQUIRED MAX. CAPACITY: 4 PEOPLE
㊲	CERAMICS WORKSHOP	APPOINTMENT REQUIRED MAX. CAPACITY: 5 PEOPLE
㊳	REST AREA	MAX. CAPACITY: 5 PEOPLE

2/F FLOOR LEGEND

SYMBOL	DESCRIPTION	REMARKS
㊴	IT LAB	APPOINTMENT REQUIRED MAX. CAPACITY: 7 PEOPLE
㊵	STORE ROOM	/
㊶	GLASSWORK WORKSPACE	APPOINTMENT REQUIRED MAX. CAPACITY: 2 PEOPLE
㊷	GLASSWORK WORKSPACE	APPOINTMENT REQUIRED MAX. CAPACITY: 5 PEOPLE
㊸	CERAMICS WORKSPACE	APPOINTMENT REQUIRED MAX. CAPACITY: 6 PEOPLE
㊹	STORE ROOM	/
㊺	CERAMICS WORKSPACE	APPOINTMENT REQUIRED MAX. CAPACITY: 5 PEOPLE
㊻	UNISEX RESTROOM	/

3/F FLOOR LEGEND

SYMBOL	DESCRIPTION	REMARKS
㊼	STORE ROOM	/
㊽	STORE ROOM	/

MATERIAL LEGEND

FLOORING

	POLISHED CONCRETE SCREED FLOORING
	CARPET SHEET
	PORCELAIN TILE
	CERAMIC TILE
	ENGINEERED WOOD
	PORCELAIN STONEWARE (EXTERIOR USE)
	ARTIFICIAL GRASS
	TRANSLUCENT GLASS
	WINDOW

FURNITURE

	RECLAIMED WOOD
---	----------------

PARTITION

	NEW STRUCTURAL CONCRETE WALL UP TO CEILING W/ SOUND-PROOF MATERIAL (INTERIOR)
	NEW FULL-HEIGHT VOILE
	NEW STRUCTURAL CONCRETE WALL (EXTERIOR)
	NEW STRUCTURAL GLASS WALL (EXTERIOR)
	NEW STRUCTURAL 2500MM FENCE (EXTERIOR)
	NEW BLACK STEEL BALUSTRADE W/ SPRAY PAINT FINISH
	EXISTING STEEL COLUMN BEING RENOVATED W/ SPRAY PAINT FINISH
	NEW BLACK STEEL COLUMN W/ SPRAY PAINT FINISH



GENERAL NOTES

- ALL DIMENSIONS ARE IN MILLIMETERS UNLESS OTHERWISE SPECIFIED.
- DO NOT SCALE THE DRAWINGS.
- ALL DIMENSIONS SHALL BE VERIFIED ON SITE WITH CONTRACTORS BEFORE PROCEEDING WORK.
- ALL DESIGNS ARE PROPERTY OF SO PAK LING. NO REPRODUCTION IS PERMITTED WITHOUT CONSENT.

SPECIFIC NOTES

REVISION

NO.	DATE	ISSUE

PROJECT TITLE

WHITECHAPEL HANDICRAFT LIBRARY

PROJECT NO.

FMP-01

DRAWN BY

SO PAK LING

SCALE

N.T.S.

DRAWING TITLE

PROPOSED FLOOR PLAN LEGEND

DATE


29 MAR 2021

REVISION NO.

01

DRAWING NO.

FP-01

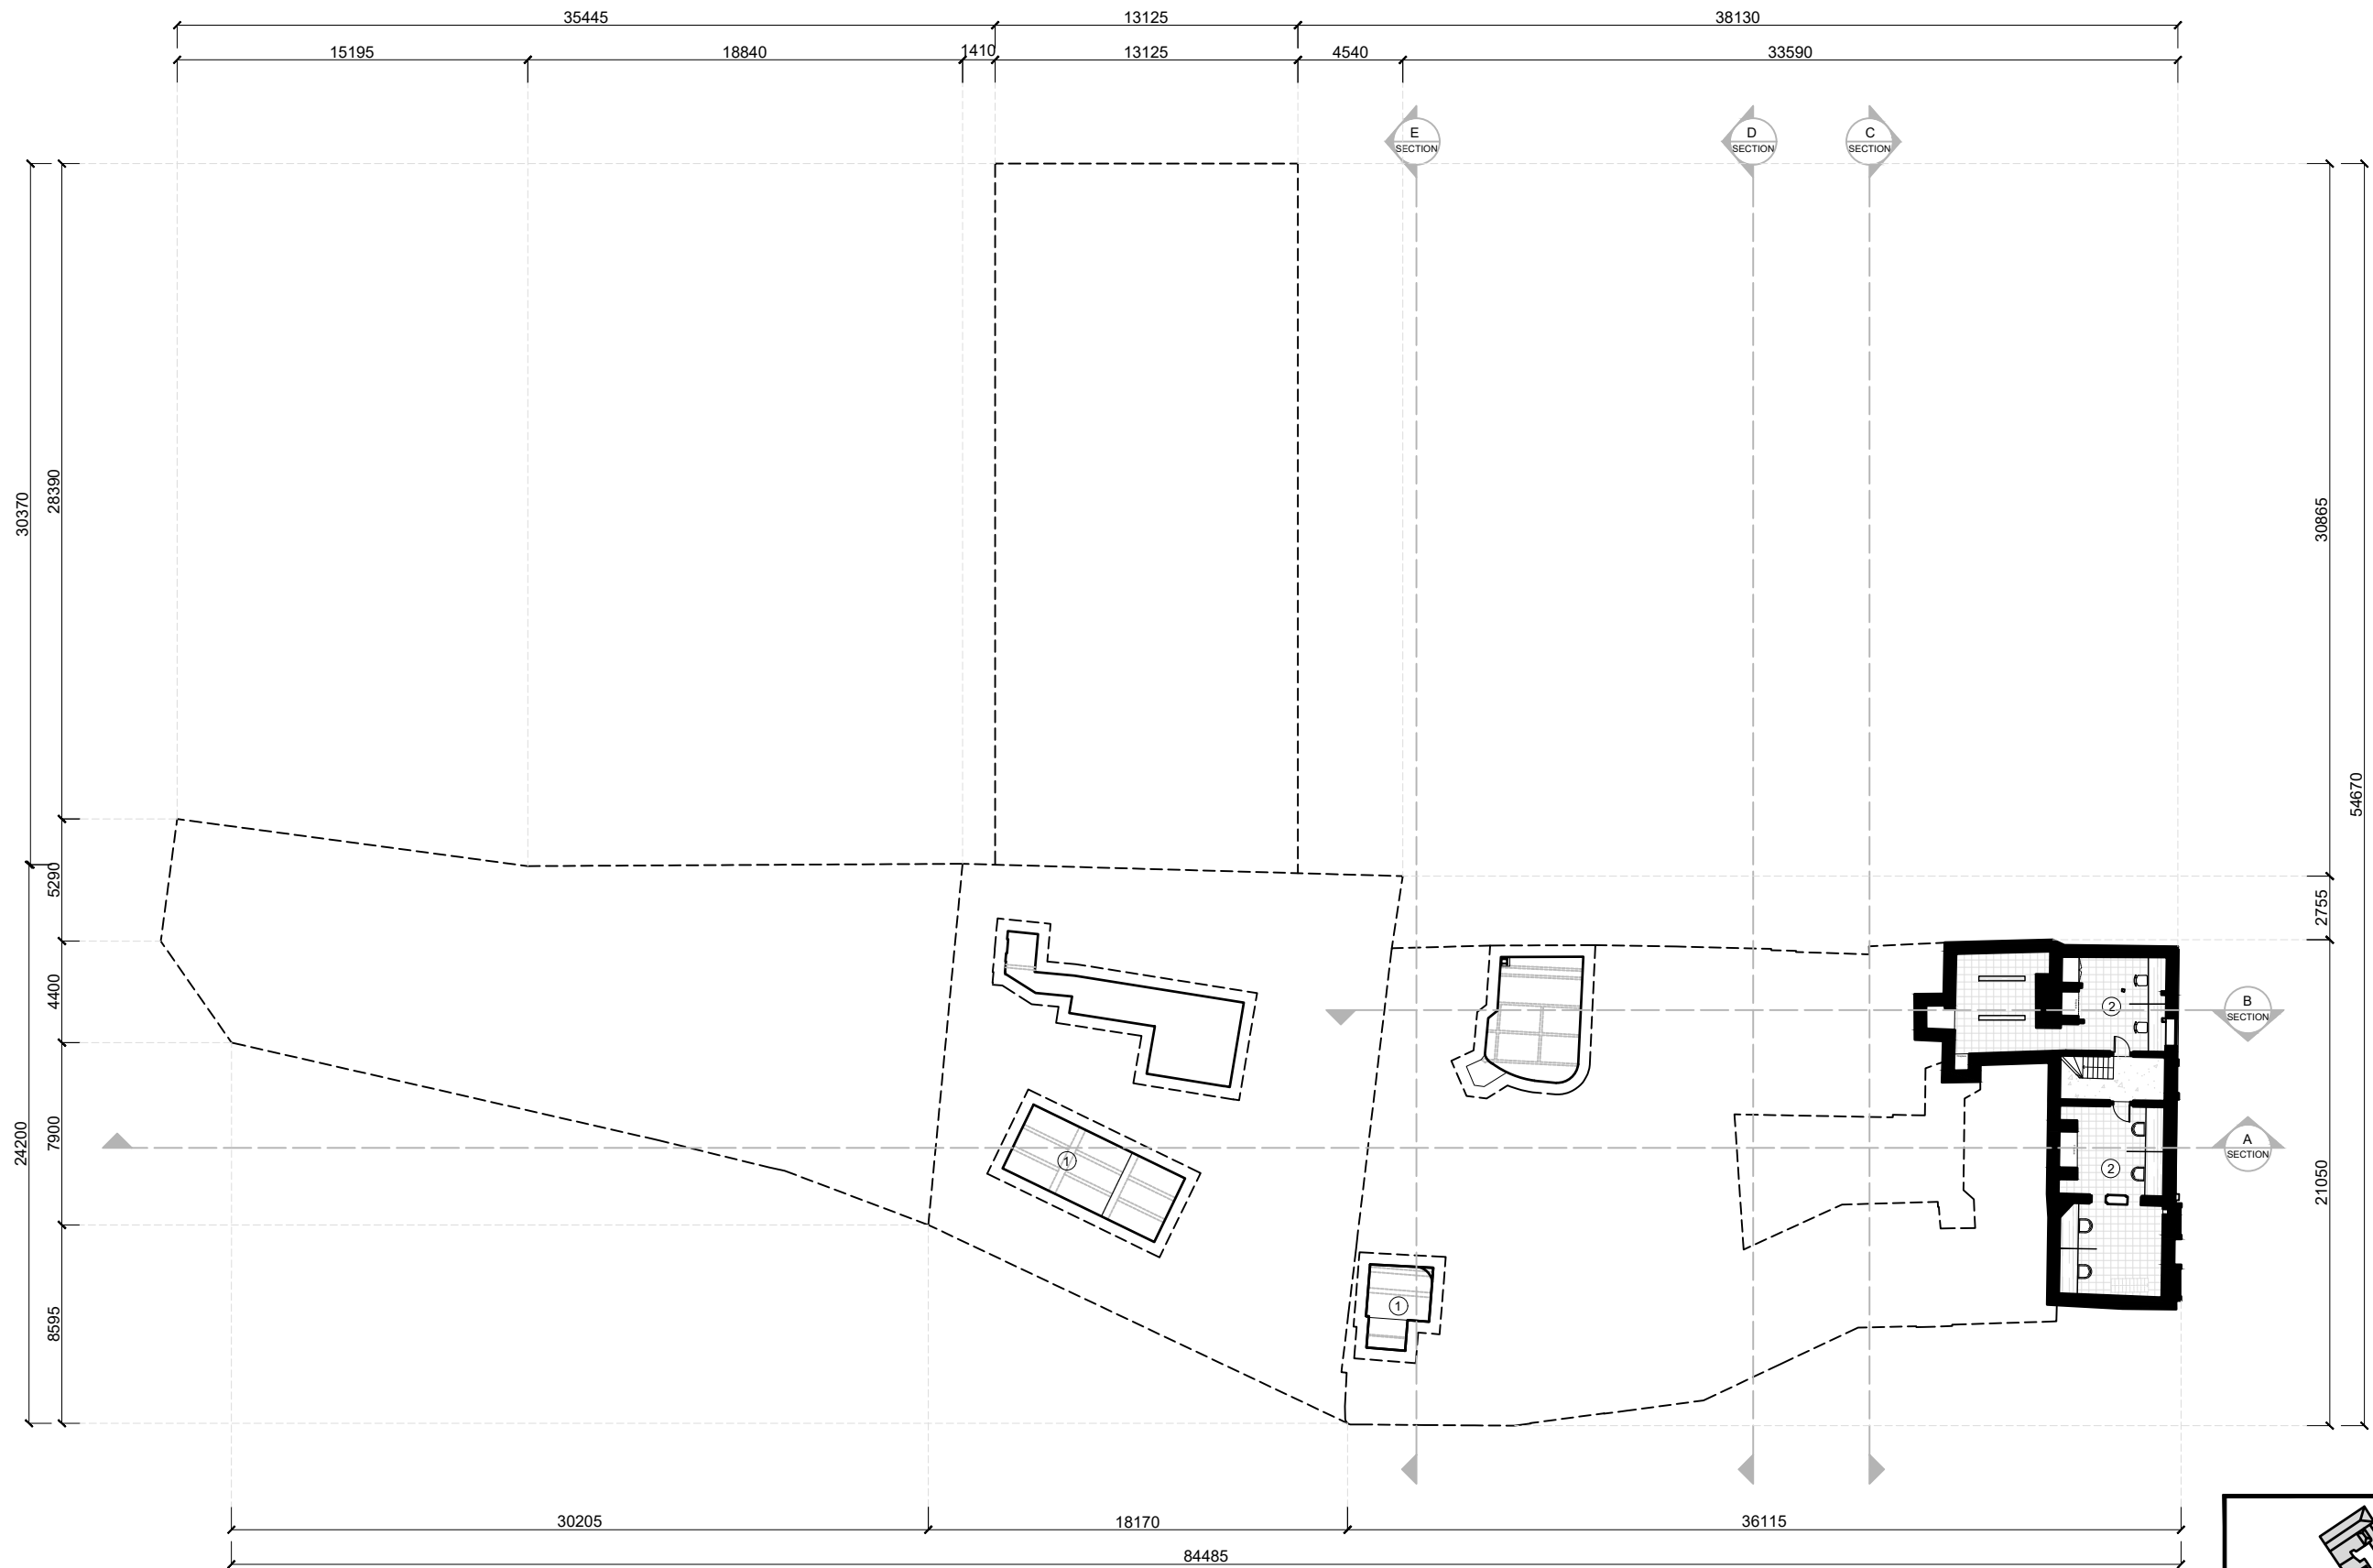

GENERAL NOTES

1. ALL DIMENSIONS ARE IN MILLIMETERS UNLESS OTHERWISE SPECIFIED. DO NOT SCALE THE DRAWINGS.
2. ALL DIMENSIONS SHALL BE VERIFIED ON SITE WITH CONTRACTORS BEFORE PROCEEDING WORK.
3. ALL DESIGNS ARE PROPERTY OF SO PAK LING. NO REPRODUCTION IS PERMITTED WITHOUT CONSENT.

SPECIFIC NOTES

REVISION		
NO.	DATE	ISSUE
01	30 NOV 2020	PROPOSED DESIGN LAYOUT
02	29 MAR 2021	REVISED LAYOUT

PROJECT TITLE
WHITECHAPEL HANDICRAFT LIBRARY

DRAWING TITLE
PROPOSED FLOOR PLAN - B1/F

PROJECT NO.
FMP-01


DATE
29 MAR 2021

DRAWN BY
SO PAK LING

REVISION NO.
02

SCALE
1:300 (A3)

DRAWING NO.
FP-02

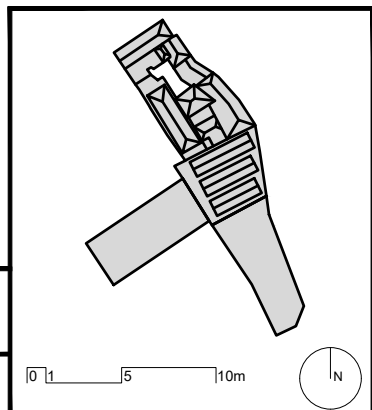



KS
Design

GENERAL NOTES

1. ALL DIMENSIONS ARE IN MILLIMETERS UNLESS OTHERWISE SPECIFIED.
2. DO NOT SCALE THE DRAWINGS.
3. ALL DIMENSIONS SHALL BE VERIFIED ON SITE WITH CONTRACTORS BEFORE PROCEEDING WORK.
4. ALL DESIGNS ARE PROPERTY OF SO PAK LING. NO REPRODUCTION IS PERMITTED WITHOUT CONSENT.

SPECIFIC NOTES

REVISION

NO.	DATE	ISSUE
01	30 NOV 2020	PROPOSED DESIGN LAYOUT
02	10 FEB 2021	UPDATED LAYOUT AS PER ADVICES
03	03 MAR 2021	REVISED LAYOUT
04	29 MAR 2021	REVISED LAYOUT

PROJECT TITLE

WHITECHAPEL HANDICRAFT LIBRARY

DRAWING TITLE

PROPOSED FLOOR PLAN - G/F

PROJECT NO.

FMP-01

DRAWN BY

SO PAK LING

SCALE

1:300 (A3)

DATE


29 MAR 2021

REVISION NO.

04


DRAWING NO.

FP-03

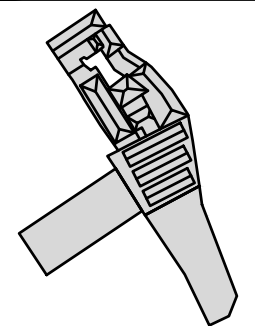

0 5 10m



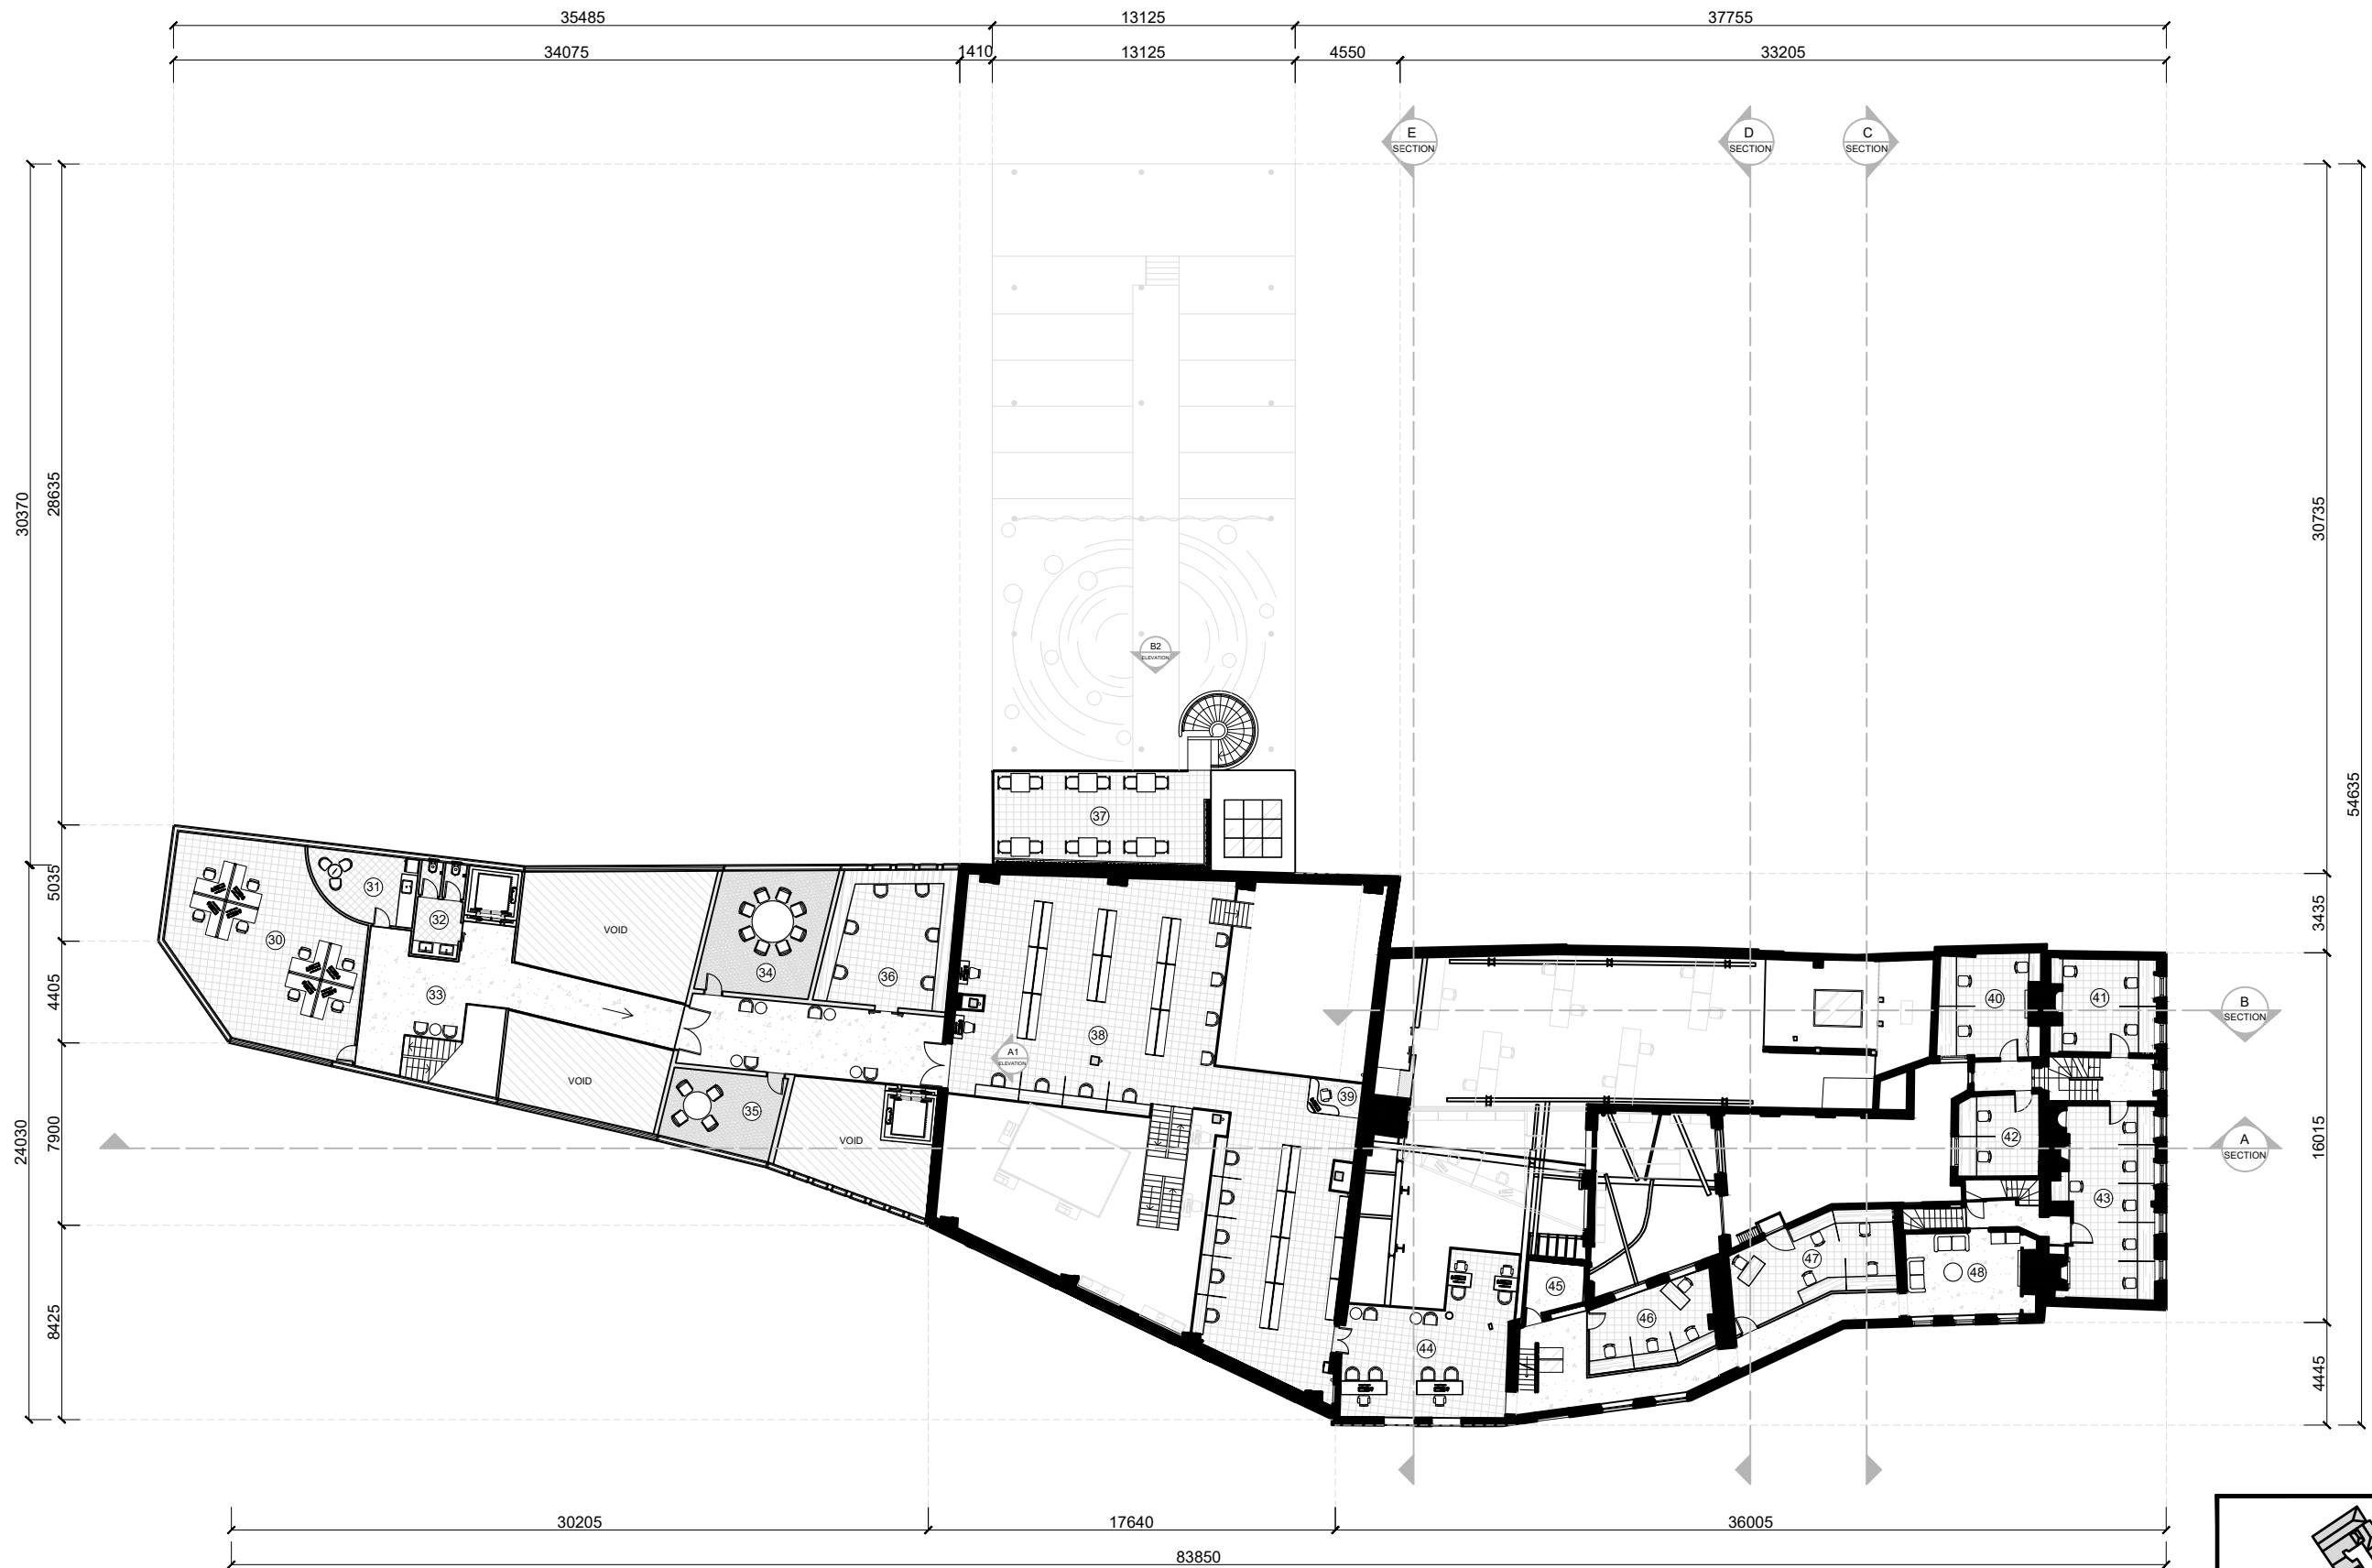

KS
Design

GENERAL NOTES

1. ALL DIMENSIONS ARE IN MILLIMETERS UNLESS OTHERWISE SPECIFIED.
2. DO NOT SCALE THE DRAWINGS.
3. ALL DIMENSIONS SHALL BE VERIFIED ON SITE WITH CONTRACTORS BEFORE PROCEEDING WORK.
4. ALL DESIGNS ARE PROPERTY OF SO PAK LING. NO REPRODUCTION IS PERMITTED WITHOUT CONSENT.

SPECIFIC NOTES

REVISION

NO.	DATE	ISSUE
01	30 NOV 2020	PROPOSED DESIGN LAYOUT
02	10 FEB 2021	UPDATED LAYOUT AS PER ADVICES
03	03 MAR 2021	REVISED LAYOUT
04	29 MAR 2021	REVISED LAYOUT

PROJECT TITLE

WHITECHAPEL HANDICRAFT LIBRARY

DRAWING TITLE

PROPOSED FLOOR PLAN - 1/F

PROJECT NO.

FMP-01

DATE

29 MAR 2021

DRAWN BY

SO PAK LING

REVISION NO.


04


SCALE

1:300 (A3)

DRAWING NO.

FP-04

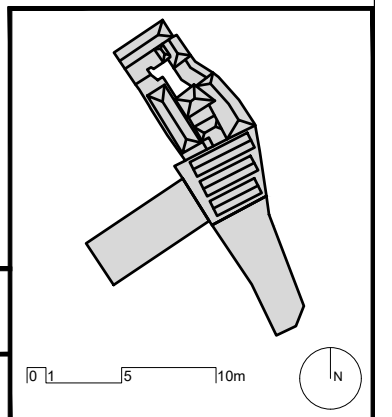

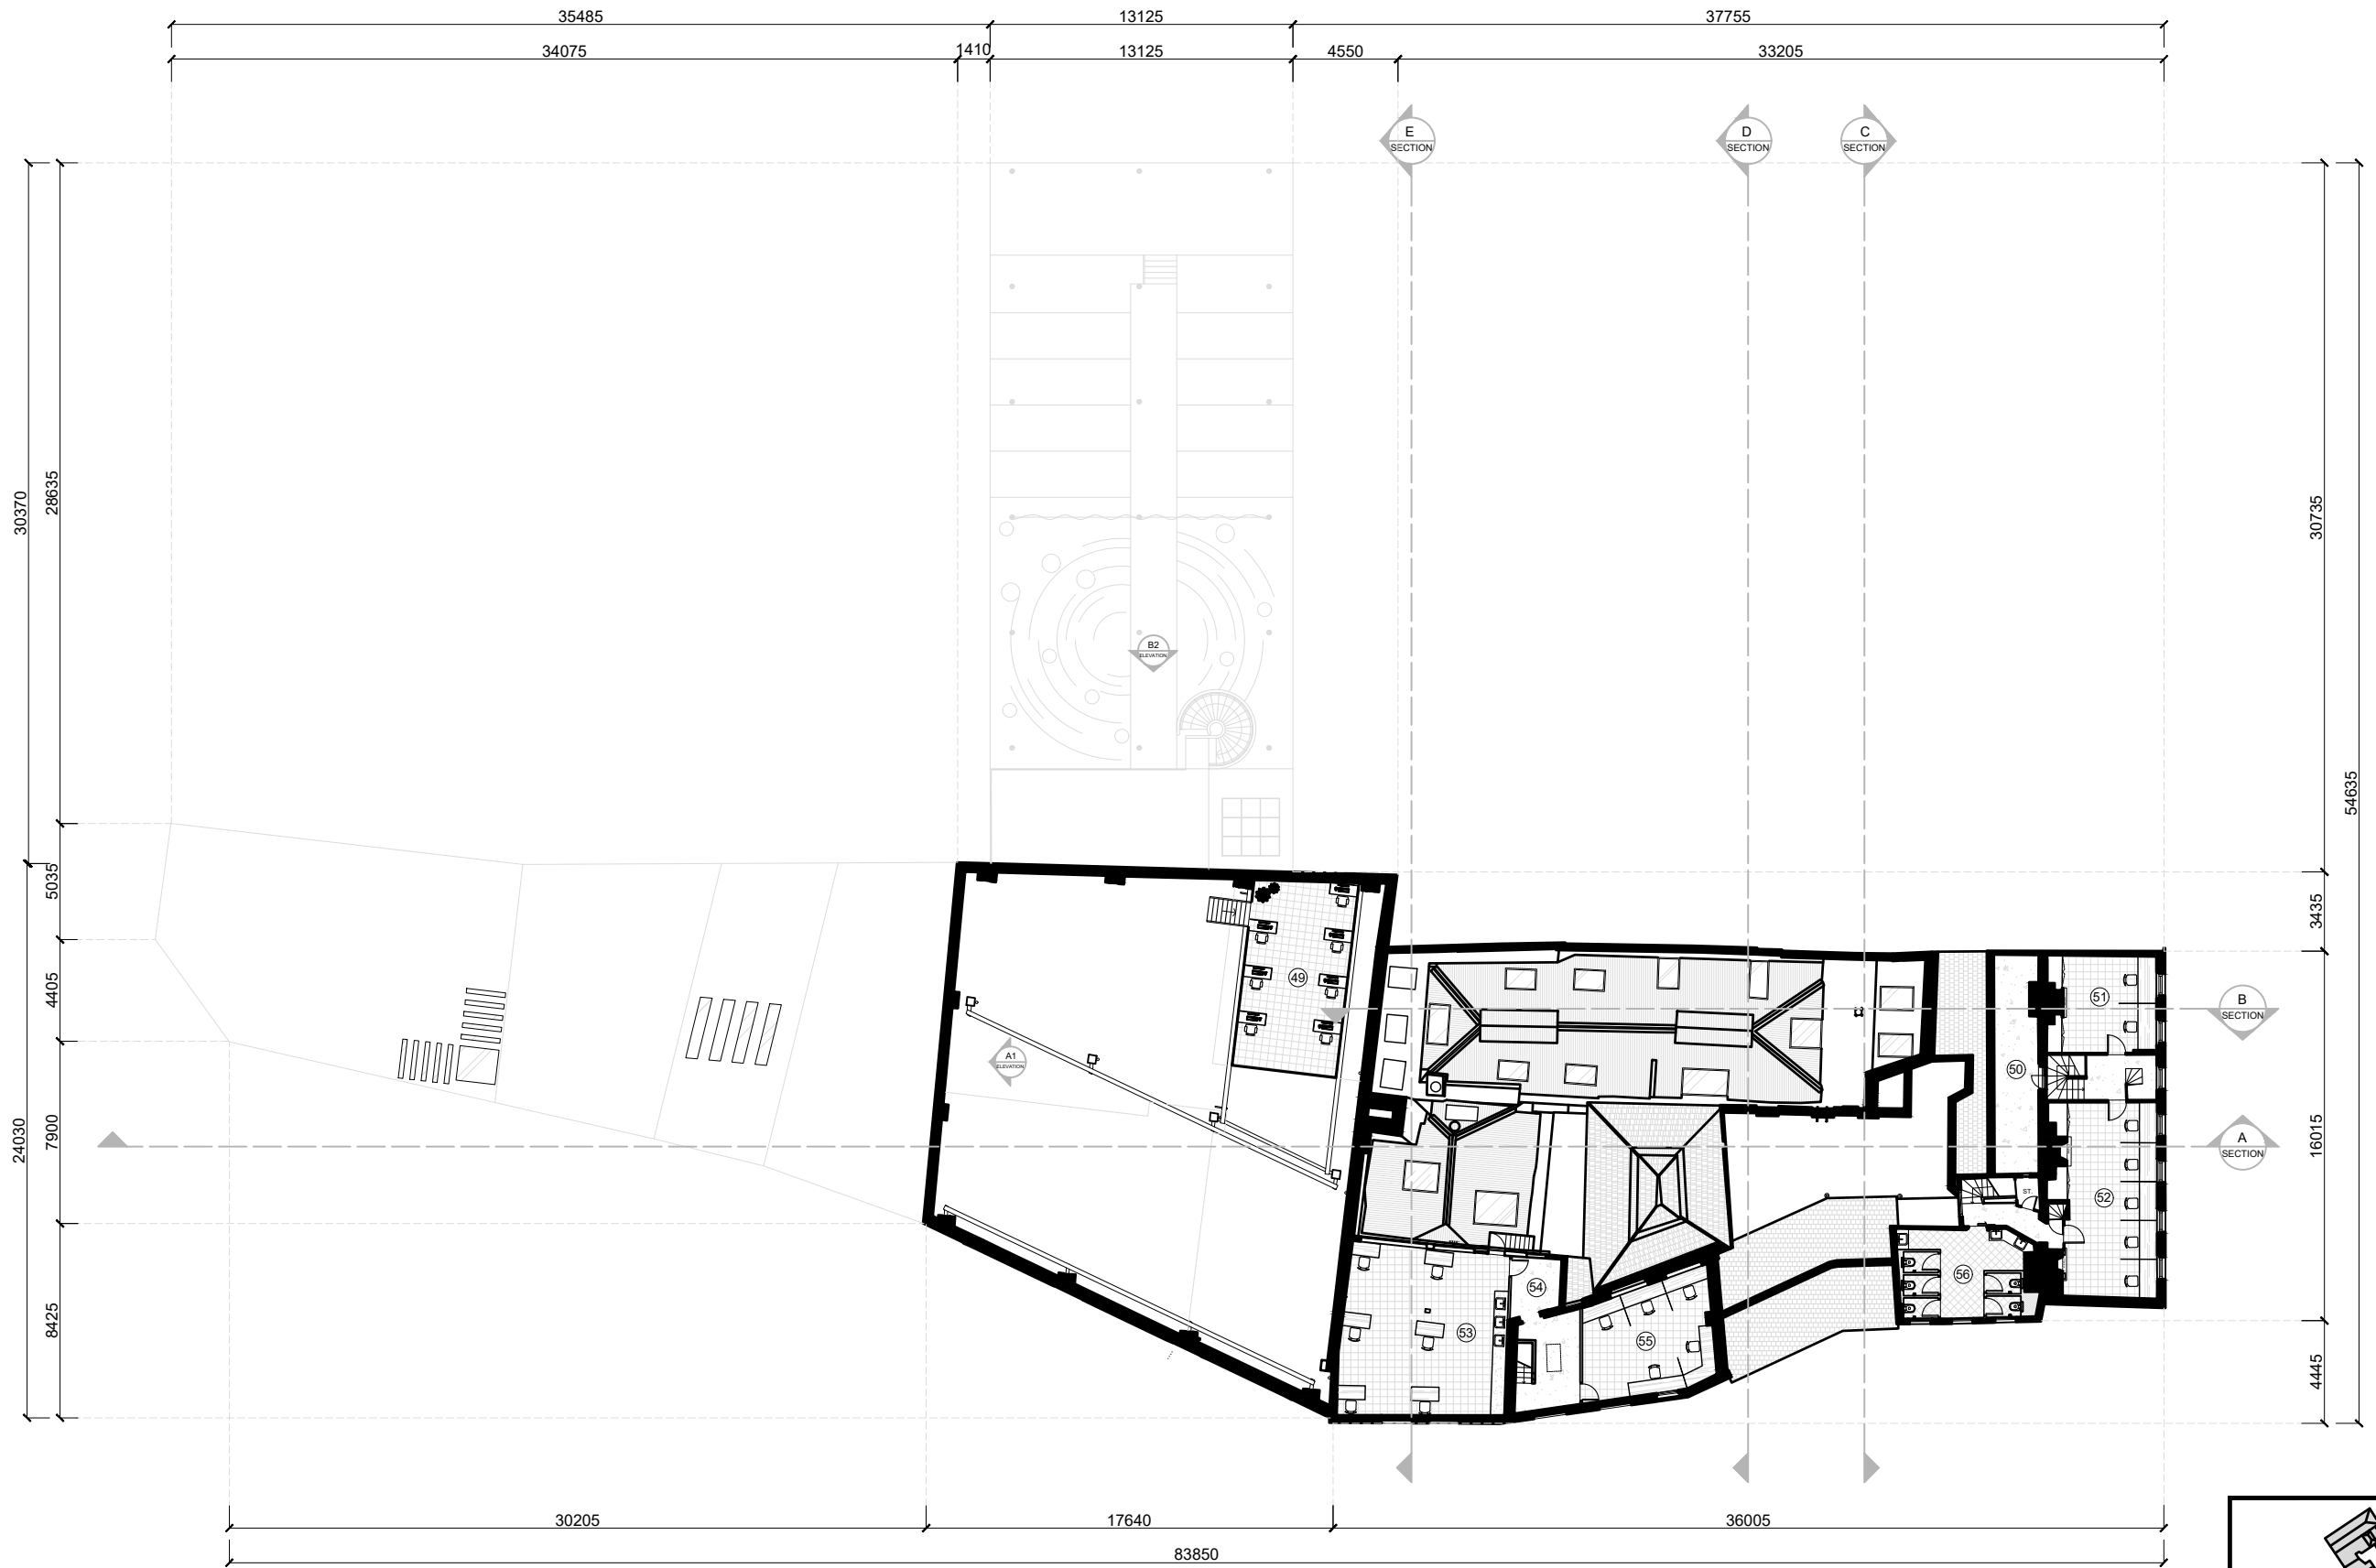

KS
Design

GENERAL NOTES

1. ALL DIMENSIONS ARE IN MILLIMETERS UNLESS OTHERWISE SPECIFIED.
2. DO NOT SCALE THE DRAWINGS.
3. ALL DIMENSIONS SHALL BE VERIFIED ON SITE WITH CONTRACTORS BEFORE PROCEEDING WORK.
4. ALL DESIGNS ARE PROPERTY OF SO PAK LING. NO REPRODUCTION IS PERMITTED WITHOUT CONSENT.

SPECIFIC NOTES

REVISION

NO.	DATE	ISSUE
01	30 NOV 2020	PROPOSED DESIGN LAYOUT
02	03 MAR 2021	REVISED LAYOUT
03	29 MAR 2021	REVISED LAYOUT

PROJECT TITLE

WHITECHAPEL HANDICRAFT LIBRARY

DRAWING TITLE

PROPOSED FLOOR PLAN - 2/F

PROJECT NO.

FMP-01

DRAWN BY

SO PAK LING

SCALE

1:300 (A3)

DATE


29 MAR 2021


REVISION NO.

03

DRAWING NO.

FP-05

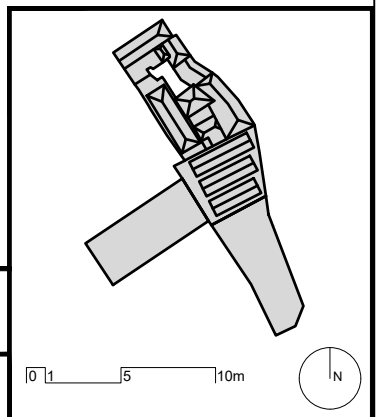

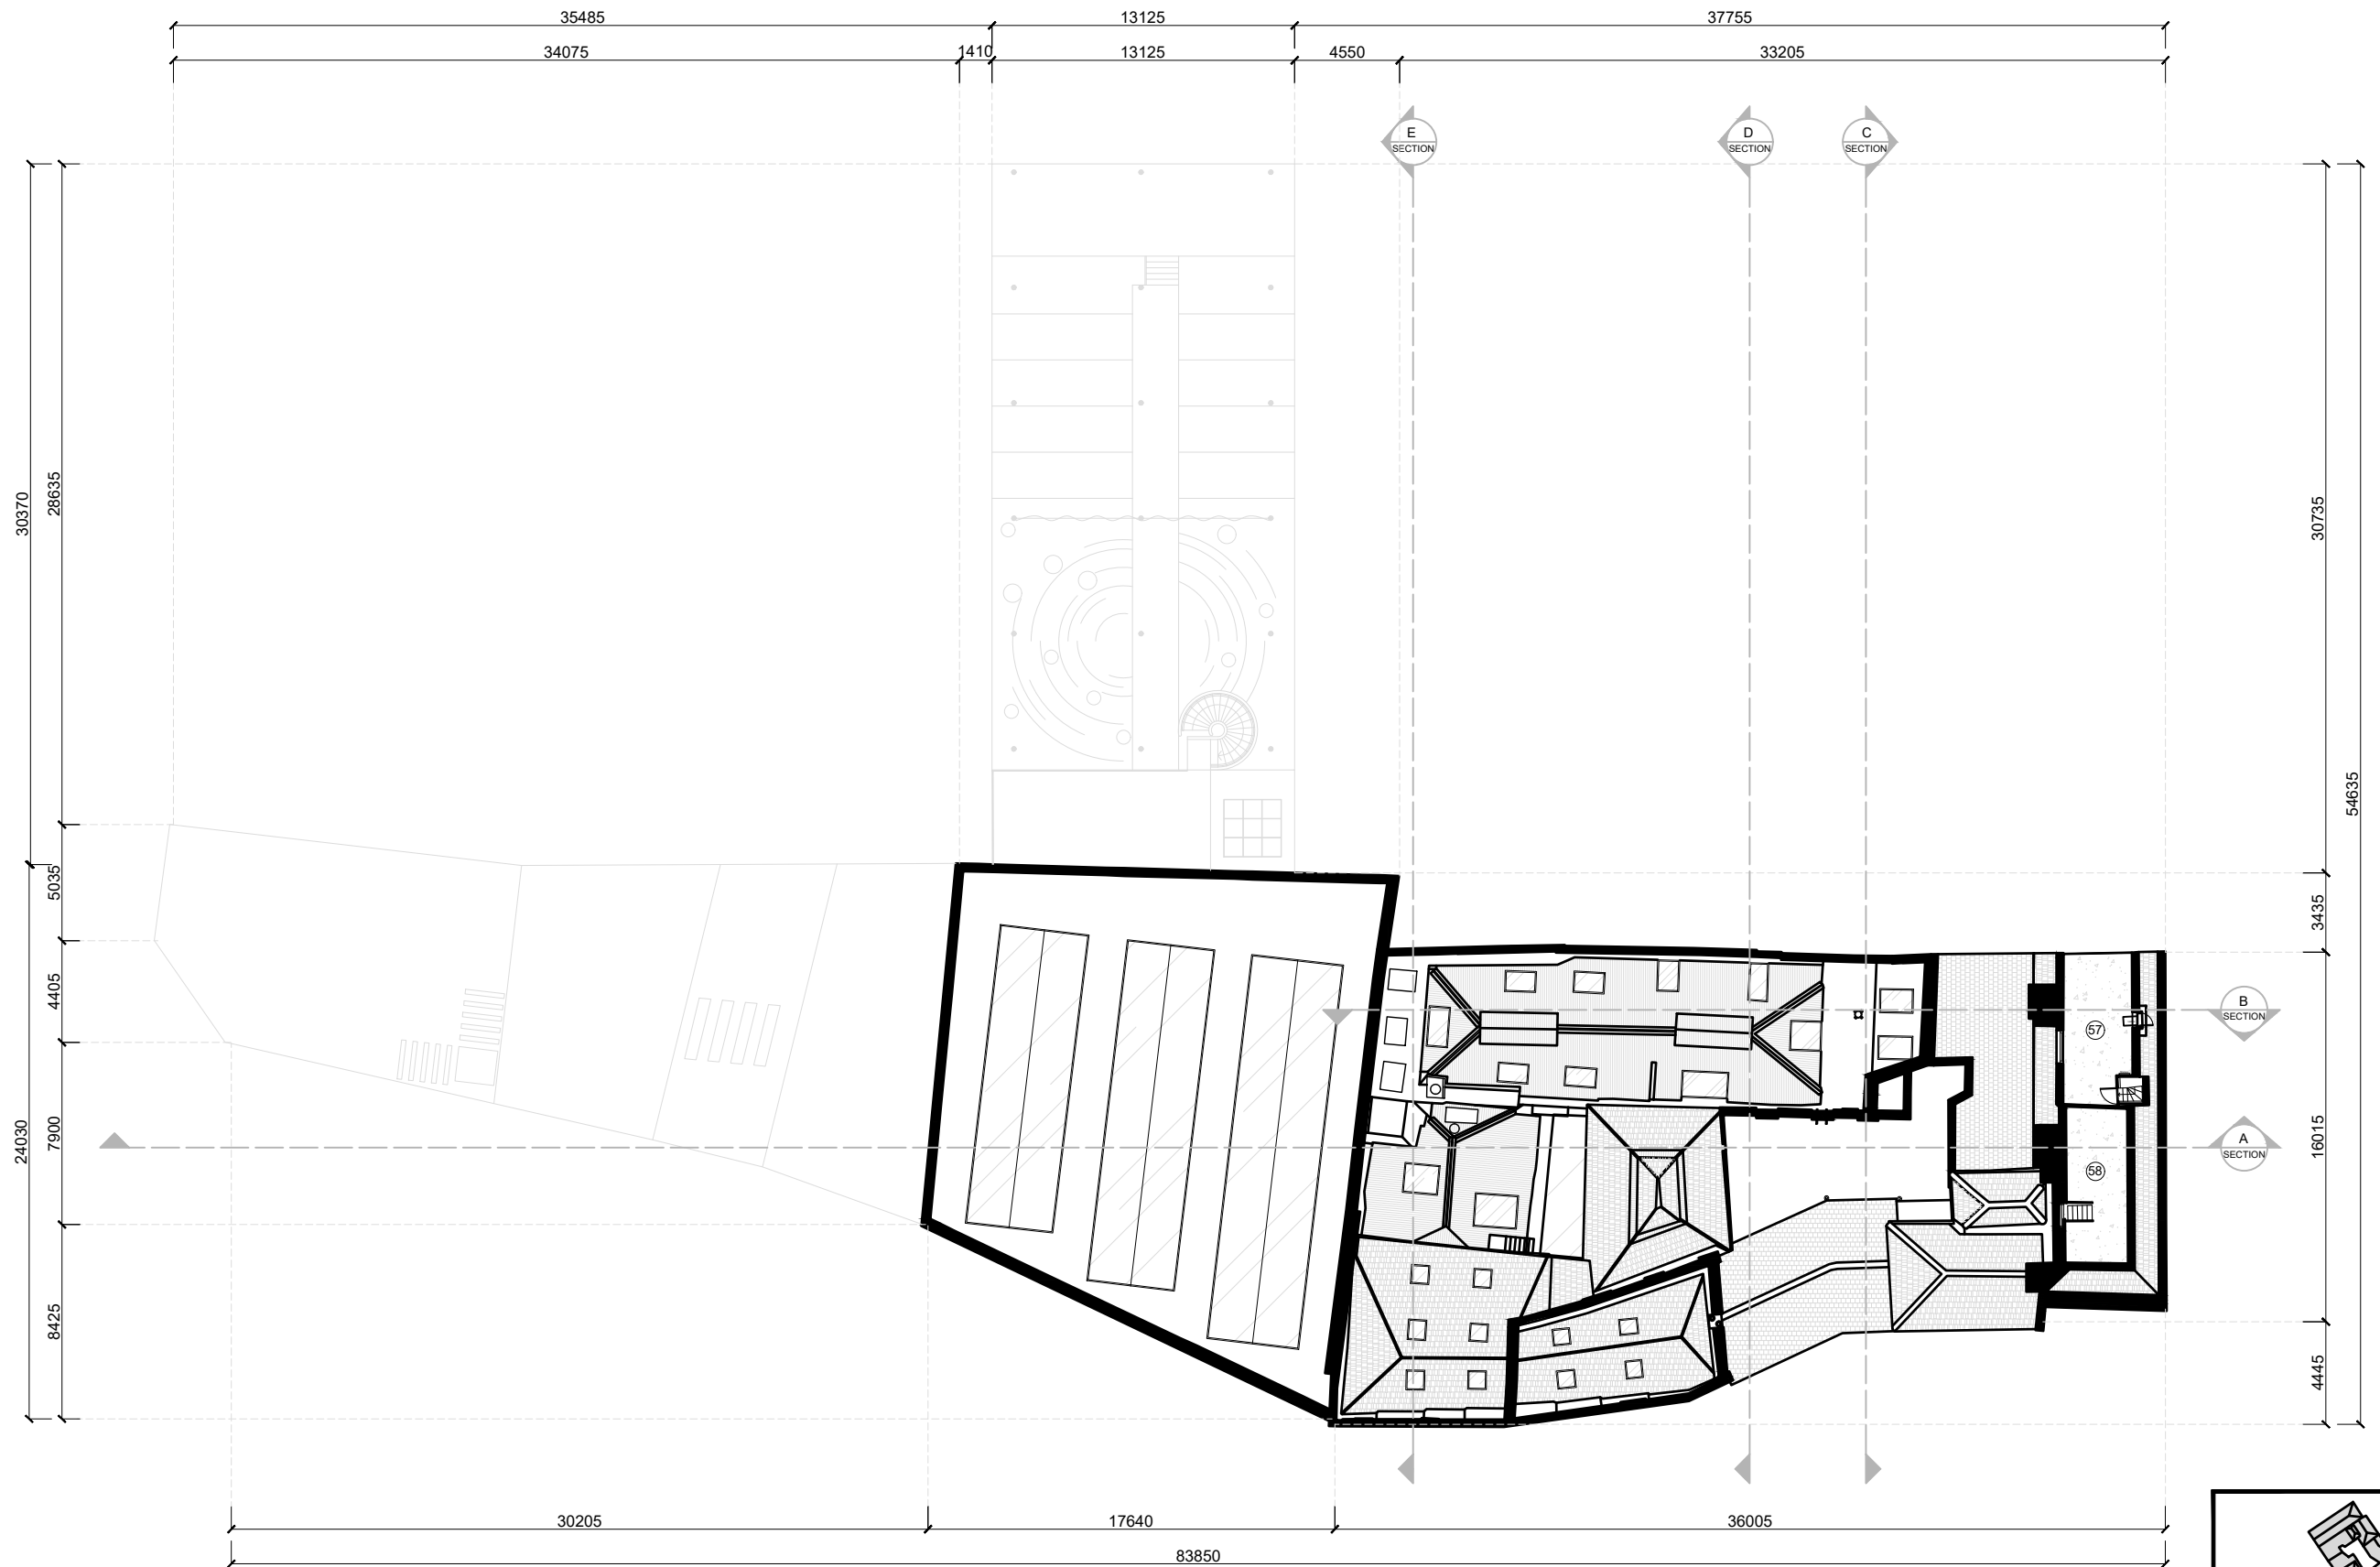

KS
Design

GENERAL NOTES

1. ALL DIMENSIONS ARE IN MILLIMETERS UNLESS OTHERWISE SPECIFIED.
2. DO NOT SCALE THE DRAWINGS.
3. ALL DIMENSIONS SHALL BE VERIFIED ON SITE WITH CONTRACTORS BEFORE PROCEEDING WORK.
4. ALL DESIGNS ARE PROPERTY OF SO PAK LING. NO REPRODUCTION IS PERMITTED WITHOUT CONSENT.

SPECIFIC NOTES

REVISION

NO.	DATE	ISSUE
01	30 NOV 2020	PROPOSED DESIGN LAYOUT
02	29 MAR 2021	REVISED LAYOUT

PROJECT TITLE

WHITECHAPEL HANDICRAFT LIBRARY

DRAWING TITLE

PROPOSED FLOOR PLAN - 3/F

PROJECT NO.

FMP-01

DRAWN BY

SO PAK LING

SCALE

1:300 (A3)

DATE


29 MAR 2021


REVISION NO.

02

DRAWING NO.

FP-06

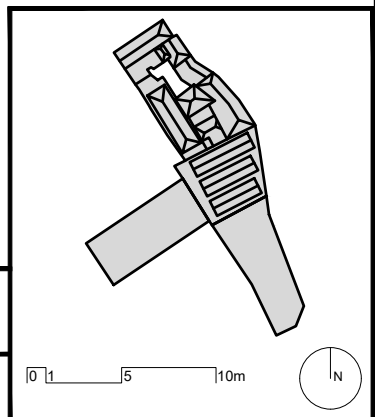

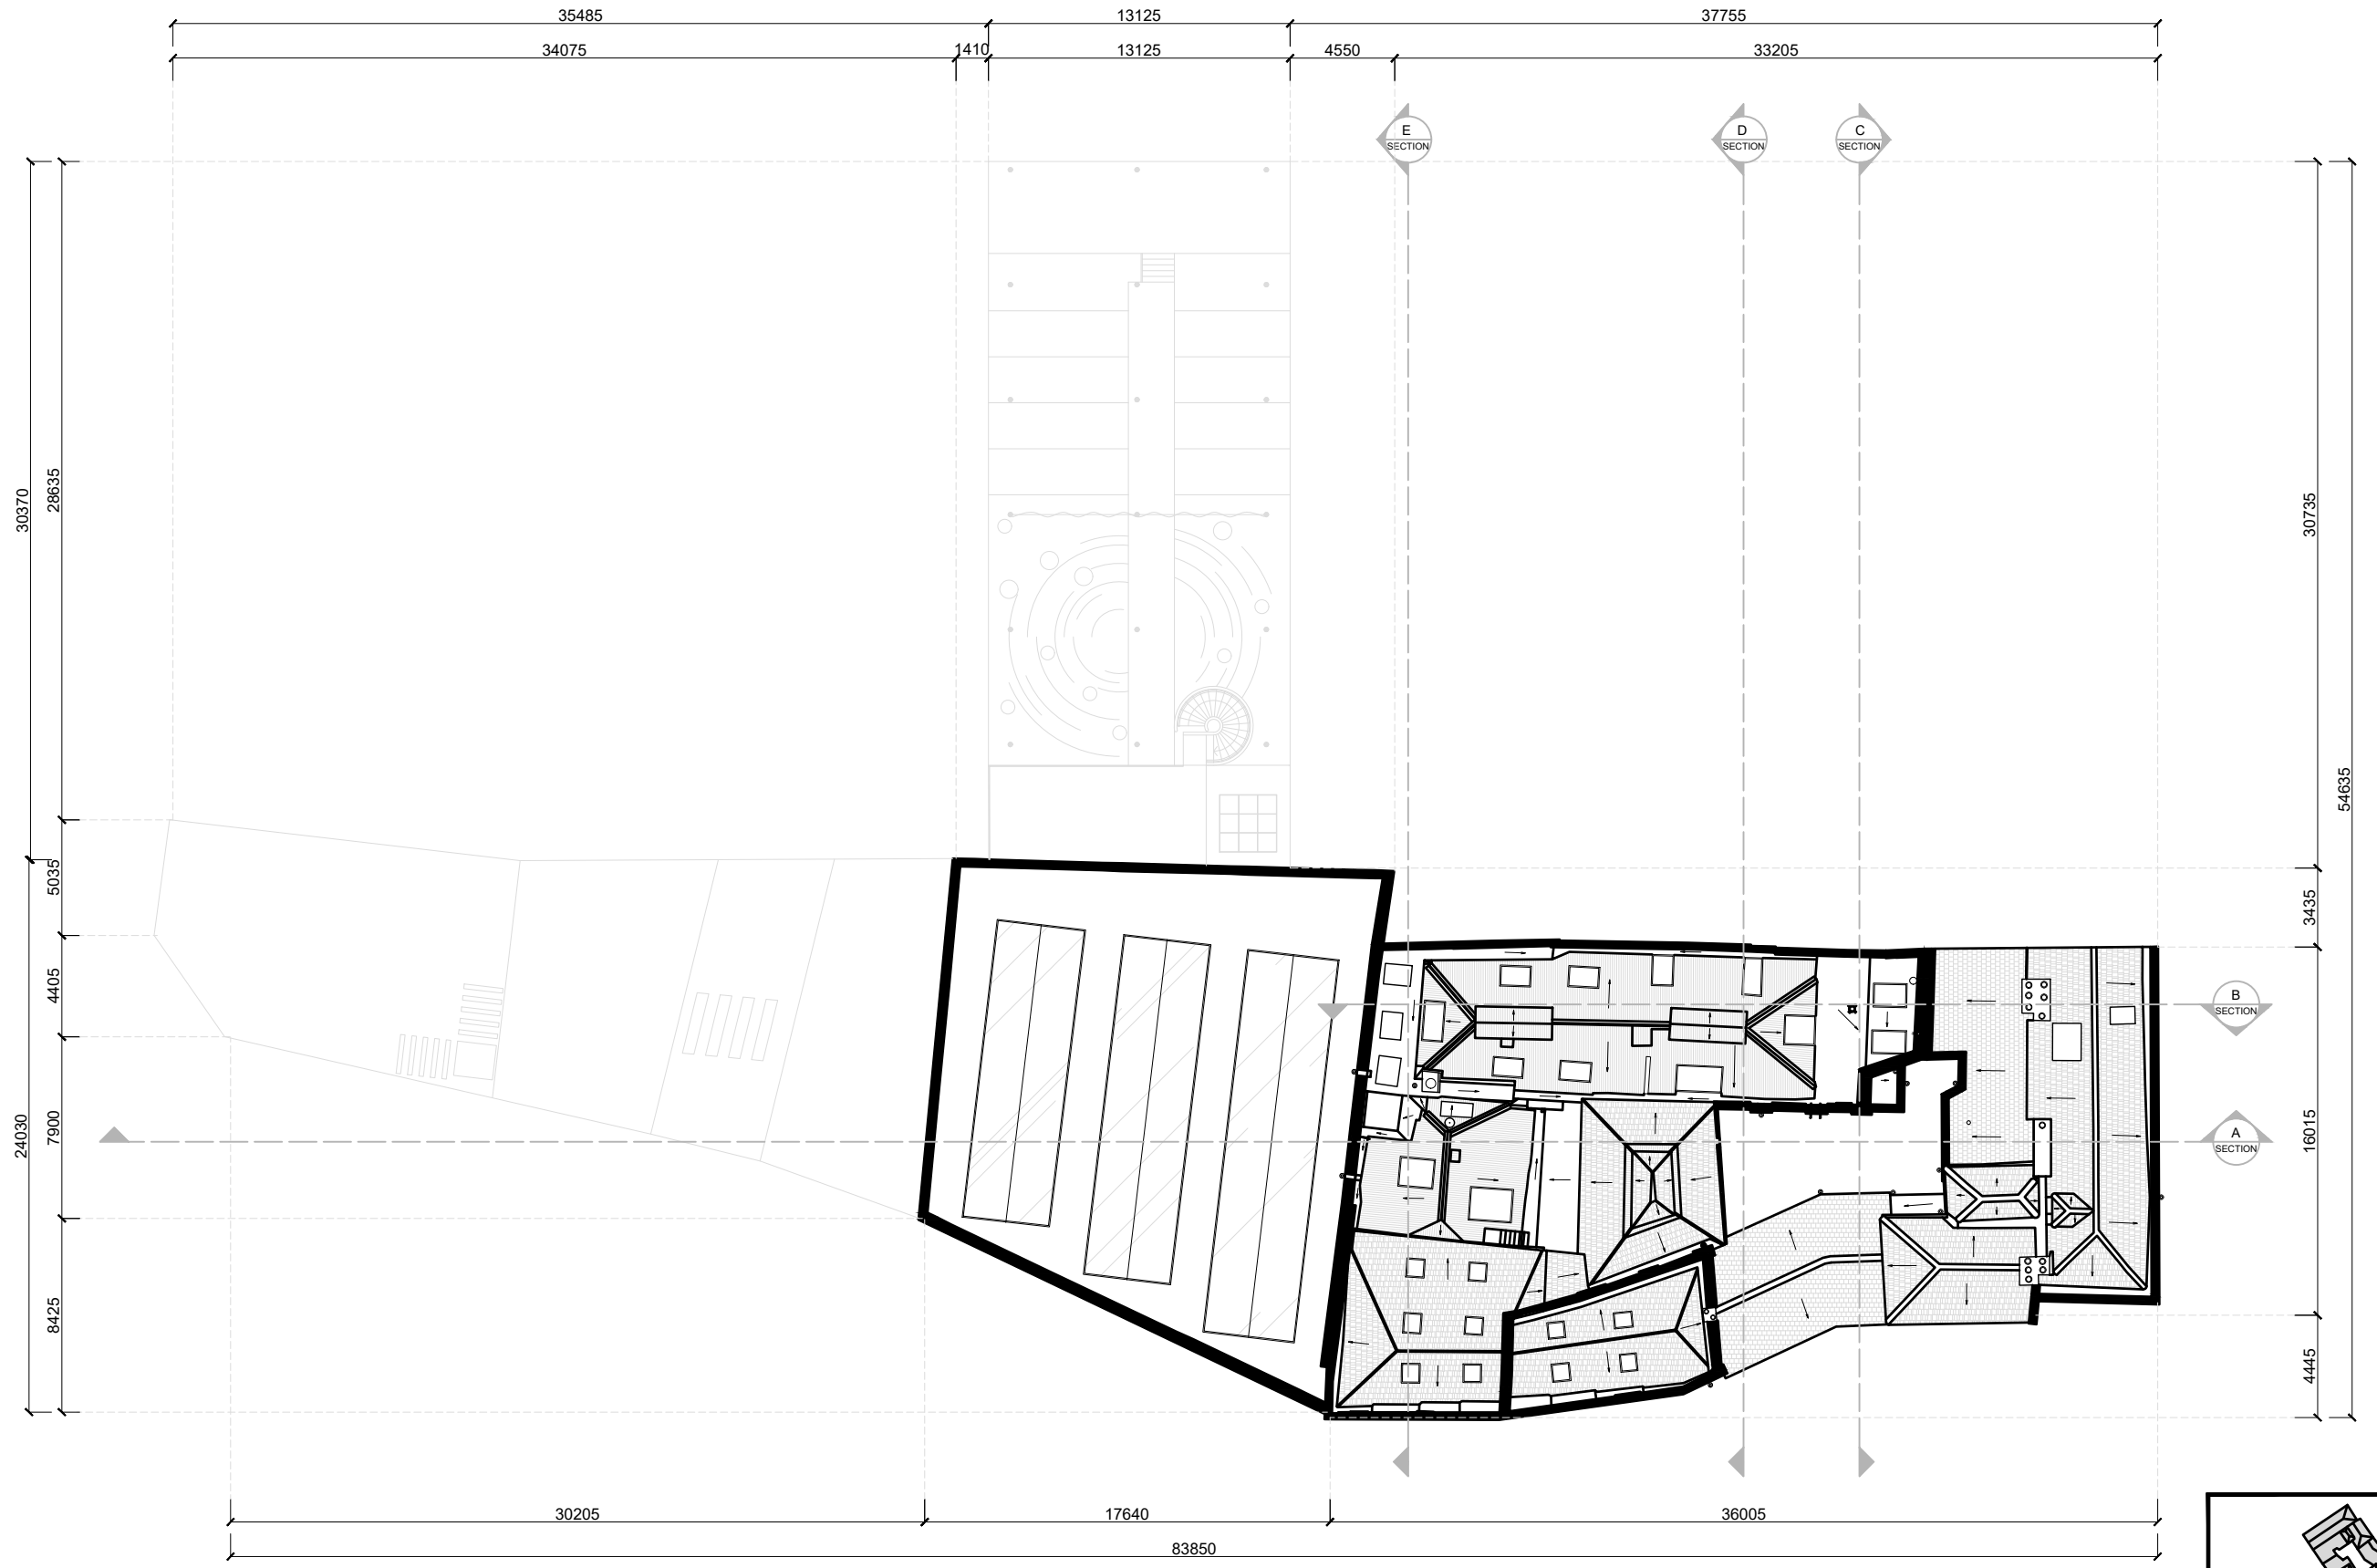

KS
Design

- GENERAL NOTES
1. ALL DIMENSIONS ARE IN MILLIMETERS UNLESS OTHERWISE SPECIFIED.
 2. DO NOT SCALE THE DRAWINGS.
 3. ALL DIMENSIONS SHALL BE VERIFIED ON SITE WITH CONTRACTORS BEFORE PROCEEDING WORK.
 4. ALL DESIGNS ARE PROPERTY OF SO PAK LING. NO REPRODUCTION IS PERMITTED WITHOUT CONSENT.

SPECIFIC NOTES

REVISION		
NO.	DATE	ISSUE
01	30 NOV 2020	PROPOSED DESIGN LAYOUT
02	29 MAR 2021	REVISED LAYOUT

PROJECT TITLE
WHITECHAPEL HANDICRAFT LIBRARY

DRAWING TITLE
PROPOSED FLOOR PLAN - ROOF

PROJECT NO.
FMP-01


DRAWN BY
SO PAK LING


SCALE
1:300 (A3)

DATE
29 MAR 2021

REVISION NO.
02

DRAWING NO.
FP-07

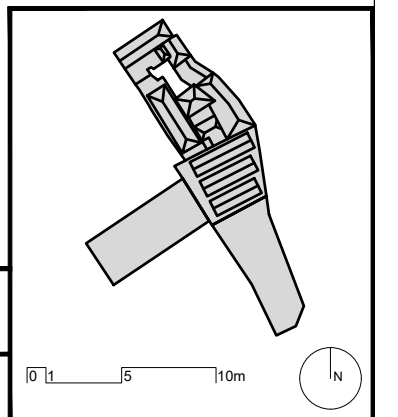

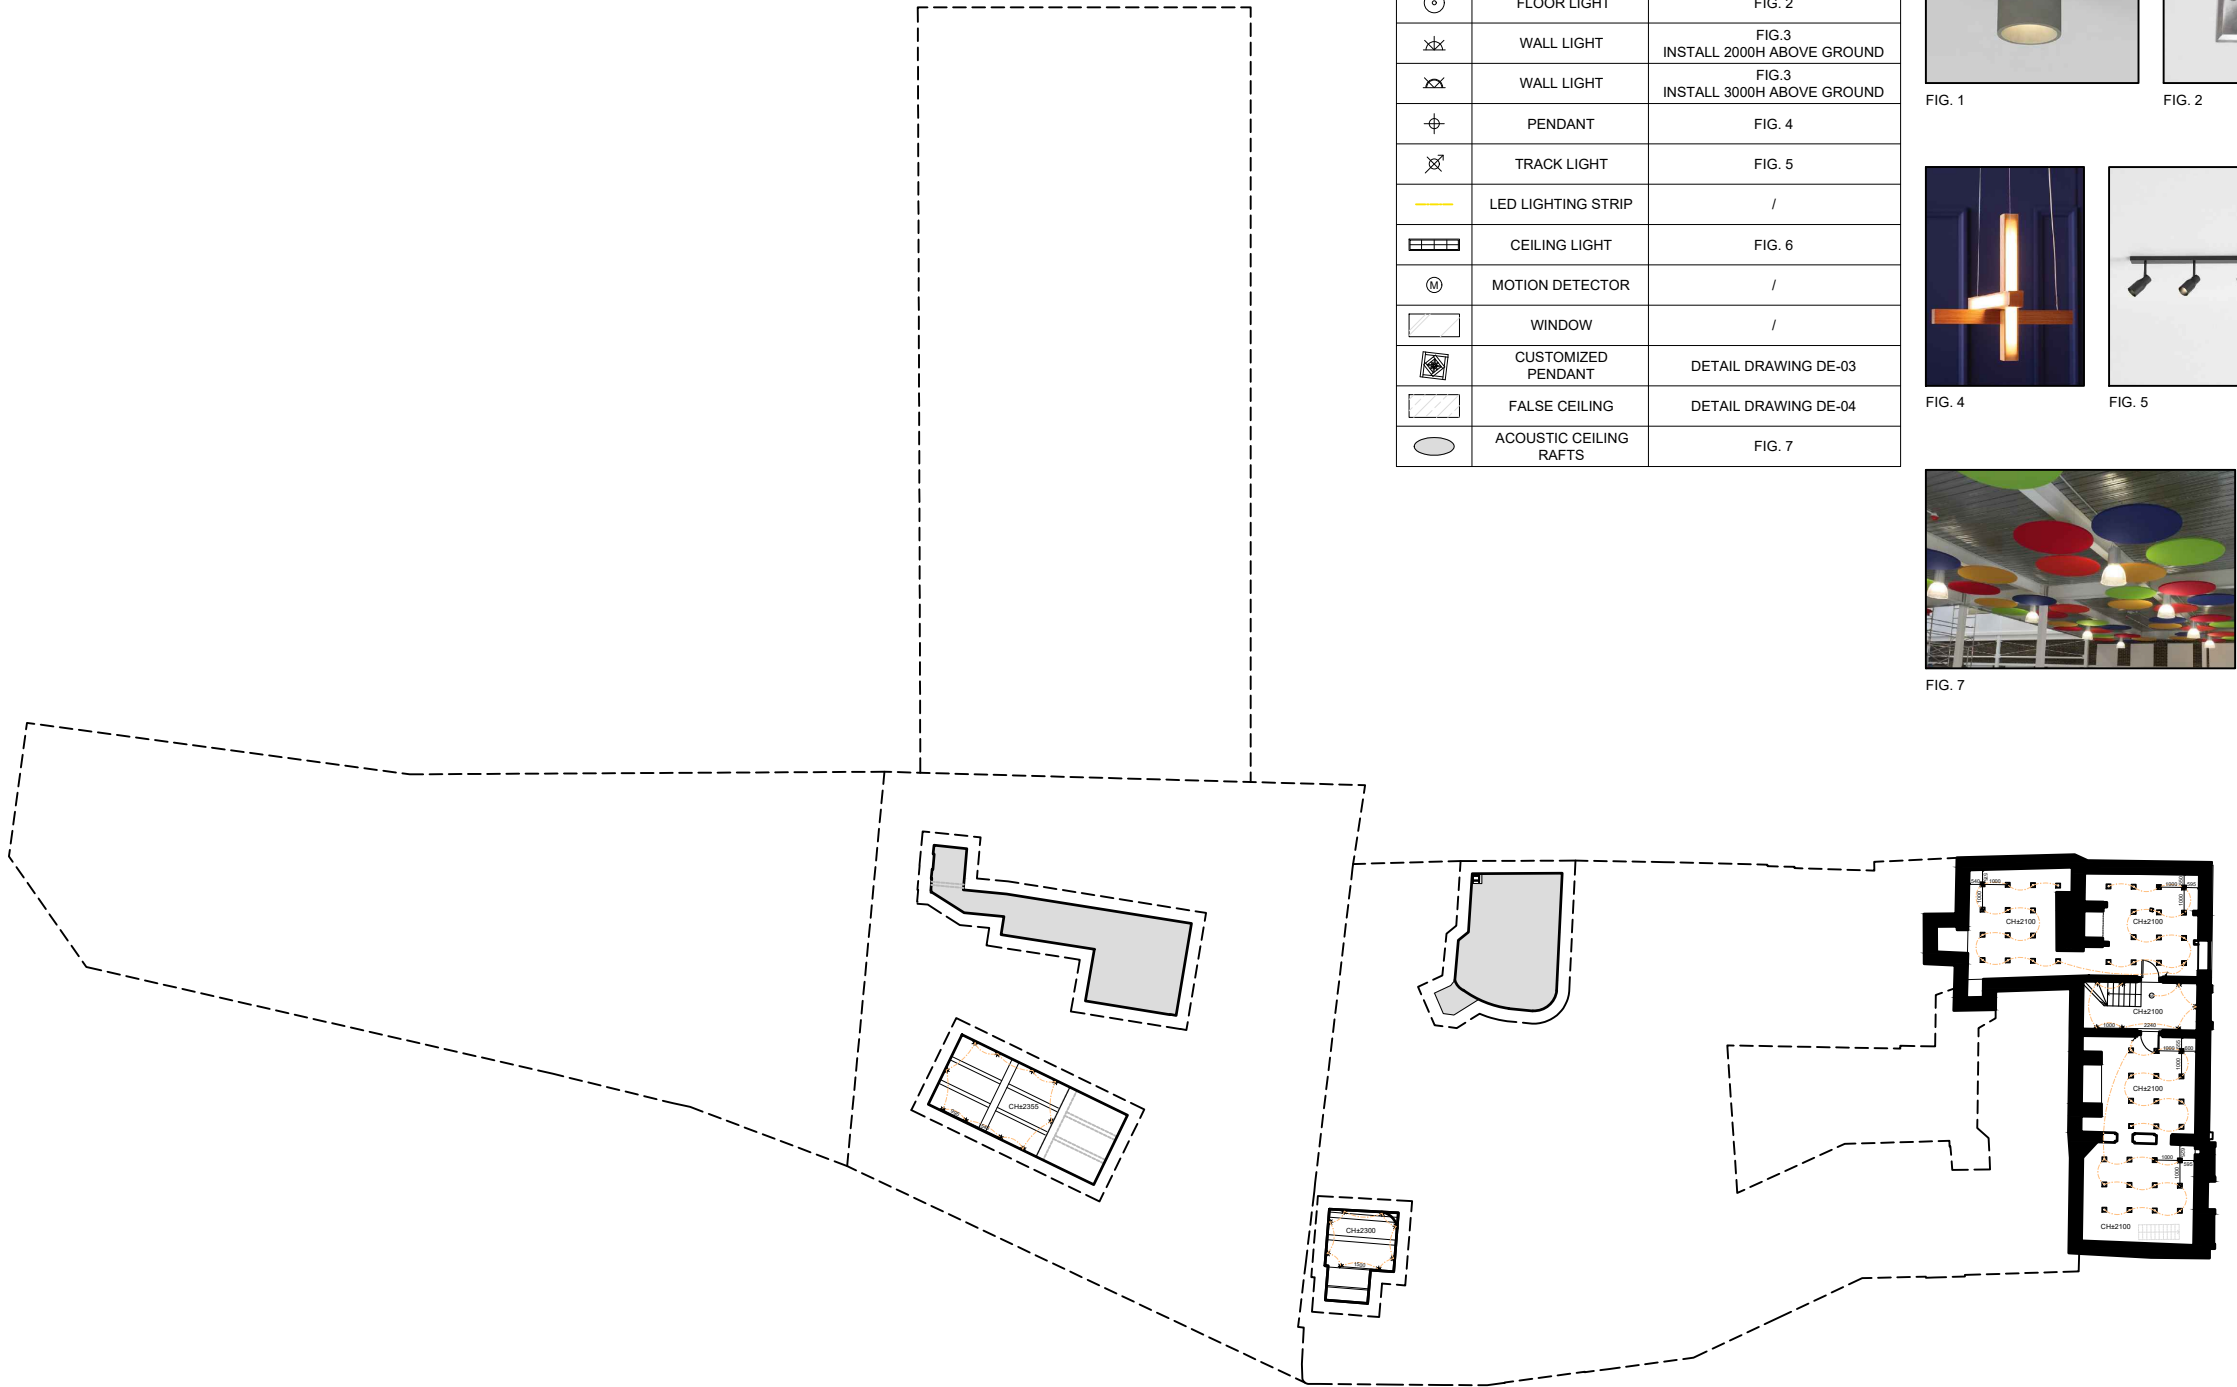

LIGHTING LEGEND

SYMBOL	DESCRIPTION	REMARKS
	DOWN LIGHT	FIG. 1
	FLOOR LIGHT	FIG. 2
	WALL LIGHT	FIG.3 INSTALL 2000H ABOVE GROUND
	WALL LIGHT	FIG.3 INSTALL 3000H ABOVE GROUND
	PENDANT	FIG. 4
	TRACK LIGHT	FIG. 5
	LED LIGHTING STRIP	/
	CEILING LIGHT	FIG. 6
	MOTION DETECTOR	/
	WINDOW	/
	CUSTOMIZED PENDANT	DETAIL DRAWING DE-03
	FALSE CEILING	DETAIL DRAWING DE-04
	ACOUSTIC CEILING RAFTS	FIG. 7



FIG. 1



FIG. 2



FIG. 3



FIG. 4



FIG. 5



FIG. 6



FIG. 7

KS
Design

GENERAL NOTES

1. ALL DIMENSIONS ARE IN MILLIMETERS UNLESS OTHERWISE SPECIFIED.
2. DO NOT SCALE THE DRAWINGS.
3. ALL DIMENSIONS SHALL BE VERIFIED ON SITE WITH CONTRACTORS BEFORE PROCEEDING WORK.
4. ALL DESIGNS ARE PROPERTY OF SO PAK LING. NO REPRODUCTION IS PERMITTED WITHOUT CONSENT.

SPECIFIC NOTES

1. MATERIAL AND LOOSE FURNITURE ARE SUBJECT TO CHANGE UPON AVAILABILITY

REFERENCE

FIG. 1 Aelio Lighting (2021) Aelio Round [online] available from: <https://www.aelighting.com/products/aelio-1> [1 March 2021]
FIG. 2 Aelio Lighting (2021) Aelio Square [online] available from: <https://www.aelighting.com/products/aelio-2> [1 March 2021]
FIG. 3 Aelio Lighting (2021) Aelio Wall & Ceiling [online] available from: <https://www.aelighting.com/products/aelio-3> [1 March 2021]
FIG. 4 Aelio Lighting (2021) Aelio Pendant [online] available from: <https://www.aelighting.com/products/aelio-4> [1 March 2021]
FIG. 5 Aelio Lighting (2021) Aelio Track [online] available from: <https://www.aelighting.com/products/aelio-5> [1 March 2021]
FIG. 6 Aelio Lighting (2021) Aelio Ceiling [online] available from: <https://www.aelighting.com/products/aelio-6> [1 March 2021]
FIG. 7 Aelio Lighting (2021) Aelio Acoustic [online] available from: <https://www.aelighting.com/products/aelio-7> [1 March 2021]

REVISION

NO.	DATE	ISSUE
01	22 MAR 2021	PROPOSED DESIGN LAYOUT
02	19 APR 2021	UPDATED LEGEND

PROJECT TITLE

WHITECHAPEL HANDICRAFT LIBRARY

DRAWING TITLE

REFLECTIVE CEILING AND LIGHTING PLAN - B1/F

PROJECT NO.

FMP-01

DATE

19 APR 2021

DRAWN BY

SO PAK LING

REVISION NO.

02

SCALE


1:300 (A3)

DRAWING NO.

CP-01

0 1 5 10m



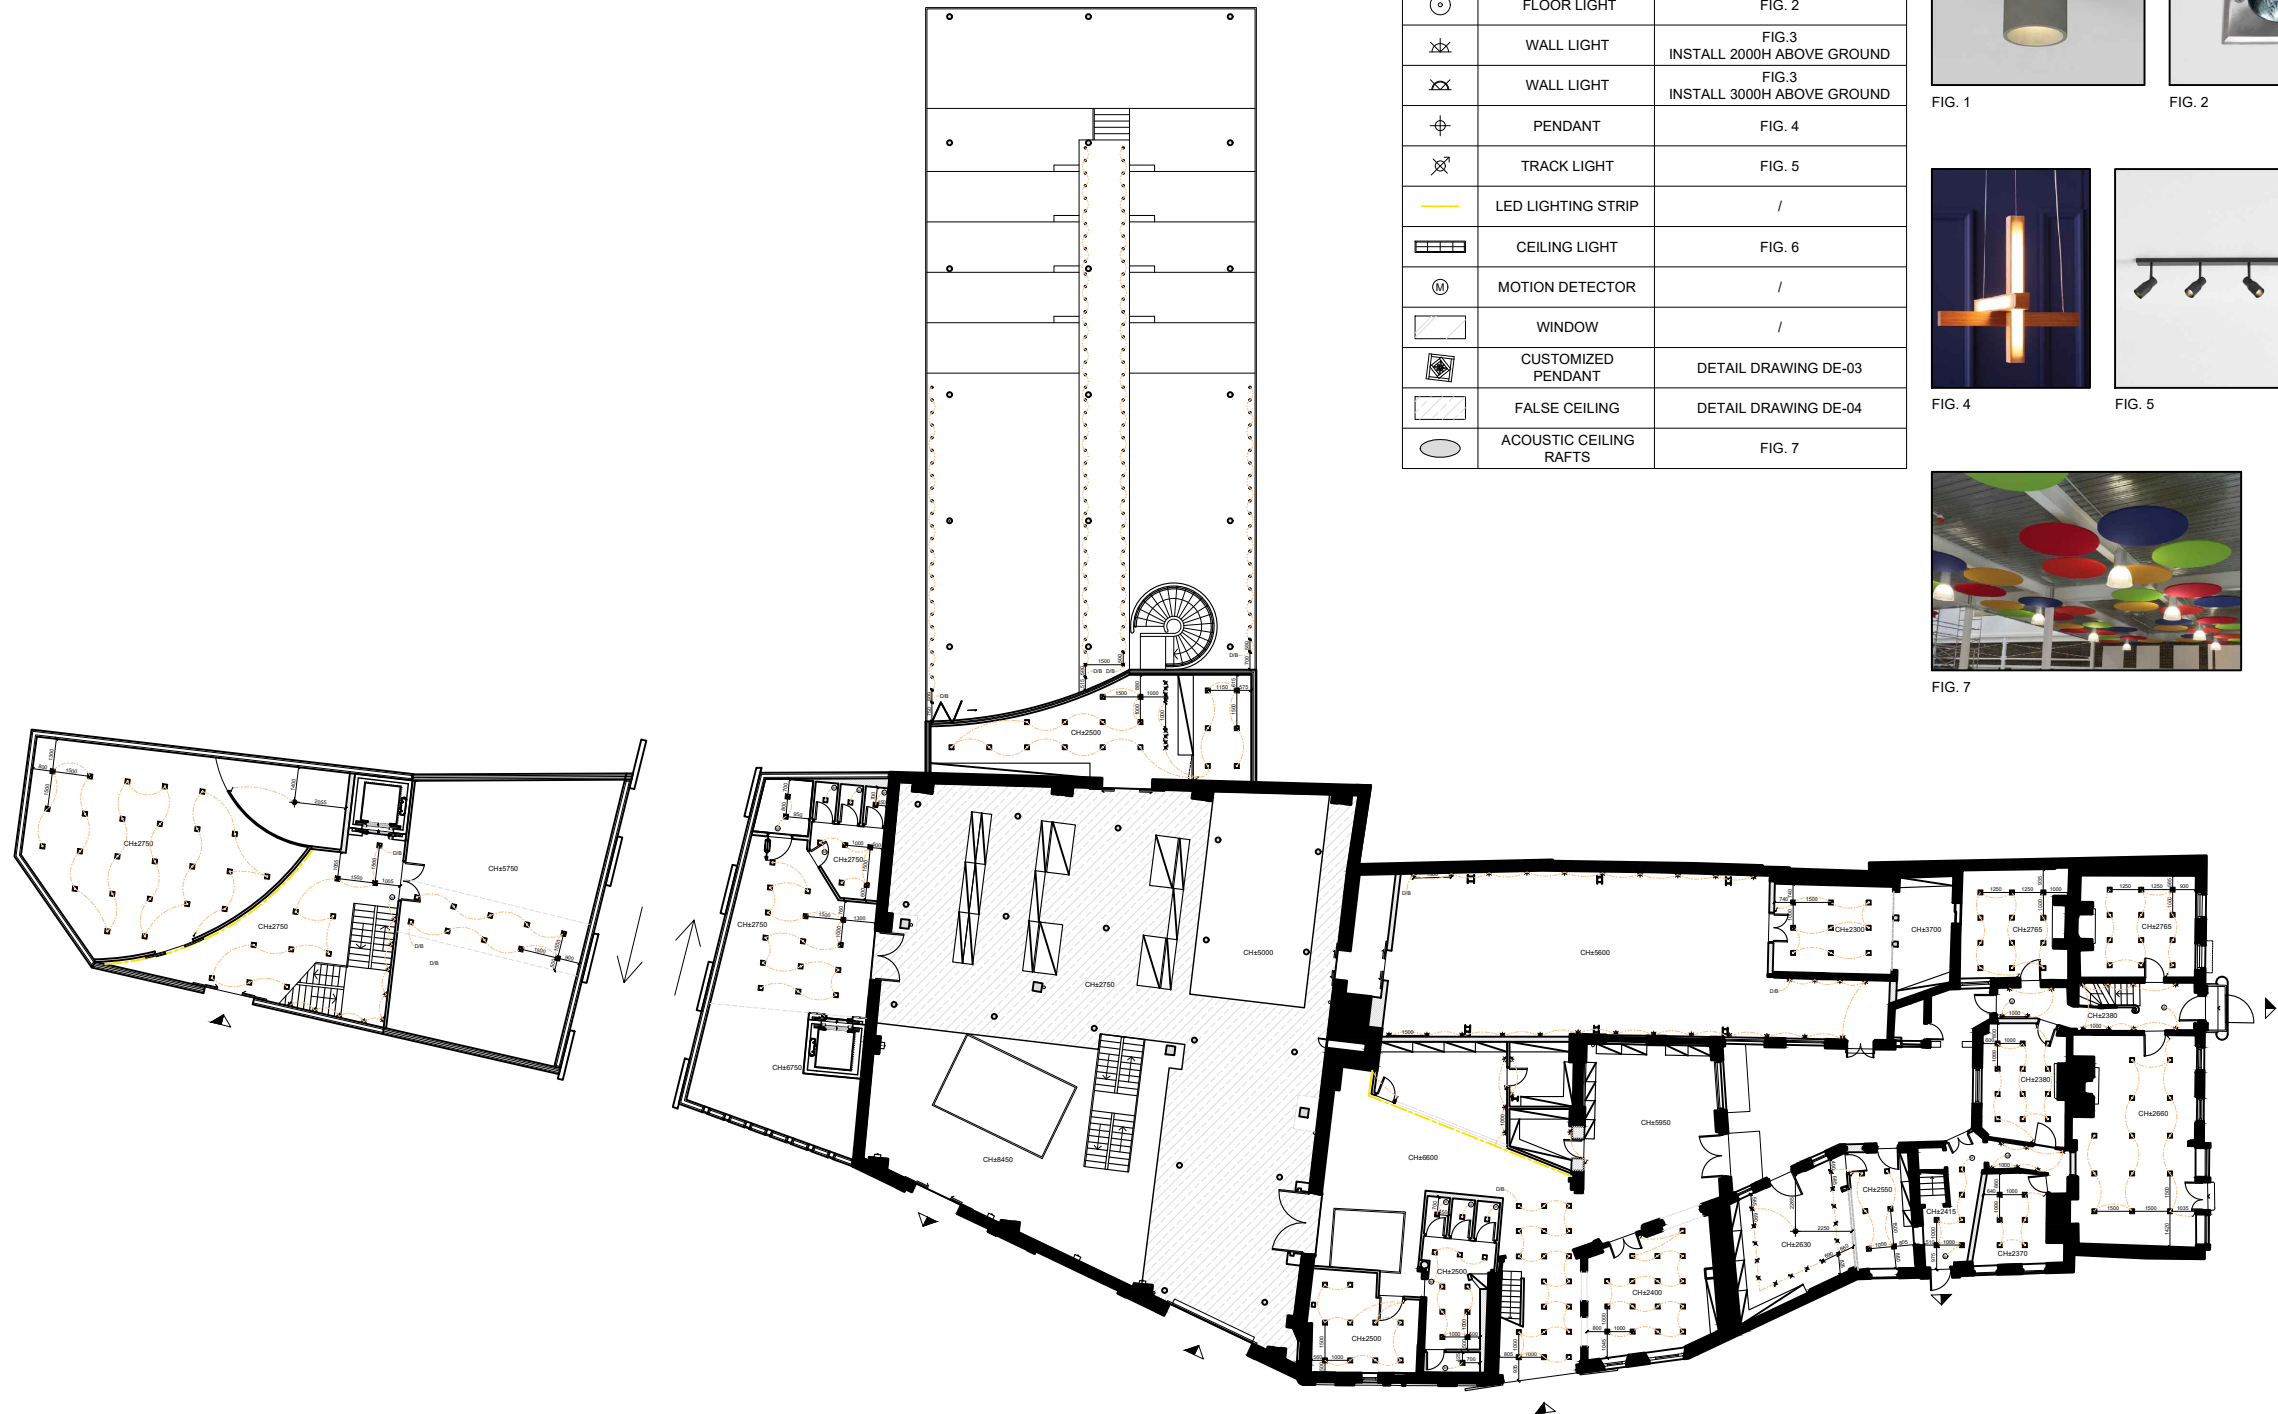

LIGHTING LEGEND

SYMBOL	DESCRIPTION	REMARKS
	DOWN LIGHT	FIG. 1
	FLOOR LIGHT	FIG. 2
	WALL LIGHT	FIG.3 INSTALL 2000H ABOVE GROUND
	WALL LIGHT	FIG.3 INSTALL 3000H ABOVE GROUND
	PENDANT	FIG. 4
	TRACK LIGHT	FIG. 5
	LED LIGHTING STRIP	/
	CEILING LIGHT	FIG. 6
	MOTION DETECTOR	/
	WINDOW	/
	CUSTOMIZED PENDANT	DETAIL DRAWING DE-03
	FALSE CEILING	DETAIL DRAWING DE-04
	ACOUSTIC CEILING RAFTS	FIG. 7



FIG. 1



FIG. 2



FIG. 3



FIG. 4

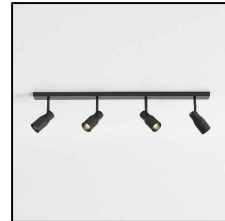


FIG. 5



FIG. 6



FIG. 7

GENERAL NOTES

- ALL DIMENSIONS ARE IN MILLIMETERS UNLESS OTHERWISE SPECIFIED.
- DO NOT SCALE THE DRAWINGS.
- ALL DIMENSIONS SHALL BE VERIFIED ON SITE WITH CONTRACTORS BEFORE PROCEEDING WORK.
- ALL DESIGNS ARE PROPERTY OF SO PAK LING. NO REPRODUCTION IS PERMITTED WITHOUT CONSENT.

SPECIFIC NOTES

- MATERIAL AND LOOSE FURNITURE ARE SUBJECT TO CHANGE UPON AVAILABILITY
- REFERENCE
- FIG. 1: Aelio Lighting (2021) Aelio Round [online] available from: <https://www.aeliolighting.com/products/80171-15-March-2021>
- FIG. 2: Aelio Lighting (2021) Aelio Square [online] available from: <https://www.aeliolighting.com/products/13120203-15-March-2021>
- FIG. 3: Aelio Lighting (2021) Aelio Wall & Ceiling [online] available from: <https://www.aeliolighting.com/products/13120203-15-March-2021>
- FIG. 4: Aelio Lighting (2021) Aelio Pendant [online] available from: <https://www.aeliolighting.com/products/13120203-15-March-2021>
- FIG. 5: Aelio Lighting (2021) Aelio Track [online] available from: <https://www.aeliolighting.com/products/13120203-15-March-2021>
- FIG. 6: Aelio Lighting (2021) Aelio Ceiling [online] available from: <https://www.aeliolighting.com/products/13120203-15-March-2021>
- FIG. 7: Aelio Lighting (2021) Aelio Acoustic [online] available from: <https://www.aeliolighting.com/products/13120203-15-March-2021>

REVISION

NO.	DATE	ISSUE
01	22 MAR 2021	PROPOSED DESIGN LAYOUT
02	19 APR 2021	UPDATED LEGEND

PROJECT TITLE

WHITECHAPEL HANDICRAFT LIBRARY

DRAWING TITLE

REFLECTIVE CEILING AND LIGHTING PLAN - G/F

PROJECT NO.

FMP-01

DRAWN BY

SO PAK LING

SCALE

1:300 (A3)

DATE

19 APR 2021

REVISION NO.


02

DRAWING NO.

CP-02

0 1 5 10m



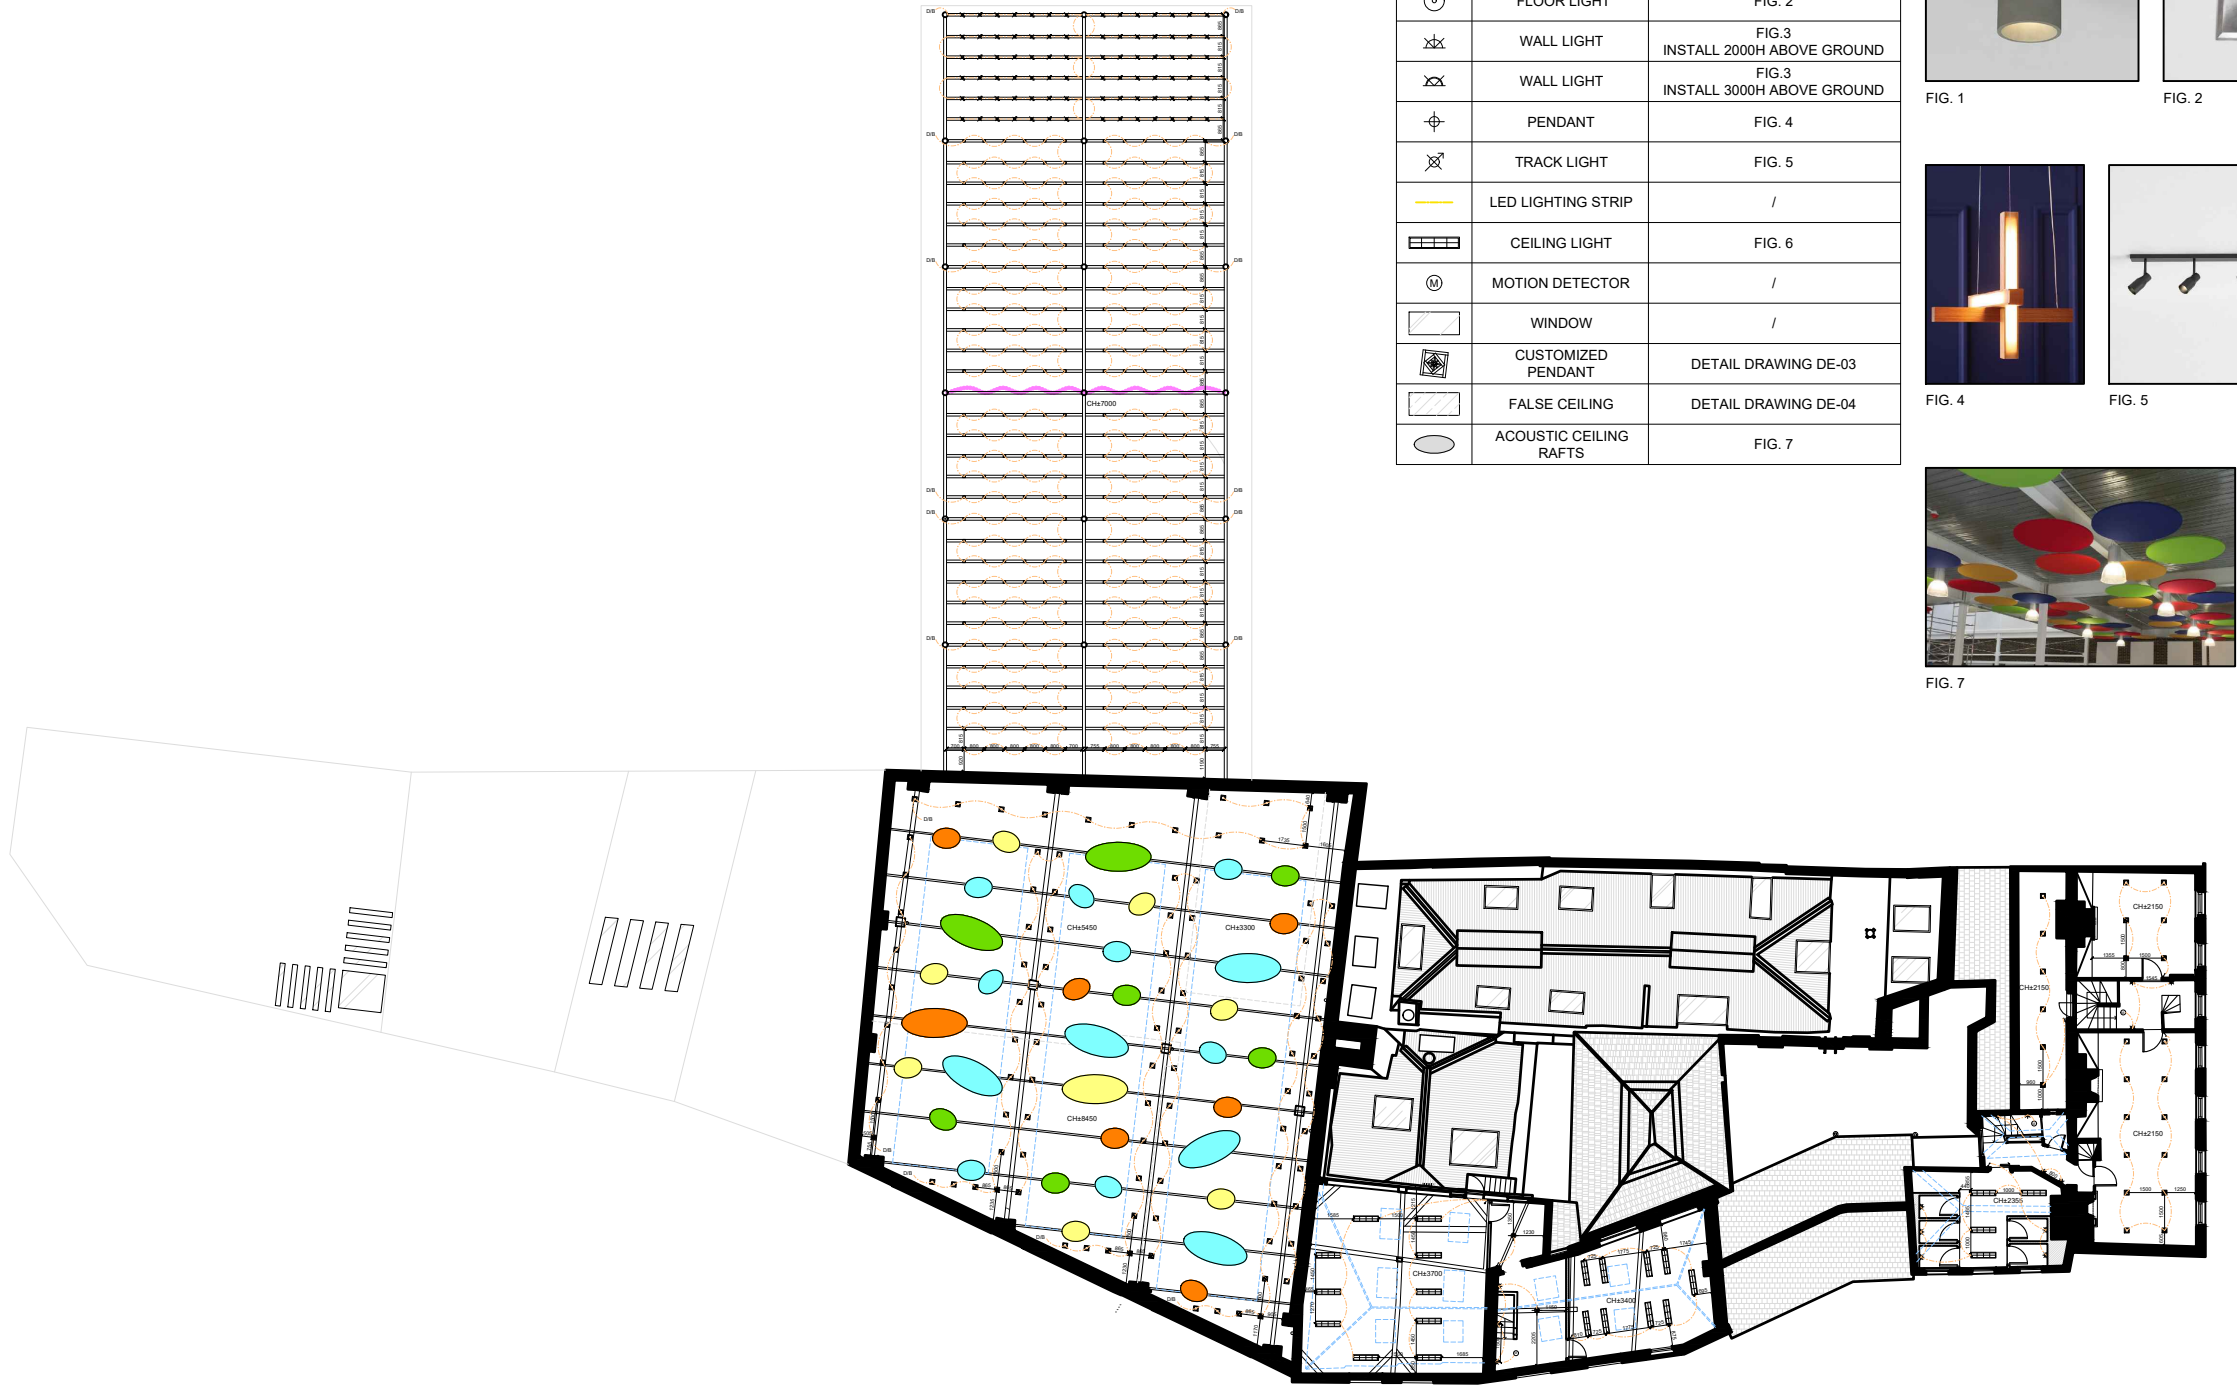

LIGHTING LEGEND

SYMBOL	DESCRIPTION	REMARKS
	DOWN LIGHT	FIG. 1
	FLOOR LIGHT	FIG. 2
	WALL LIGHT	FIG.3 INSTALL 2000H ABOVE GROUND
	WALL LIGHT	FIG.3 INSTALL 3000H ABOVE GROUND
	PENDANT	FIG. 4
	TRACK LIGHT	FIG. 5
	LED LIGHTING STRIP	/
	CEILING LIGHT	FIG. 6
	MOTION DETECTOR	/
	WINDOW	/
	CUSTOMIZED PENDANT	DETAIL DRAWING DE-03
	FALSE CEILING	DETAIL DRAWING DE-04
	ACOUSTIC CEILING RAFTS	FIG. 7



FIG. 1



FIG. 2



FIG. 3



FIG. 4



FIG. 5



FIG. 6



FIG. 7

KS
Design

GENERAL NOTES

1. ALL DIMENSIONS ARE IN MILLIMETERS UNLESS OTHERWISE SPECIFIED.
2. DO NOT SCALE THE DRAWINGS.
3. ALL DIMENSIONS SHALL BE VERIFIED ON SITE WITH CONTRACTORS BEFORE PROCEEDING WORK.
4. ALL DESIGNS ARE PROPERTY OF SO PAK LING. NO REPRODUCTION IS PERMITTED WITHOUT CONSENT.

SPECIFIC NOTES

1. MATERIAL AND LOOSE FURNITURE ARE SUBJECT TO CHANGE UPON AVAILABILITY
- REFERENCE
- FIG. 1 Aelio Lighting (2021) Aelio Round [online] available from: <https://www.aeliolighting.com/products/8017/> [1 March 2021]
- FIG. 2 Aelio Lighting (2021) Aelio Square [online] available from: <https://www.aeliolighting.com/products/1312020/> [1 March 2021]
- FIG. 3 Aelio Lighting (2021) Aelio Wall & Ceiling [online] available from: <https://www.aeliolighting.com/products/1312020/> [1 March 2021]
- FIG. 4 Aelio Lighting (2021) Aelio Pendant [online] available from: <https://www.aeliolighting.com/products/1312020/> [1 March 2021]
- FIG. 5 Aelio Lighting (2021) Aelio Track [online] available from: <https://www.aeliolighting.com/products/1312020/> [1 March 2021]
- FIG. 6 Aelio Lighting (2021) Aelio Ceiling [online] available from: <https://www.aeliolighting.com/products/1312020/> [1 March 2021]
- FIG. 7 Aelio Lighting (2021) Aelio Acoustic Ceiling Rafts [online] available from: <https://www.aeliolighting.com/products/1312020/> [1 March 2021]

REVISION

NO.	DATE	ISSUE
01	22 MAR 2021	PROPOSED DESIGN LAYOUT
02	19 APR 2021	UPDATED LEGEND AND LAYOUT AS PER ADVICE

PROJECT TITLE

WHITECHAPEL HANDICRAFT LIBRARY

DRAWING TITLE

REFLECTIVE CEILING AND LIGHTING PLAN - 2/F

PROJECT NO.

FMP-01

DATE

19 APR 2021

DRAWN BY

SO PAK LING

REVISION NO.

02

SCALE


1:300 (A3)

DRAWING NO.

CP-04

0 1 5 10m



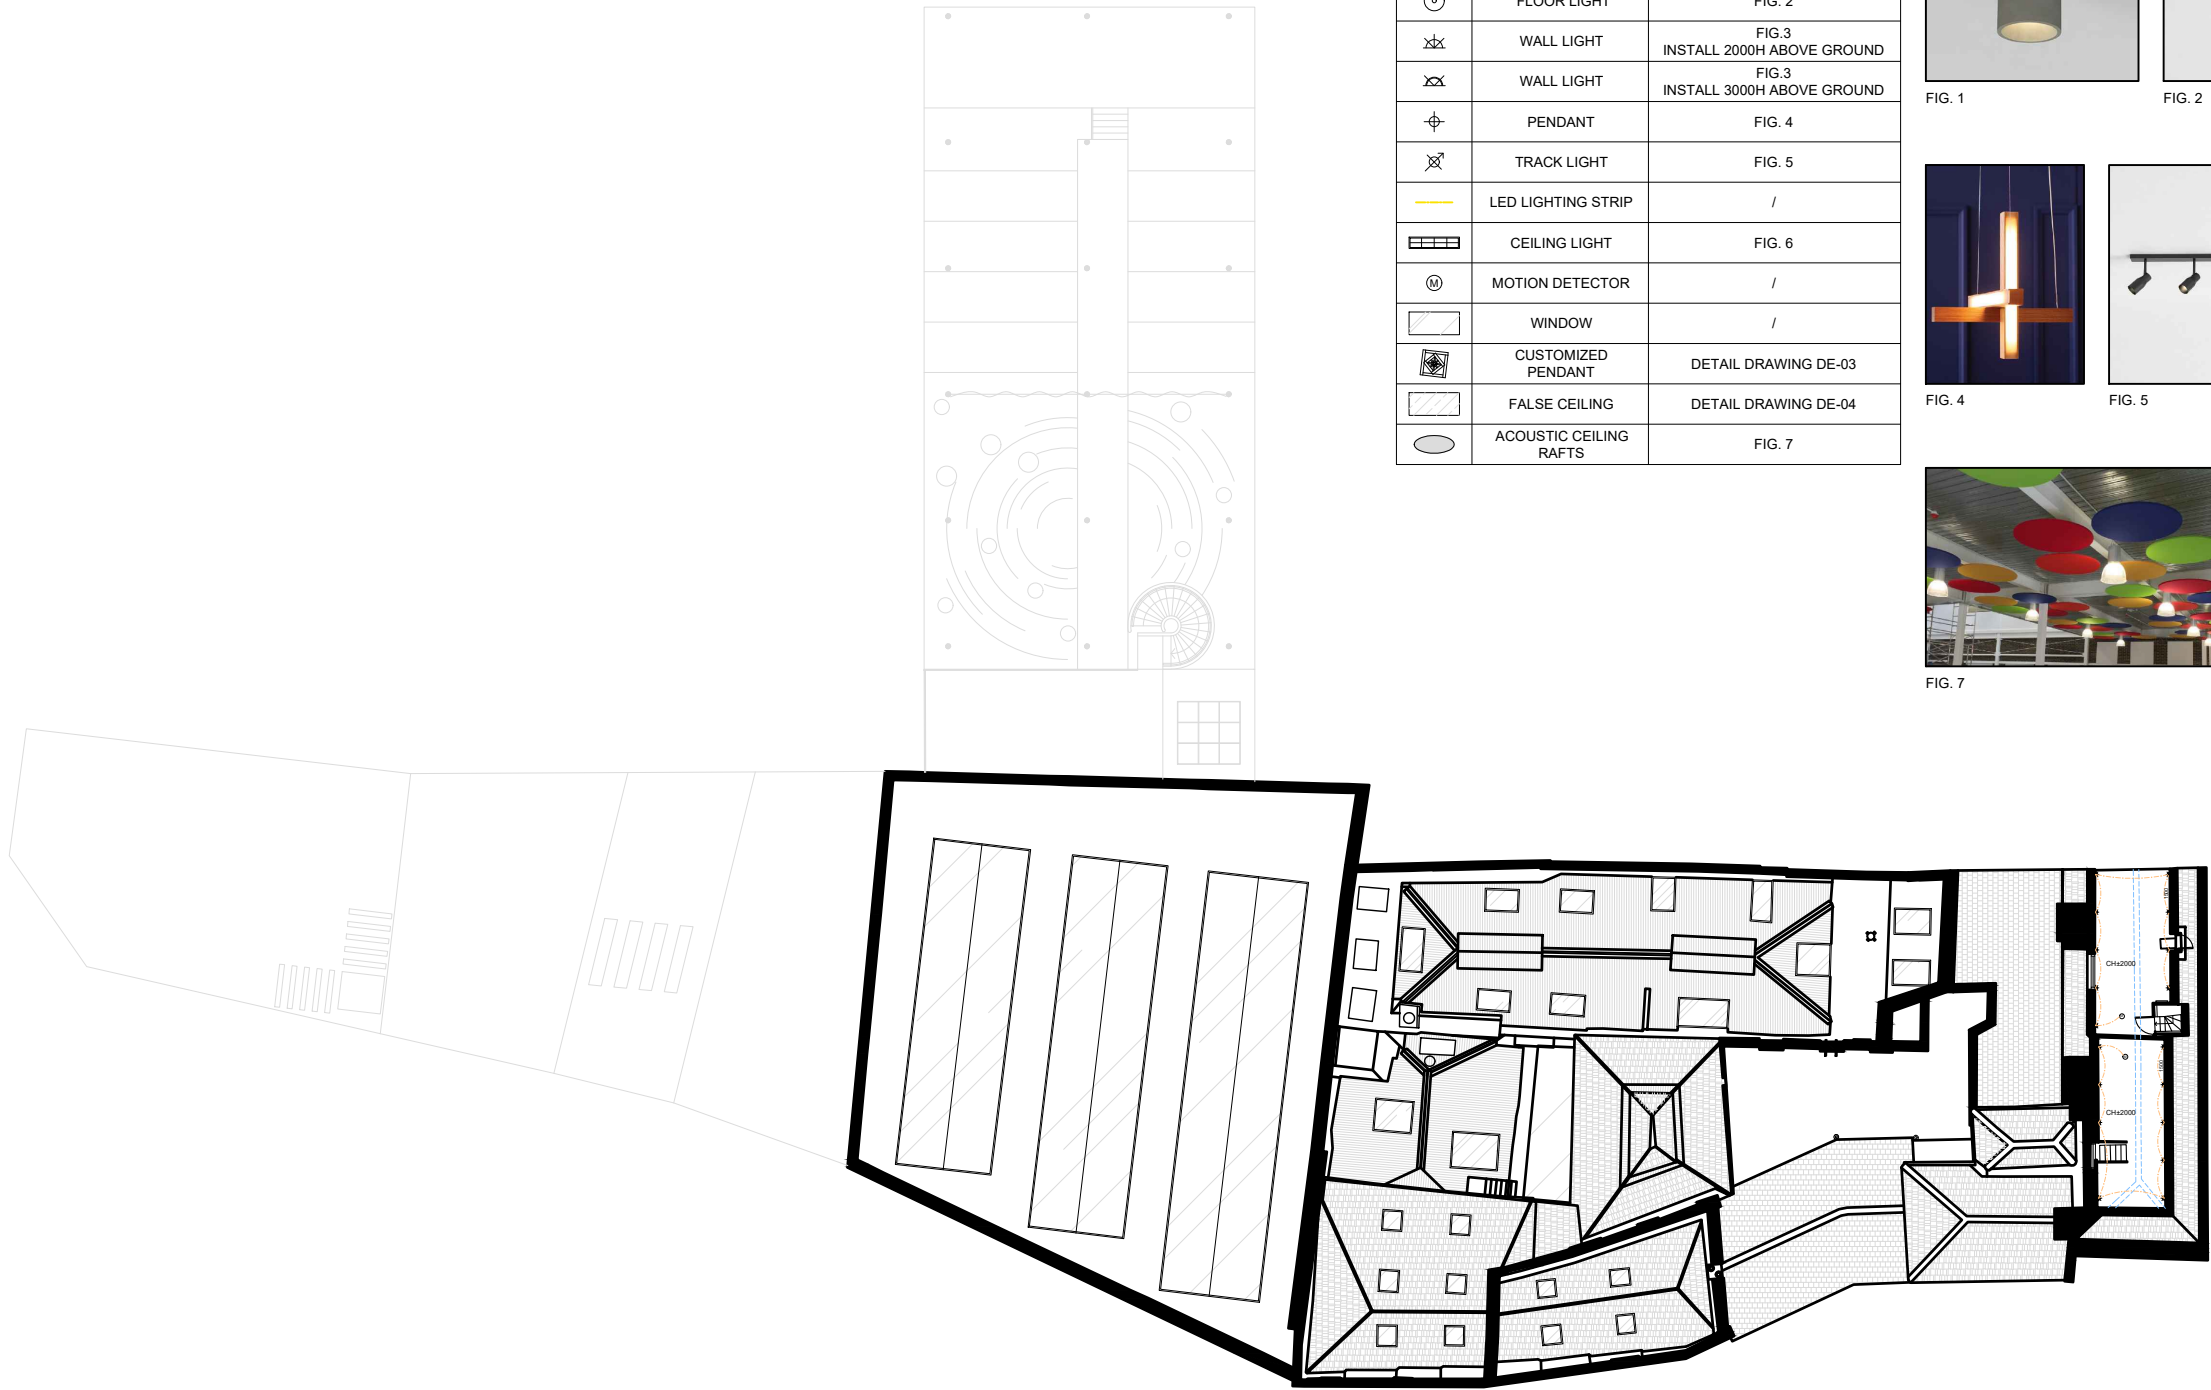

LIGHTING LEGEND

SYMBOL	DESCRIPTION	REMARKS
	DOWN LIGHT	FIG. 1
	FLOOR LIGHT	FIG. 2
	WALL LIGHT	FIG.3 INSTALL 2000H ABOVE GROUND
	WALL LIGHT	FIG.3 INSTALL 3000H ABOVE GROUND
	PENDANT	FIG. 4
	TRACK LIGHT	FIG. 5
	LED LIGHTING STRIP	/
	CEILING LIGHT	FIG. 6
	MOTION DETECTOR	/
	WINDOW	/
	CUSTOMIZED PENDANT	DETAIL DRAWING DE-03
	FALSE CEILING	DETAIL DRAWING DE-04
	ACOUSTIC CEILING RAFTS	FIG. 7



FIG. 1



FIG. 2



FIG. 3



FIG. 4



FIG. 5



FIG. 6



FIG. 7

GENERAL NOTES

1. ALL DIMENSIONS ARE IN MILLIMETERS UNLESS OTHERWISE SPECIFIED.
2. DO NOT SCALE THE DRAWINGS.
3. ALL DIMENSIONS SHALL BE VERIFIED ON SITE WITH CONTRACTORS BEFORE PROCEEDING WORK.
4. ALL DESIGNS ARE PROPERTY OF SO PAK LING. NO REPRODUCTION IS PERMITTED WITHOUT CONSENT.

SPECIFIC NOTES

1. MATERIAL AND LOOSE FURNITURE ARE SUBJECT TO CHANGE UPON AVAILABILITY

REFERENCE	DESCRIPTION
FIG. 1: Aelio Lighting (2021) Aelio Round [online] available from: https://www.aeliolighting.com/products/80171-11-March-2021/	
FIG. 2: Aelio Lighting (2021) Aelio Square [online] available from: https://www.aeliolighting.com/products/13120203-11-March-2021/	
FIG. 3: Aelio Lighting (2021) Aelio Wall & Ceiling [online] available from: https://www.aeliolighting.com/products/13120203-11-March-2021/	
FIG. 4: Aelio Lighting (2021) Aelio Pendant [online] available from: https://www.aeliolighting.com/products/13120203-11-March-2021/	
FIG. 5: Aelio Lighting (2021) Aelio Track [online] available from: https://www.aeliolighting.com/products/13120203-11-March-2021/	
FIG. 6: Aelio Lighting (2021) Aelio Ceiling [online] available from: https://www.aeliolighting.com/products/13120203-11-March-2021/	
FIG. 7: Aelio Lighting (2021) Aelio Acoustic [online] available from: https://www.aeliolighting.com/products/13120203-11-March-2021/	

REVISION

NO.	DATE	ISSUE
01	22 MAR 2021	PROPOSED DESIGN LAYOUT
02	19 APR 2021	UPDATED LEGEND

PROJECT TITLE

WHITECHAPEL HANDICRAFT LIBRARY

DRAWING TITLE

REFLECTIVE CEILING AND LIGHTING PLAN - 3/F

PROJECT NO.

FMP-01

DRAWN BY

SO PAK LING

SCALE

1:300 (A3)

DATE

19 APR 2021

REVISION NO.


02

DRAWING NO.

CP-05

0 1 5 10m



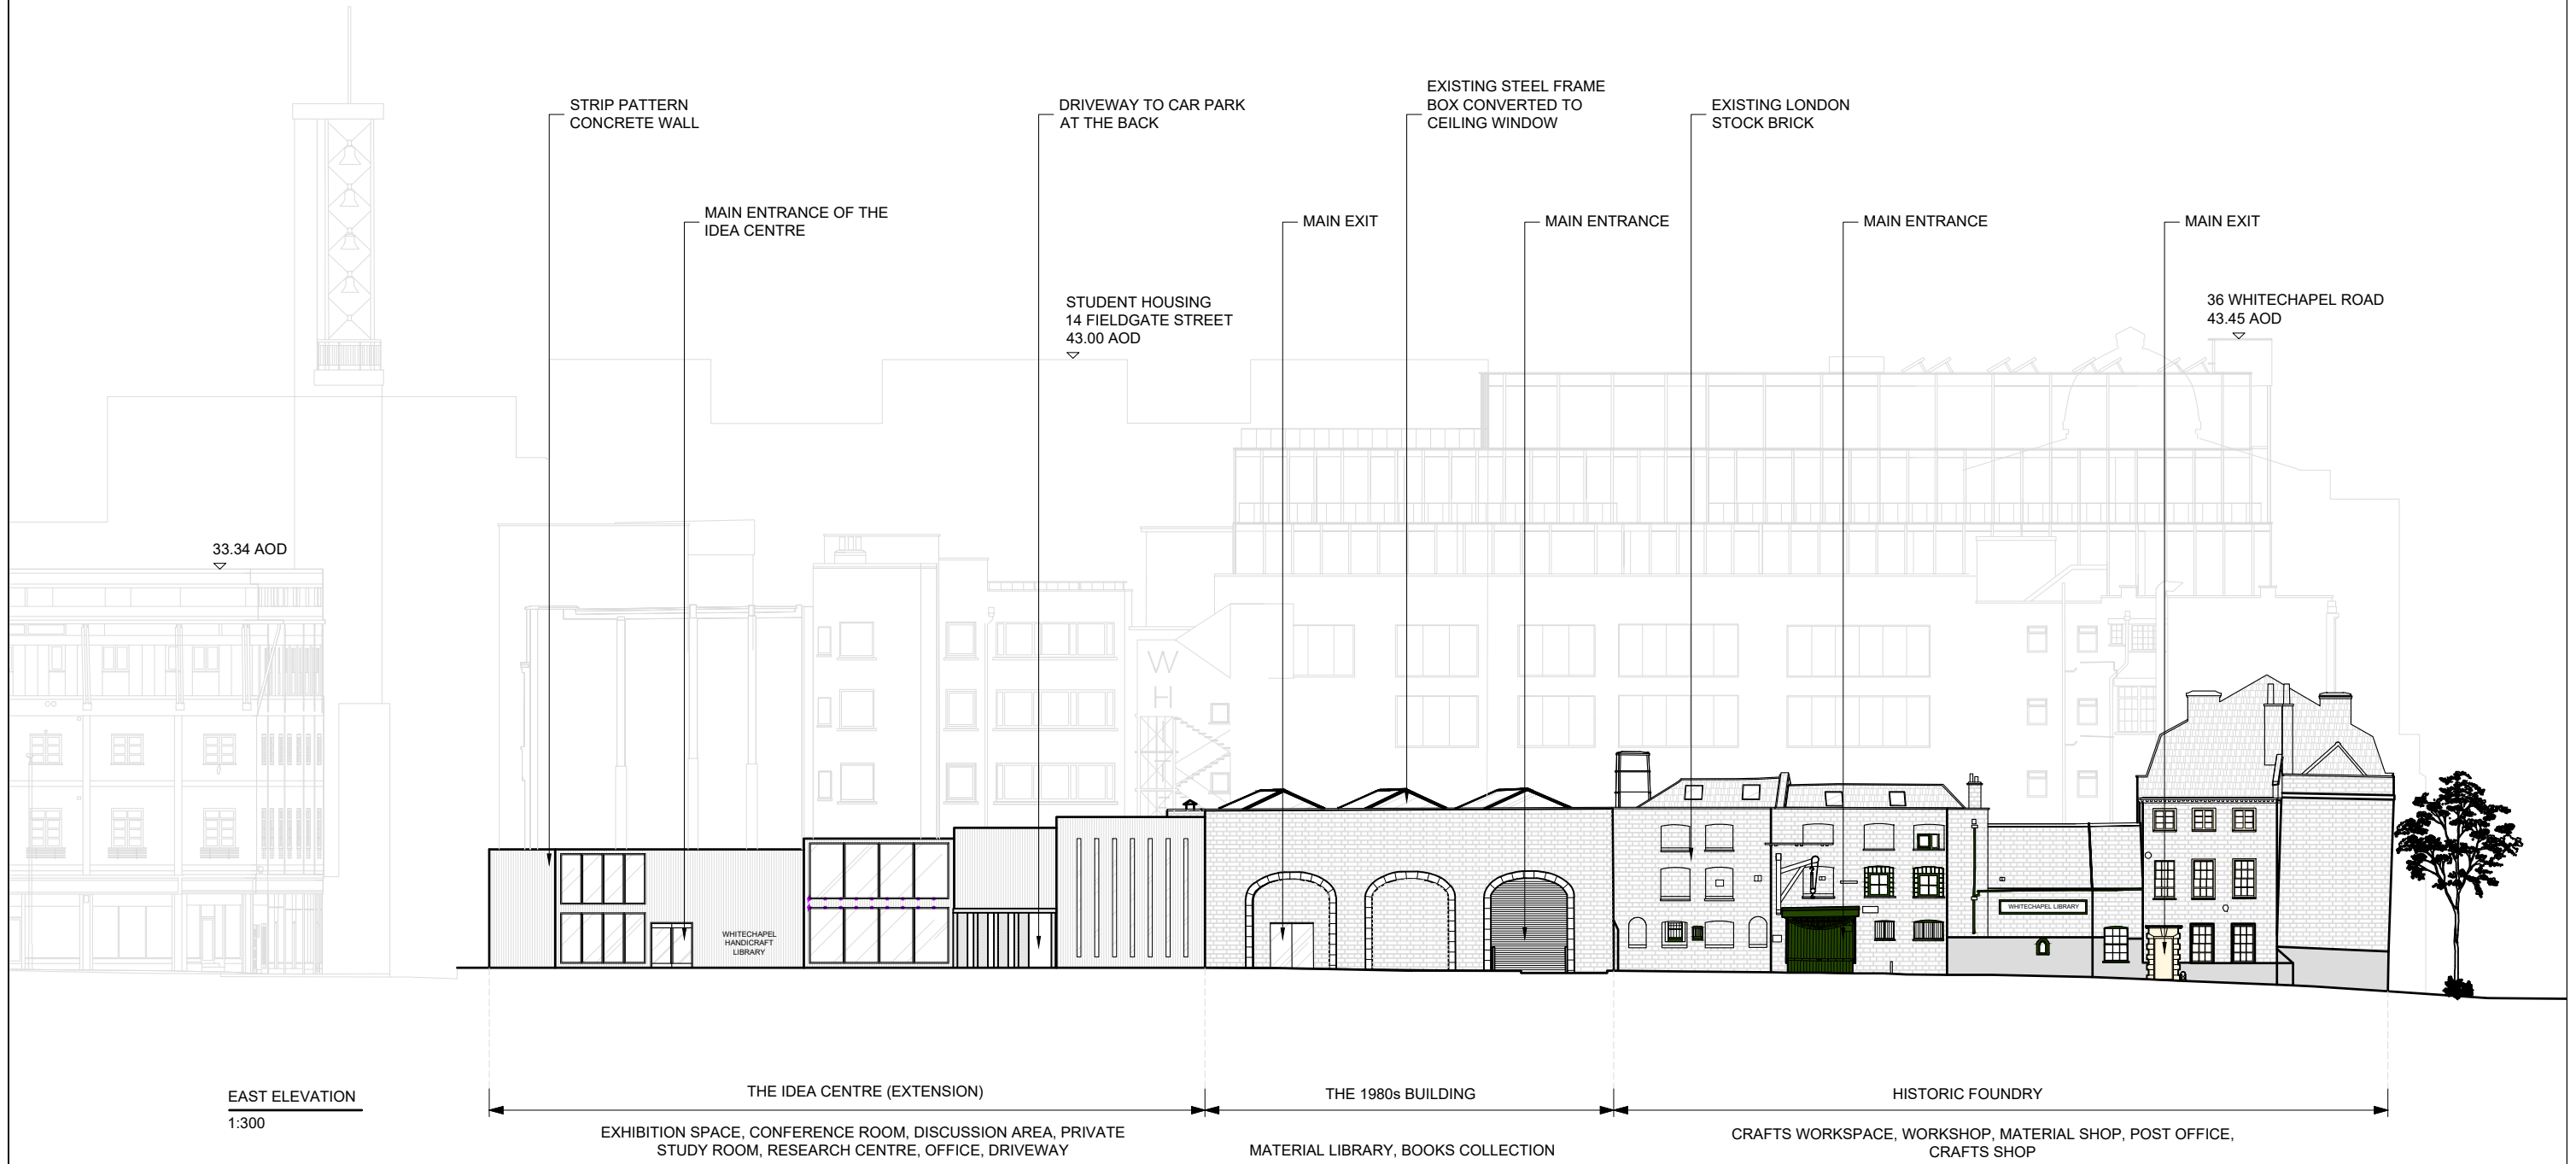

KS
Design

GENERAL NOTES

1. ALL DIMENSIONS ARE IN MILLIMETERS UNLESS OTHERWISE SPECIFIED.
2. DO NOT SCALE THE DRAWINGS.
3. ALL DIMENSIONS SHALL BE VERIFIED ON SITE WITH CONTRACTORS BEFORE PROCEEDING WORK.
4. ALL DESIGNS ARE PROPERTY OF SO PAK LING. NO REPRODUCTION IS PERMITTED WITHOUT CONSENT.

SPECIFIC NOTES

REVISION

NO.	DATE	ISSUE
01	30 NOV 2020	PROPOSED DESIGN LAYOUT
02	10 FEB 2021	UPDATED LAYOUT AS PER ADVICES
03	03 MAR 2021	REVISED LAYOUT
04	29 MAR 2021	REVISED LAYOUT

PROJECT TITLE

WHITECHAPEL HANDICRAFT LIBRARY

DRAWING TITLE

EAST ELEVATION

PROJECT NO.

FMP-01

DRAWN BY

SO PAK LING

SCALE

1:300 (A3)

DATE


29 MAR 2021


REVISION NO.

04

DRAWING NO.

EL-01

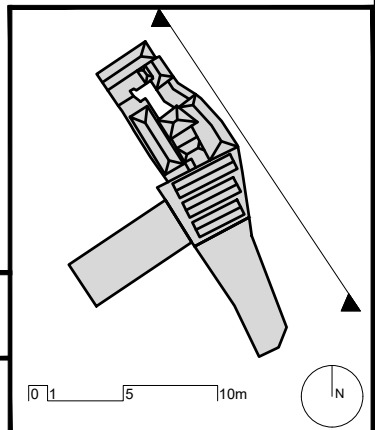

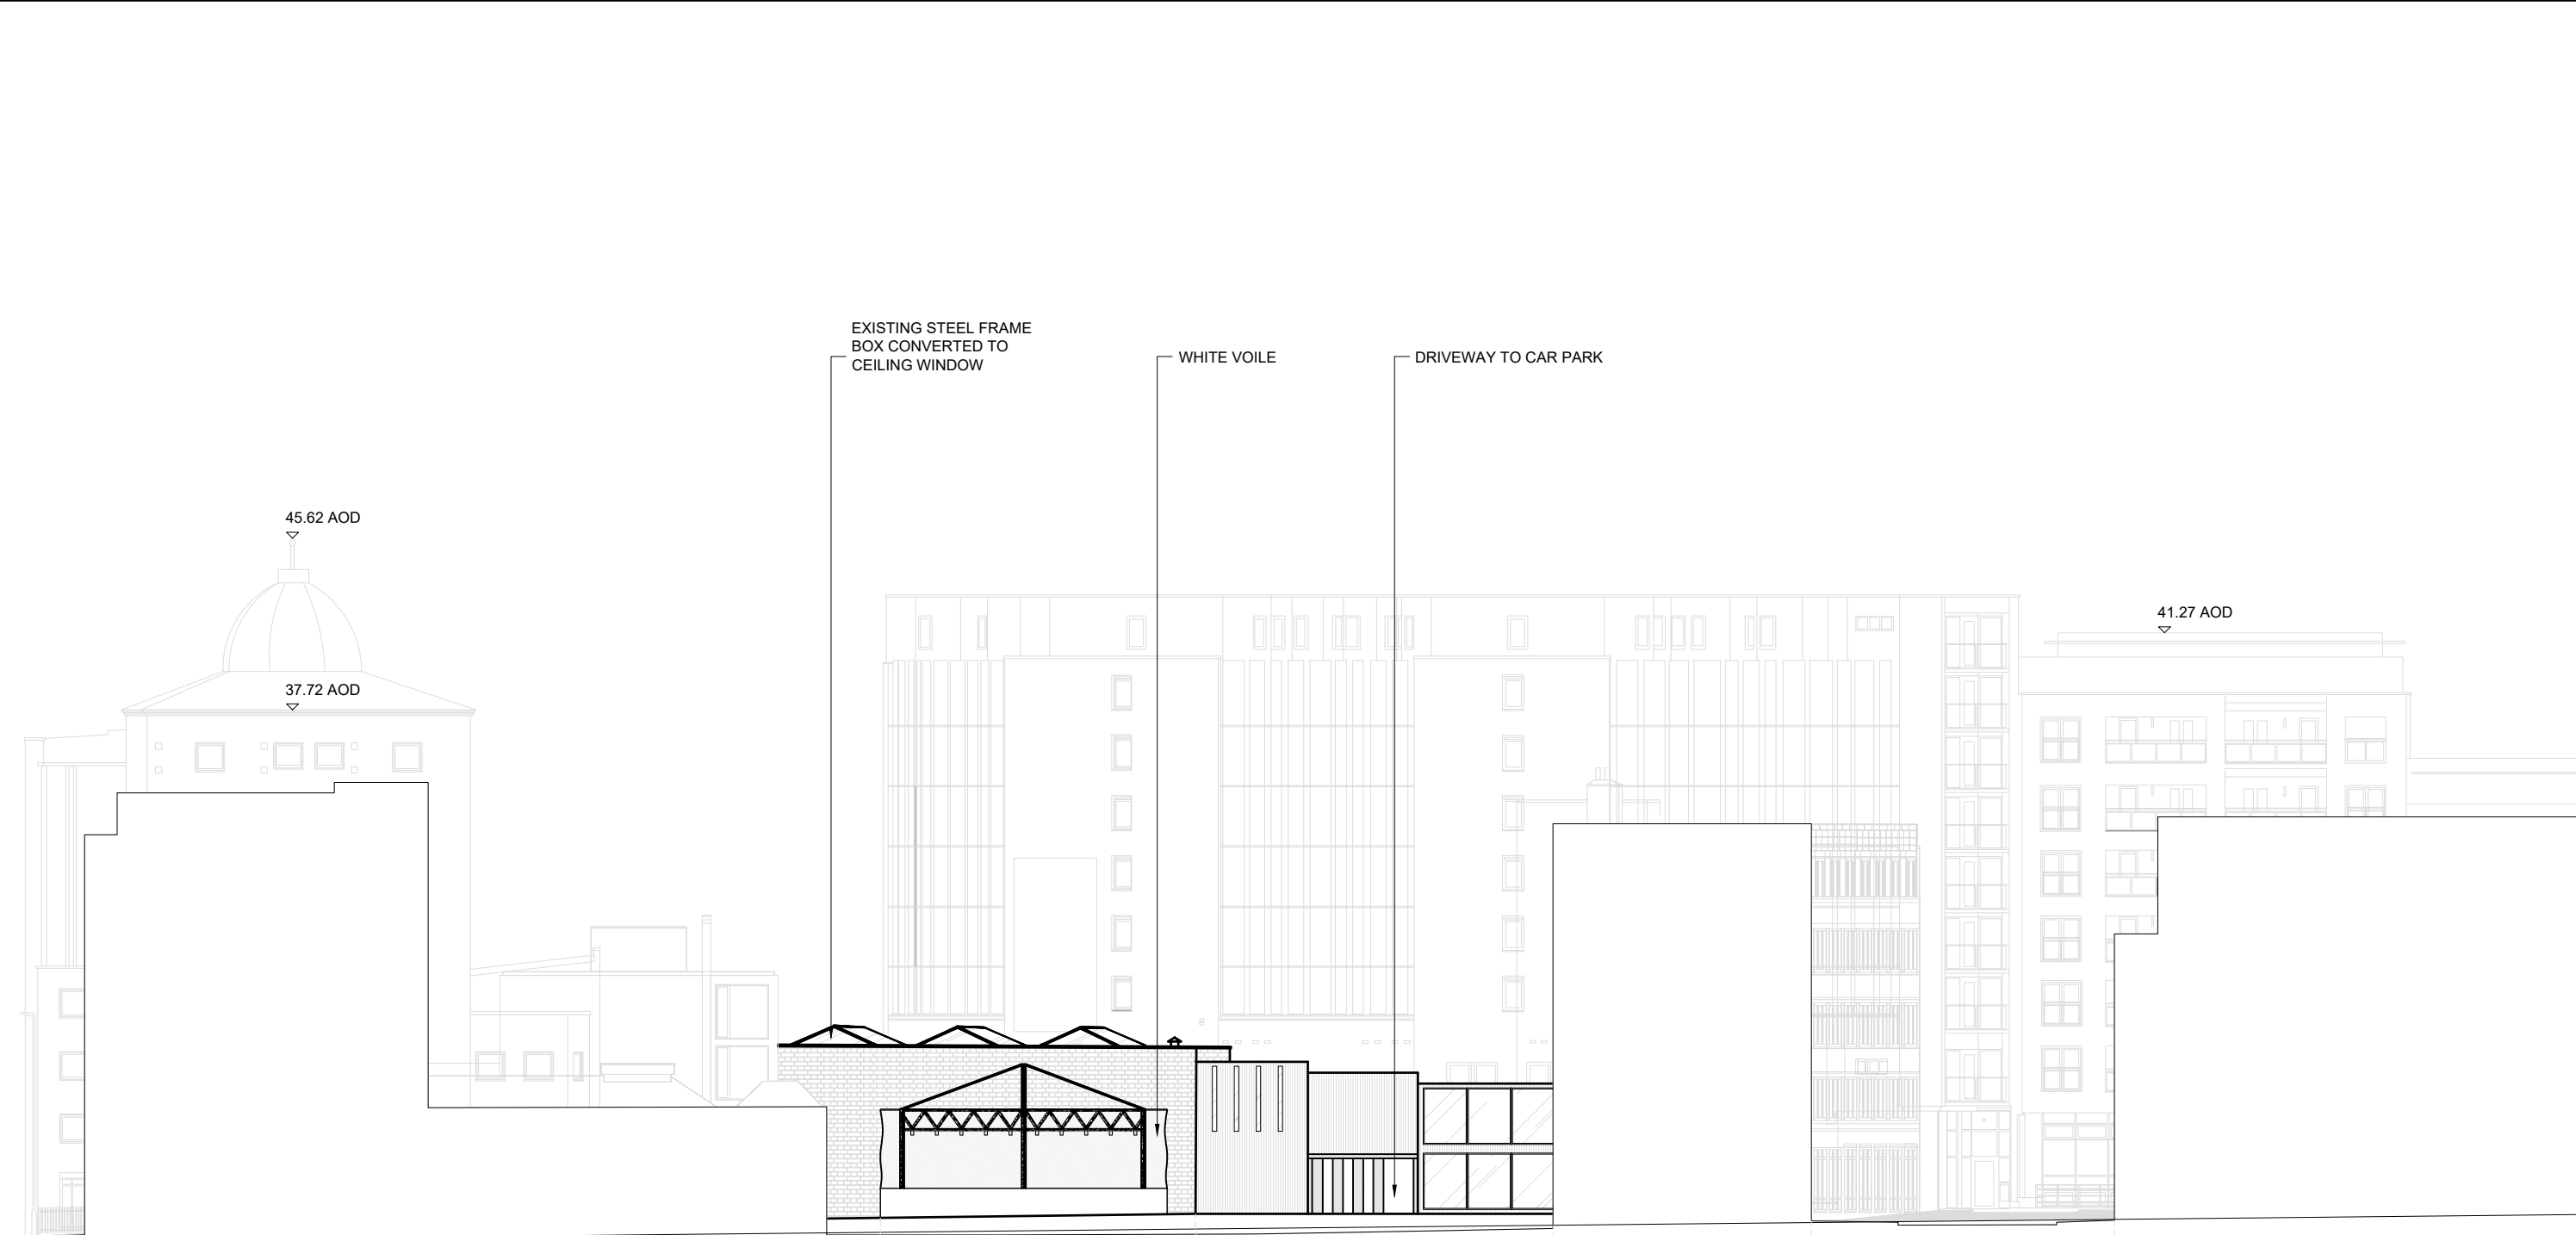

WEST ELEVATION
1:300

THE 1980s BUILDING
OUTDOOR EVENT SPACE

THE IDEA CENTRE (EXTENSION)
EXHIBITION SPACE, CONFERENCE ROOM,
DISCUSSION AREA, PRIVATE STUDY ROOM,
RESEARCH CENTRE, OFFICE, DRIVEWAY

QBIC HOTELS LONDON CITY

MULBERRY STREET

KS
Design

GENERAL NOTES

1. ALL DIMENSIONS ARE IN MILLIMETERS UNLESS OTHERWISE SPECIFIED.
2. DO NOT SCALE THE DRAWINGS.
3. ALL DIMENSIONS SHALL BE VERIFIED ON SITE WITH CONTRACTORS BEFORE PROCEEDING WORK.
4. ALL DESIGNS ARE PROPERTY OF SO PAK LING. NO REPRODUCTION IS PERMITTED WITHOUT CONSENT.

SPECIFIC NOTES

REVISION		
NO.	DATE	ISSUE
01	30 NOV 2020	PROPOSED DESIGN LAYOUT
02	10 FEB 2021	UPDATED LAYOUT AS PER ADVICES
03	03 MAR 2021	REVISED LAYOUT
04	29 MAR 2021	REVISED LAYOUT
05	19 APR 2021	REVISED LAYOUT

PROJECT TITLE
WHITECHAPEL HANDICRAFT LIBRARY

DRAWING TITLE
WEST ELEVATION

PROJECT NO.
FMP-01


DATE
19 APR 2021


DRAWN BY
SO PAK LING

REVISION NO.
05


SCALE
1:300 (A3)

DRAWING NO.
EL-02

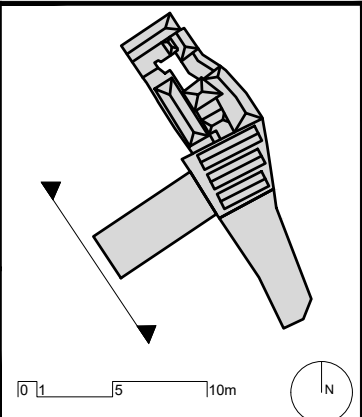

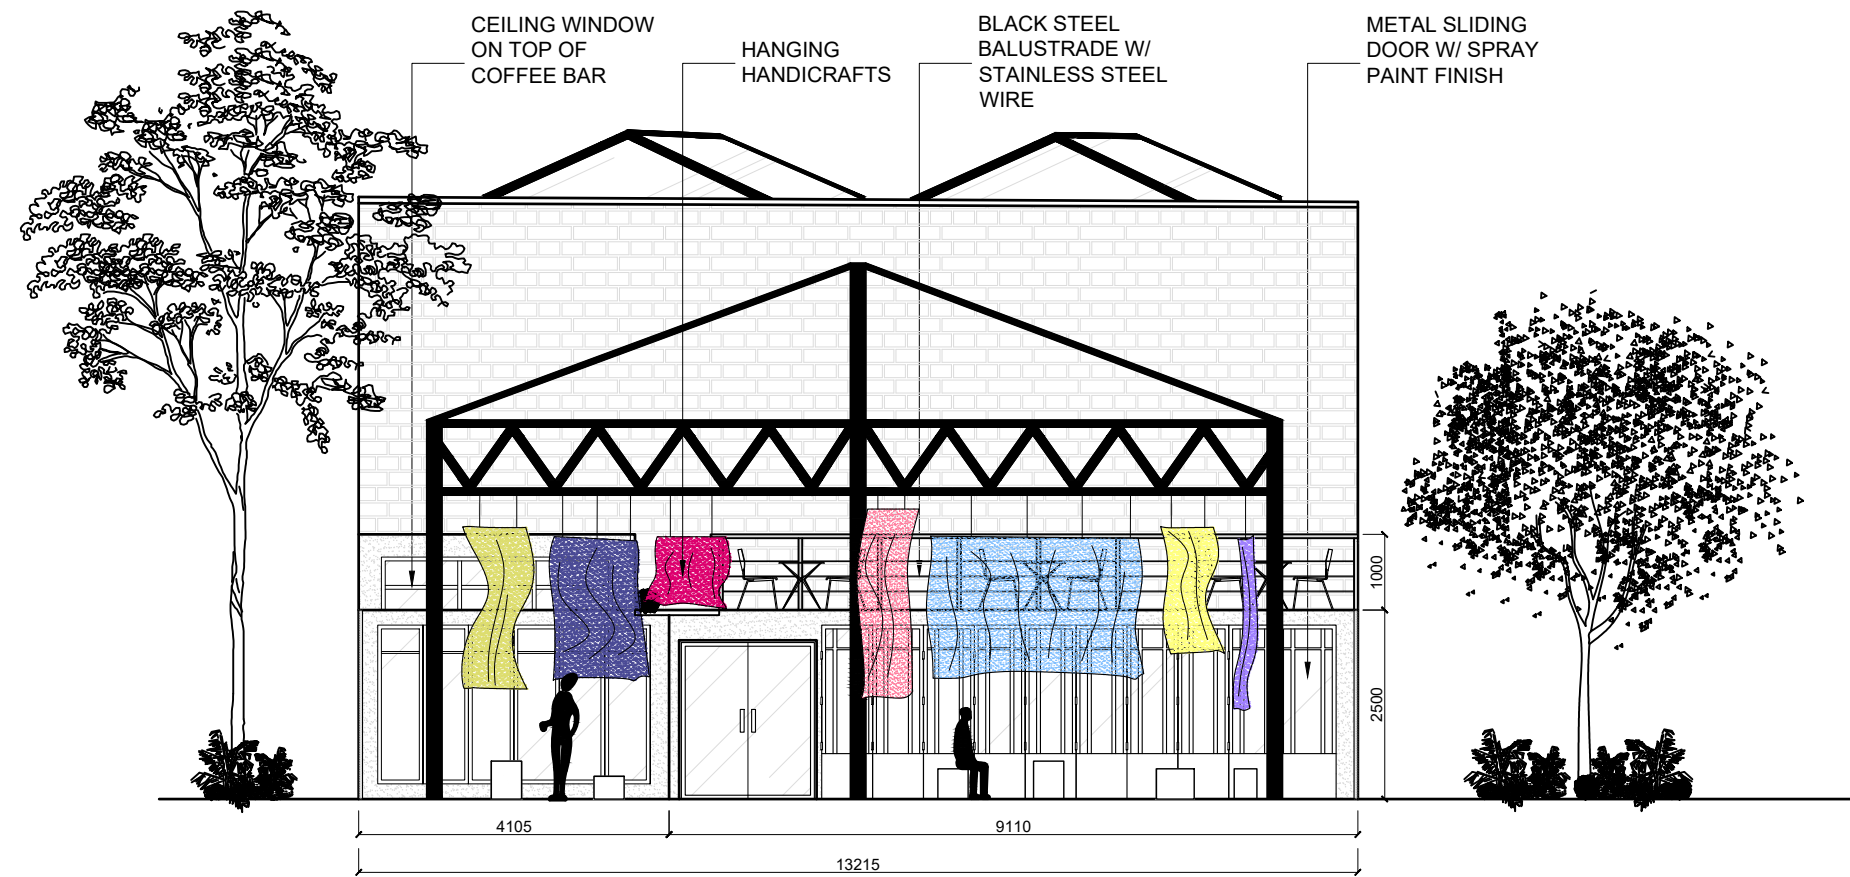

INTERNAL ELEVATION A1 - CAFE
1:100

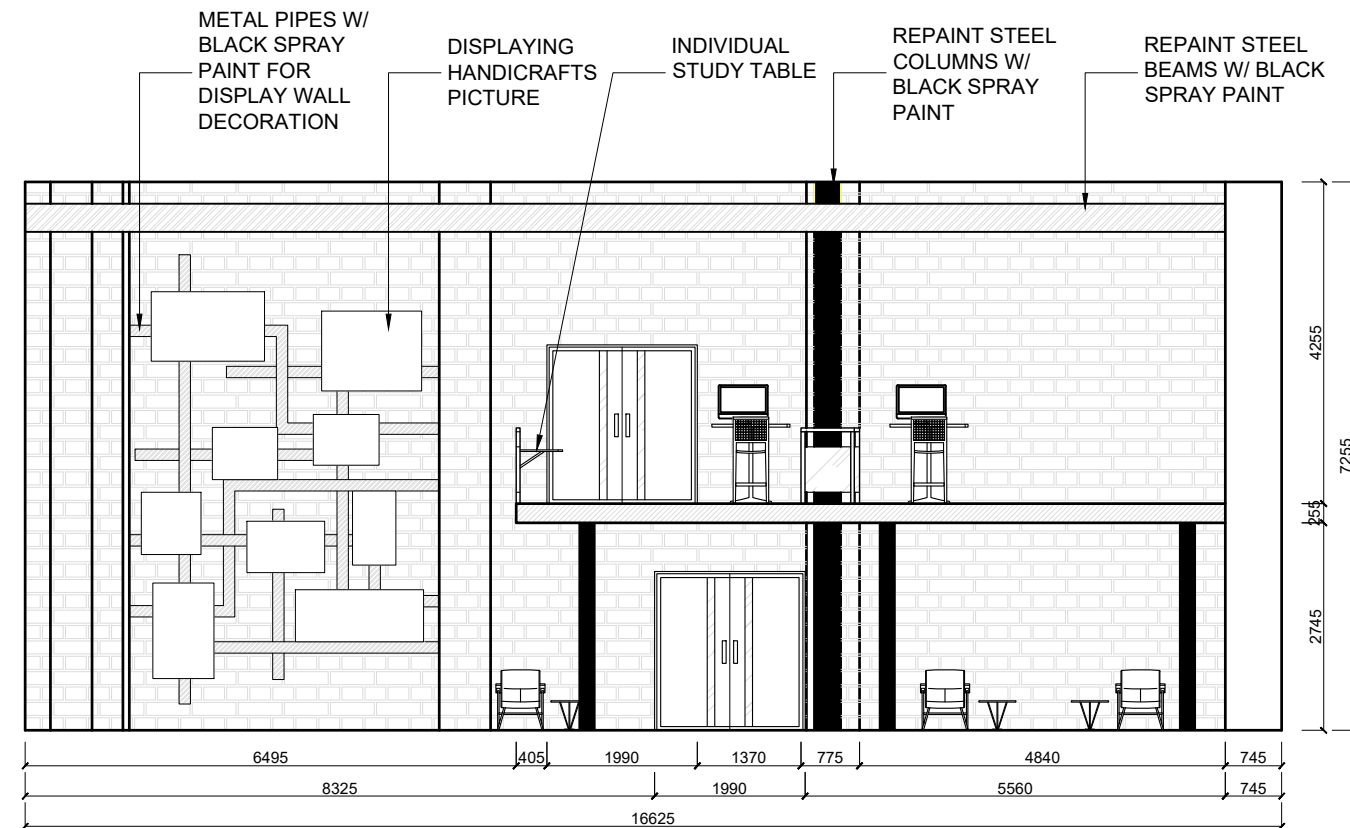

INTERNAL ELEVATION B2- READING AND STUDYING AREA
1:100

KS
Design

GENERAL NOTES

1. ALL DIMENSIONS ARE IN MILLIMETERS UNLESS OTHERWISE SPECIFIED.
2. DO NOT SCALE THE DRAWINGS.
3. ALL DIMENSIONS SHALL BE VERIFIED ON SITE WITH CONTRACTORS BEFORE PROCEEDING WORK.
4. ALL DESIGNS ARE PROPERTY OF SO PAK LING. NO REPRODUCTION IS PERMITTED WITHOUT CONSENT.

SPECIFIC NOTES

REVISION

NO.	DATE	ISSUE
01	30 NOV 2020	PROPOSED DESIGN LAYOUT
02	10 FEB 2021	UPDATED LAYOUT AS PER ADVICES
03	03 MAR 2021	REVISED LAYOUT
04	29 MAR 2021	REVISED LAYOUT
05	19 APR 2021	REVISED LAYOUT

PROJECT TITLE

WHITECHAPEL HANDICRAFT LIBRARY

DRAWING TITLE

INTERNAL ELEVATION

PROJECT NO.

FMP-01

DATE

19 APR 2021

DRAWN BY

SO PAK LING

REVISION NO.


05

SCALE

1:100 (A3)

DRAWING NO.

EL-03

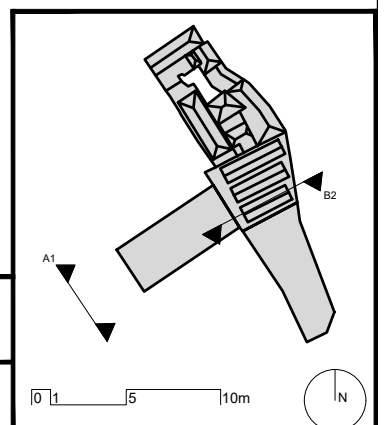



KS
Design

GENERAL NOTES

1. ALL DIMENSIONS ARE IN MILLIMETERS UNLESS OTHERWISE SPECIFIED.
2. DO NOT SCALE THE DRAWINGS.
3. ALL DIMENSIONS SHALL BE VERIFIED ON SITE WITH CONTRACTORS BEFORE PROCEEDING WORK.
4. ALL DESIGNS ARE PROPERTY OF SO PAK LING. NO REPRODUCTION IS PERMITTED WITHOUT CONSENT.

SPECIFIC NOTES

REVISION		
NO.	DATE	ISSUE
01	30 NOV 2020	PROPOSED DESIGN LAYOUT
02	10 FEB 2021	UPDATED LAYOUT AS PER ADVICES
03	03 MAR 2021	REVISED LAYOUT
04	29 MAR 2021	REVISED LAYOUT
05	19 APR 2021	REVISED LAYOUT

PROJECT TITLE
WHITECHAPEL HANDICRAFT LIBRARY

DRAWING TITLE
SECTION AA

PROJECT NO.
FMP-01


DATE
19 APR 2021


DRAWN BY
SO PAK LING

REVISION NO.
05

SCALE
1:300 (A3)

DRAWING NO.
SC-01

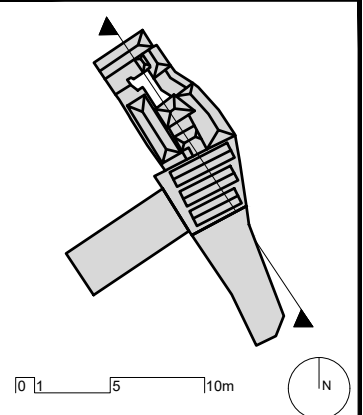

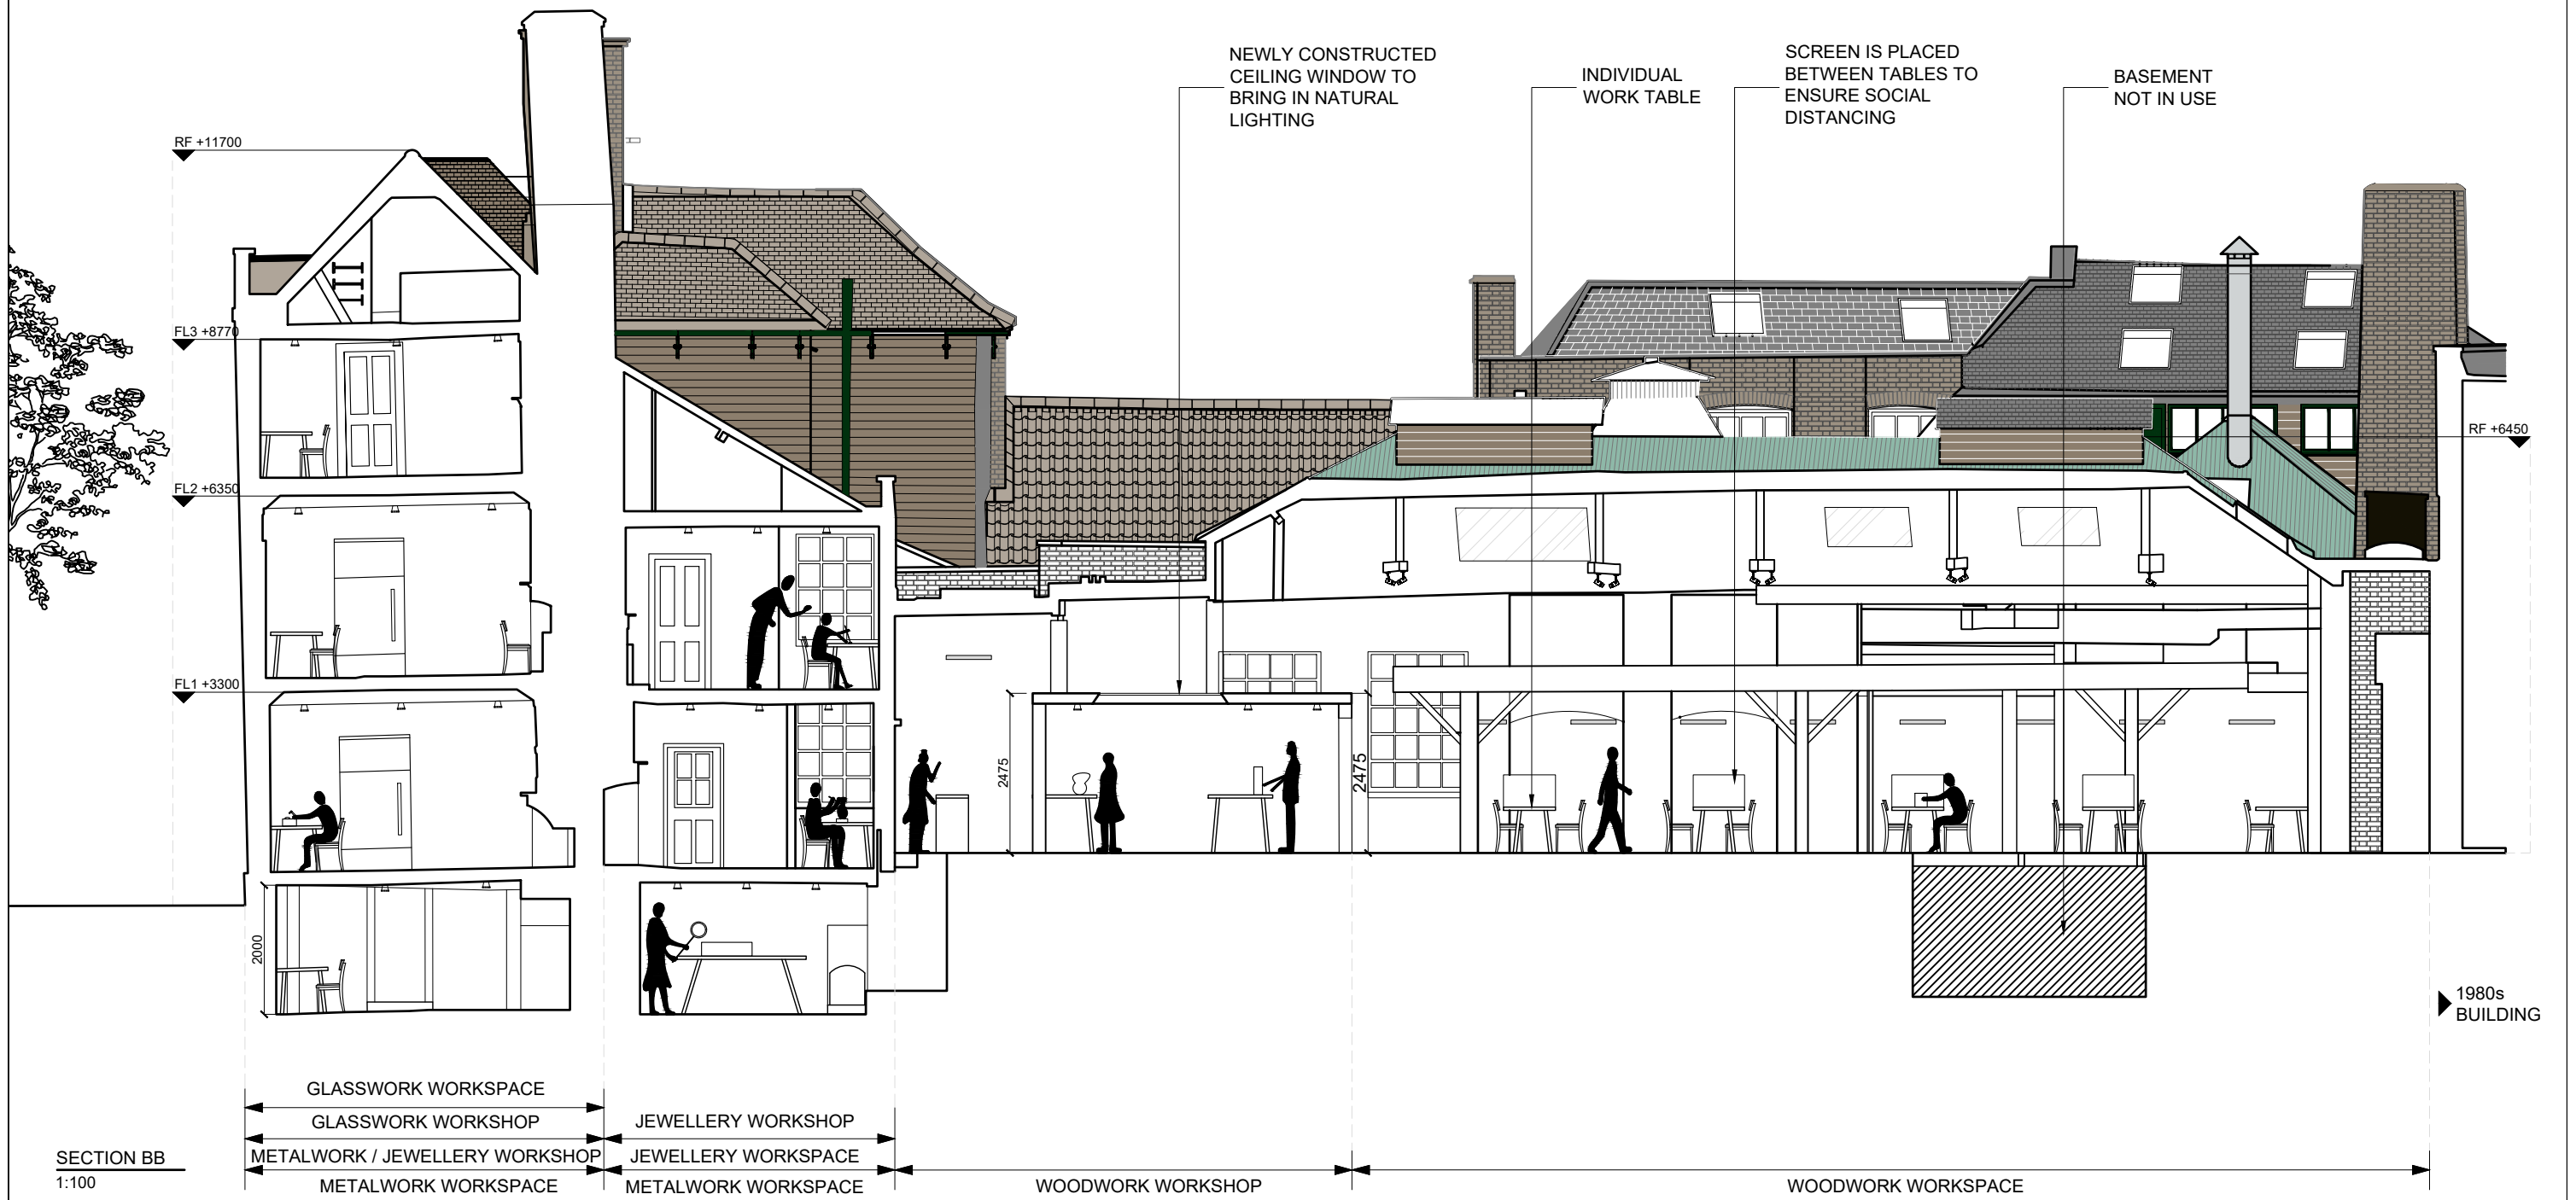

KS
Design

GENERAL NOTES

1. ALL DIMENSIONS ARE IN MILLIMETERS UNLESS OTHERWISE SPECIFIED. DO NOT SCALE THE DRAWINGS.
2. ALL DIMENSIONS SHALL BE VERIFIED ON SITE WITH CONTRACTORS BEFORE PROCEEDING WORK.
3. ALL DESIGNS ARE PROPERTY OF SO PAK LING. NO REPRODUCTION IS PERMITTED WITHOUT CONSENT.


SPECIFIC NOTES

REVISION		
NO.	DATE	ISSUE
01	30 NOV 2020	PROPOSED DESIGN LAYOUT
02	29 MAR 2021	REVISED LAYOUT

PROJECT TITLE
WHITECHAPEL HANDICRAFT LIBRARY

DRAWING TITLE
SECTION BB

PROJECT NO. FMP-01	DRAWN BY SO PAK LING	SCALE 1:100 (A3)
DATE 29 MAR 2021	REVISION NO. 02	DRAWING NO. SC-02

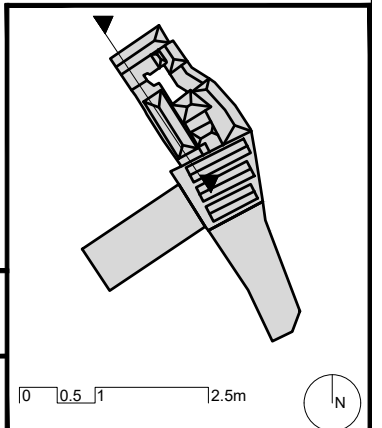



KS
Design

GENERAL NOTES

1. ALL DIMENSIONS ARE IN MILLIMETERS UNLESS OTHERWISE SPECIFIED.
2. DO NOT SCALE THE DRAWINGS.
3. ALL DIMENSIONS SHALL BE VERIFIED ON SITE WITH CONTRACTORS BEFORE PROCEEDING WORK.
4. ALL DESIGNS ARE PROPERTY OF SO PAK LING. NO REPRODUCTION IS PERMITTED WITHOUT CONSENT.

SPECIFIC NOTES

REVISION

NO.	DATE	ISSUE
01	30 NOV 2020	PROPOSED DESIGN LAYOUT
02	29 MAR 2021	REVISED LAYOUT

PROJECT TITLE

WHITECHAPEL HANDICRAFT LIBRARY

DRAWING TITLE

SECTION CC

PROJECT NO.

FMP-01

DRAWN BY

SO PAK LING

SCALE

1:100 (A3)

DATE


29 MAR 2021



REVISION NO.

02

DRAWING NO.

SC-03

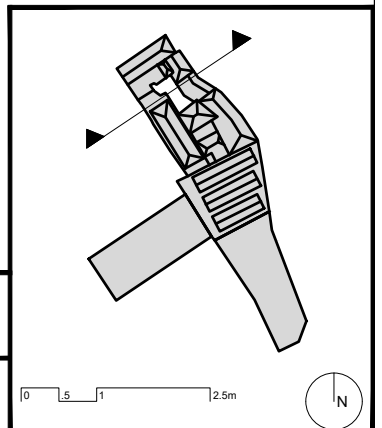

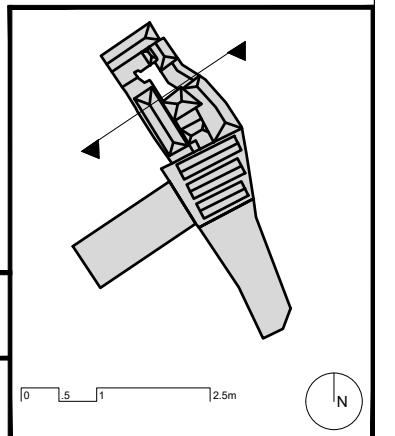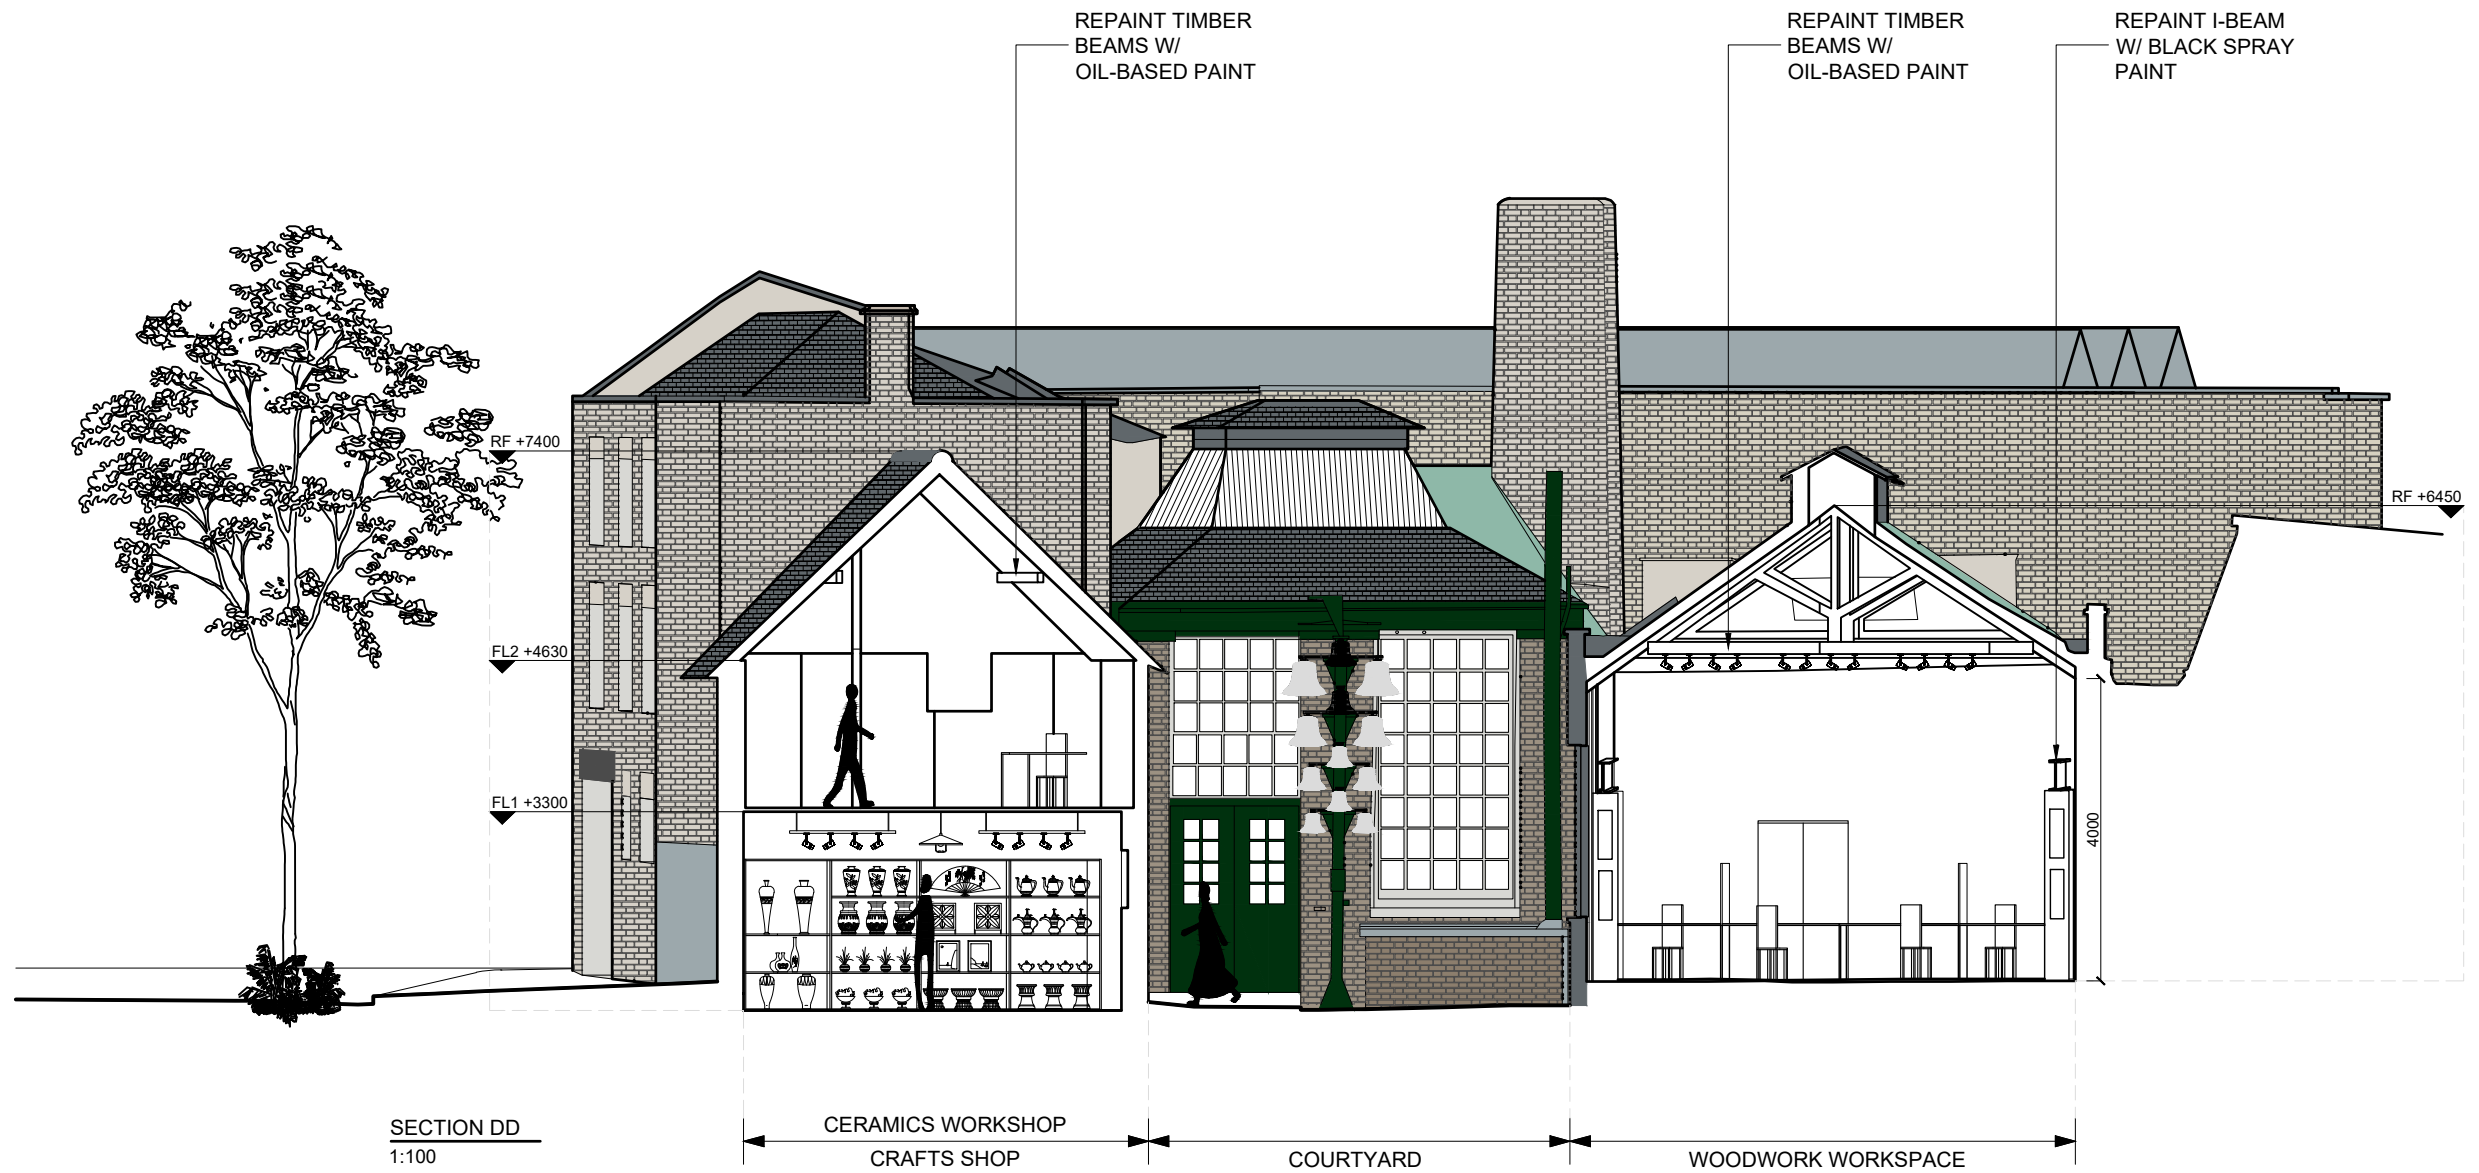

KS
Design

GENERAL NOTES

1. ALL DIMENSIONS ARE IN MILLIMETERS UNLESS OTHERWISE SPECIFIED.
2. DO NOT SCALE THE DRAWINGS.
3. ALL DIMENSIONS SHALL BE VERIFIED ON SITE WITH CONTRACTORS BEFORE PROCEEDING WORK.
4. ALL DESIGNS ARE PROPERTY OF SO PAK LING. NO REPRODUCTION IS PERMITTED WITHOUT CONSENT.

SPECIFIC NOTES

REVISION		
NO.	DATE	ISSUE
01	30 NOV 2020	PROPOSED DESIGN LAYOUT
02	29 MAR 2021	REVISED LAYOUT

PROJECT TITLE
WHITECHAPEL HANDICRAFT LIBRARY

DRAWING TITLE
SECTION DD

PROJECT NO.
FMP-01


DATE
29 MAR 2021

DRAWN BY
SO PAK LING


REVISION NO.
02

SCALE
1:100 (A3)

DRAWING NO.
SC-04

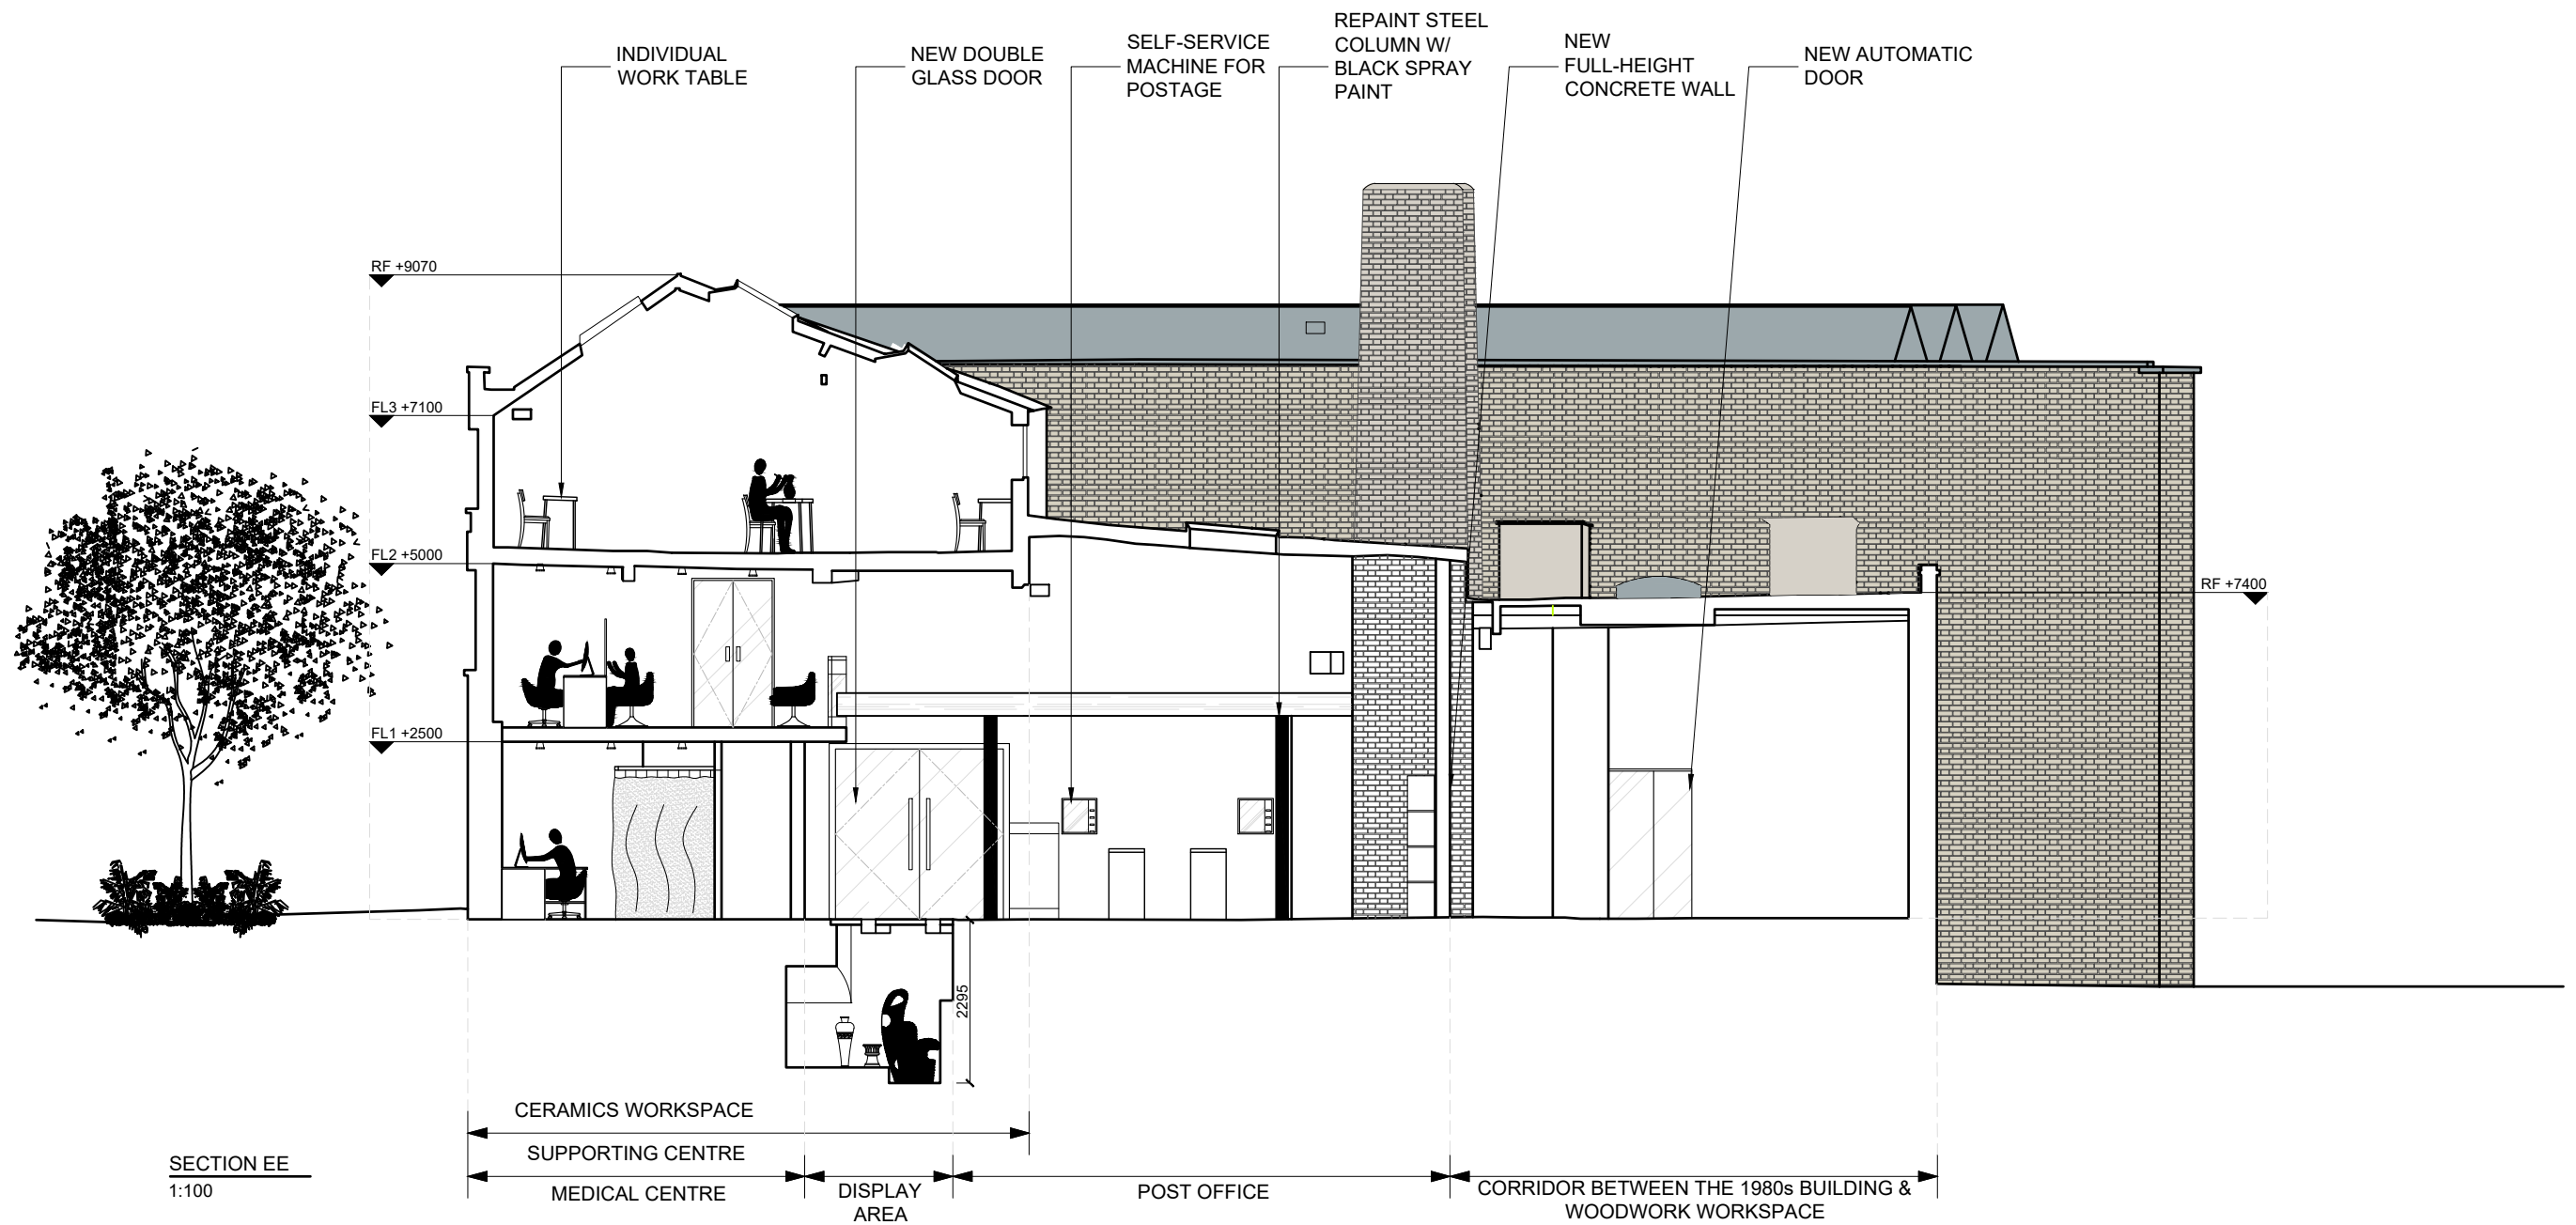

SECTION EE
1:100

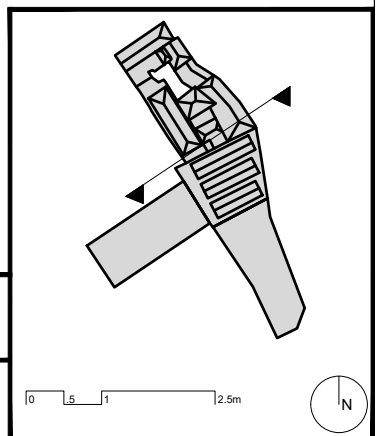

KS
Design

GENERAL NOTES

1. ALL DIMENSIONS ARE IN MILLIMETERS UNLESS OTHERWISE SPECIFIED.
2. DO NOT SCALE THE DRAWINGS.
3. ALL DIMENSIONS SHALL BE VERIFIED ON SITE WITH CONTRACTORS BEFORE PROCEEDING WORK.
4. ALL DESIGNS ARE PROPERTY OF SO PAK LING. NO REPRODUCTION IS PERMITTED WITHOUT CONSENT.

SPECIFIC NOTES

REVISION

NO.	DATE	ISSUE
01	30 NOV 2020	PROPOSED DESIGN LAYOUT
02	29 MAR 2021	REVISED LAYOUT

PROJECT TITLE

WHITECHAPEL HANDICRAFT LIBRARY

DRAWING TITLE

SECTION EE

PROJECT NO.

FMP-01

DRAWN BY

SO PAK LING

SCALE

1:100 (A3)

DATE


29 MAR 2021

REVISION NO.

02

DRAWING NO.

SC-05

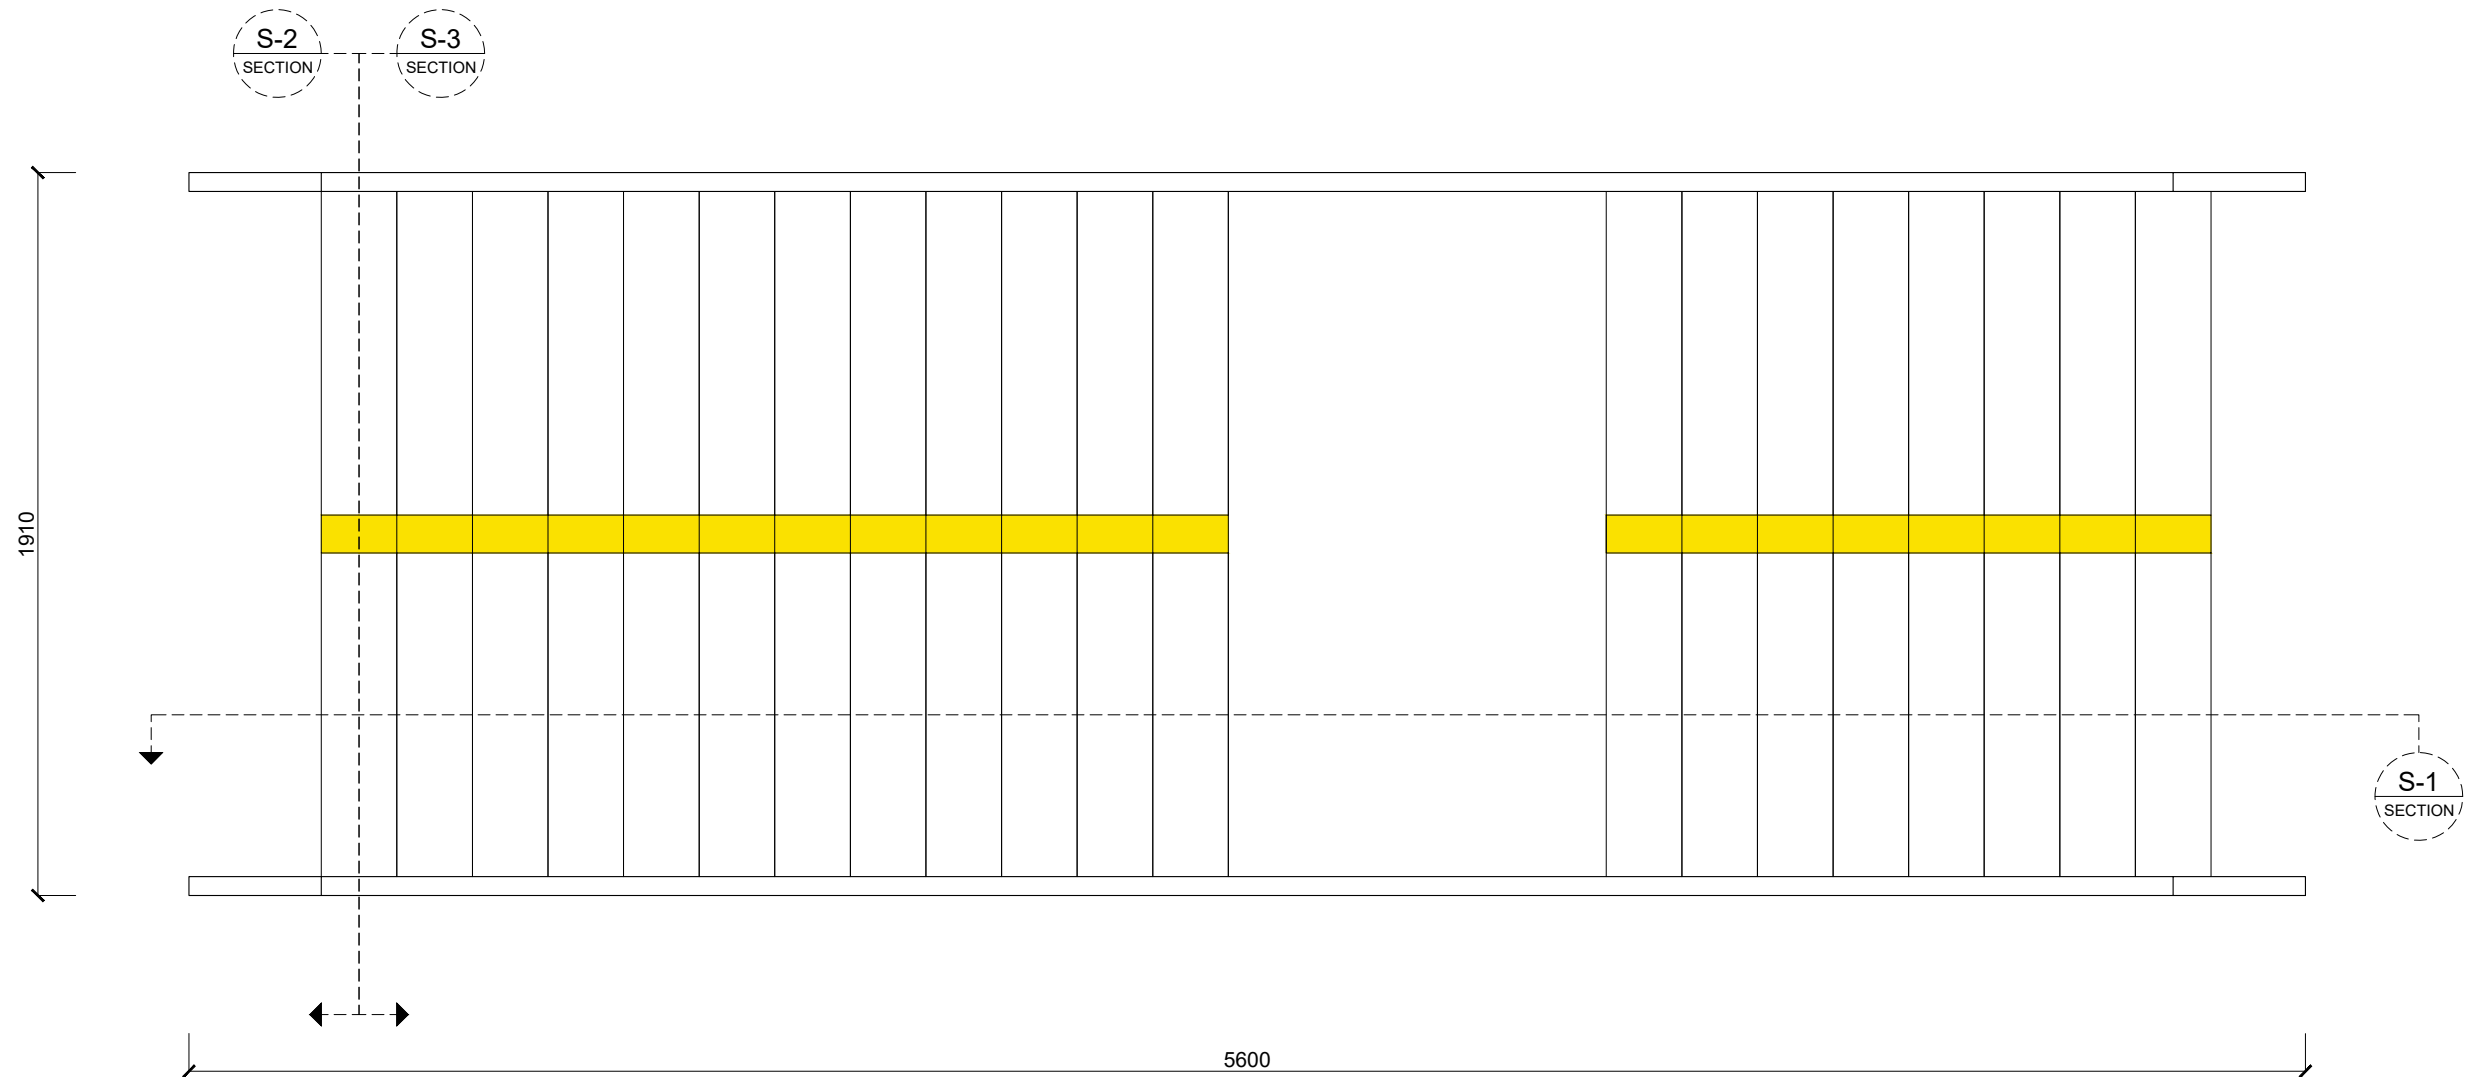

FLOOR PLAN 1:20
MAIN STAIRCASE



GENERAL NOTES

1. ALL DIMENSIONS ARE IN MILLIMETERS UNLESS OTHERWISE SPECIFIED.
2. DO NOT SCALE THE DRAWINGS.
3. ALL DIMENSIONS SHALL BE VERIFIED ON SITE WITH CONTRACTORS BEFORE PROCEEDING WORK.
4. ALL DESIGNS ARE PROPERTY OF SO PAK LING. NO REPRODUCTION IS PERMITTED WITHOUT CONSENT.

SPECIFIC NOTES


REVISION		
NO.	DATE	ISSUE

PROJECT TITLE
WHITECHAPEL HANDICRAFT LIBRARY
DRAWING TITLE
MAIN STAIRCASE DETAILING

PROJECT NO.
FMP-01
DATE
13 MAR 2021

DRAWN BY
SO PAK LING
REVISION NO.
01

SCALE
1:20 (A3)
DRAWING NO.
DE-01-01

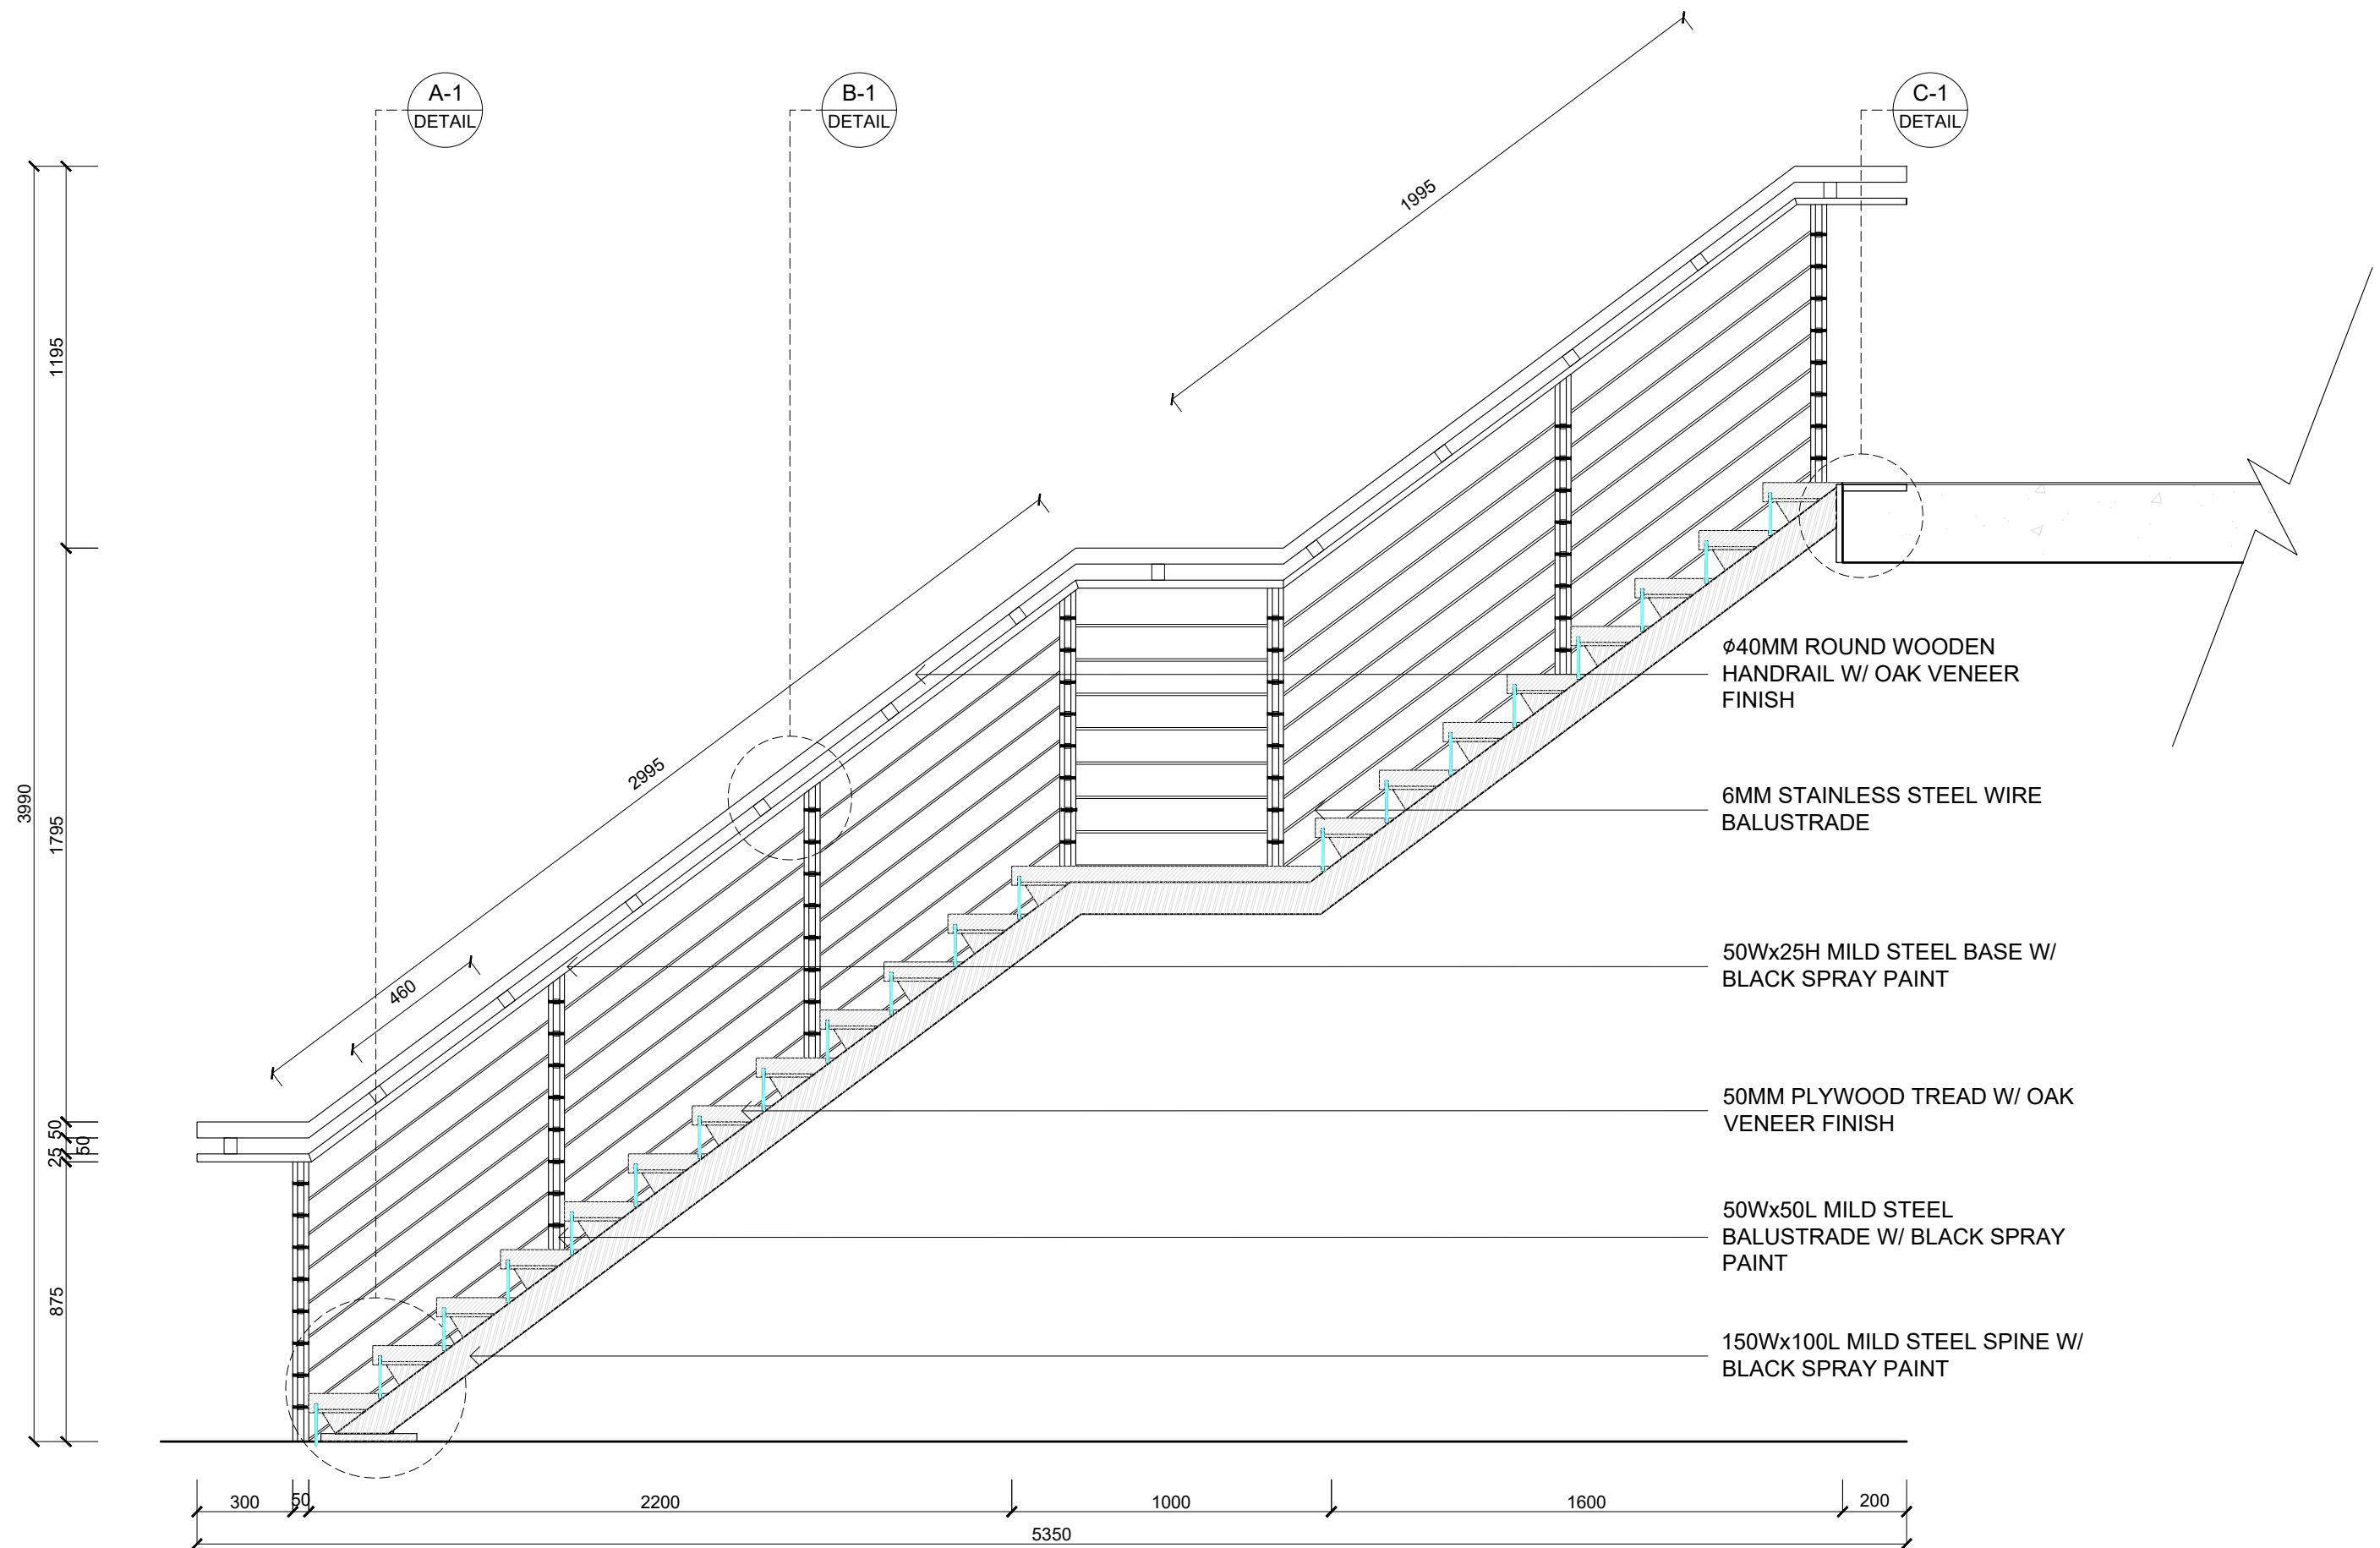

SECTION S-1
MAIN STAIRCASE

1:20




- GENERAL NOTES
1. ALL DIMENSIONS ARE IN MILLIMETERS UNLESS OTHERWISE SPECIFIED. DO NOT SCALE THE DRAWINGS.
 2. ALL DIMENSIONS SHALL BE VERIFIED ON SITE WITH CONTRACTORS BEFORE PROCEEDING WORK.
 3. ALL DESIGNS ARE PROPERTY OF SO PAK LING. NO REPRODUCTION IS PERMITTED WITHOUT CONSENT.


SPECIFIC NOTES

REVISION		
NO.	DATE	ISSUE


PROJECT TITLE WHITECHAPEL HANDICRAFT LIBRARY		PROJECT NO. FMP-01	DRAWN BY SO PAK LING	SCALE 1:20 (A3)
DRAWING TITLE MAIN STAIRCASE DETAILING		DATE 13 MAR 2021	REVISION NO. 01	DRAWING NO. DE-01-02

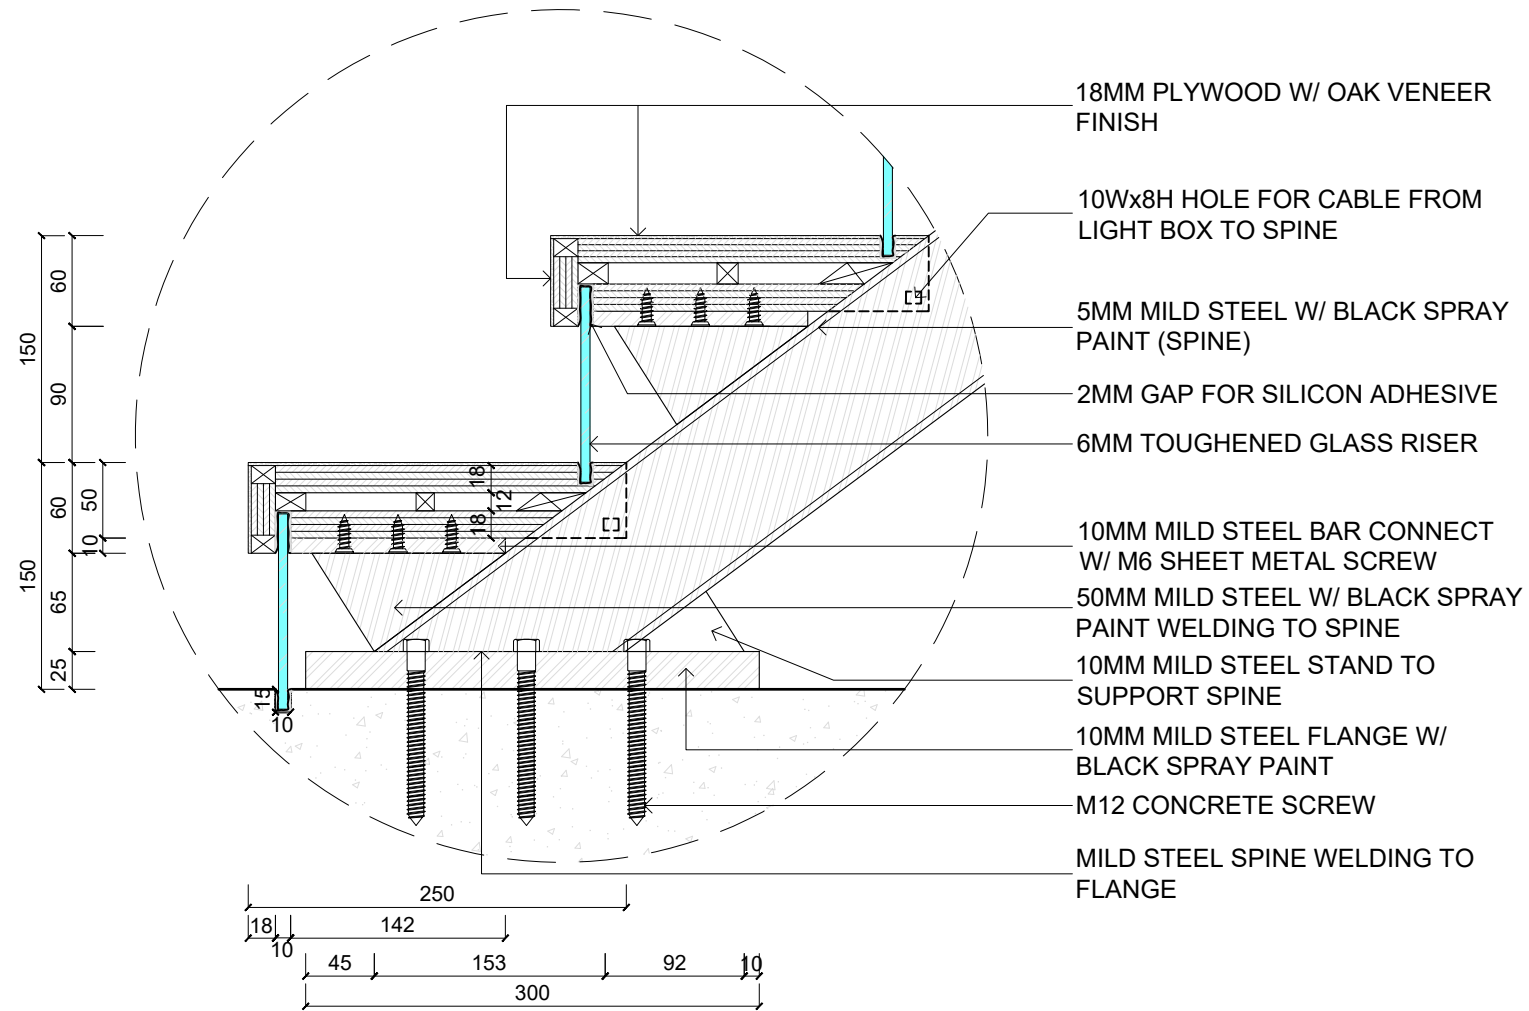

DETAIL A-1 1:5
MAIN STAIRCASE STRUCTURE
(CONNECTING TO FLOOR)

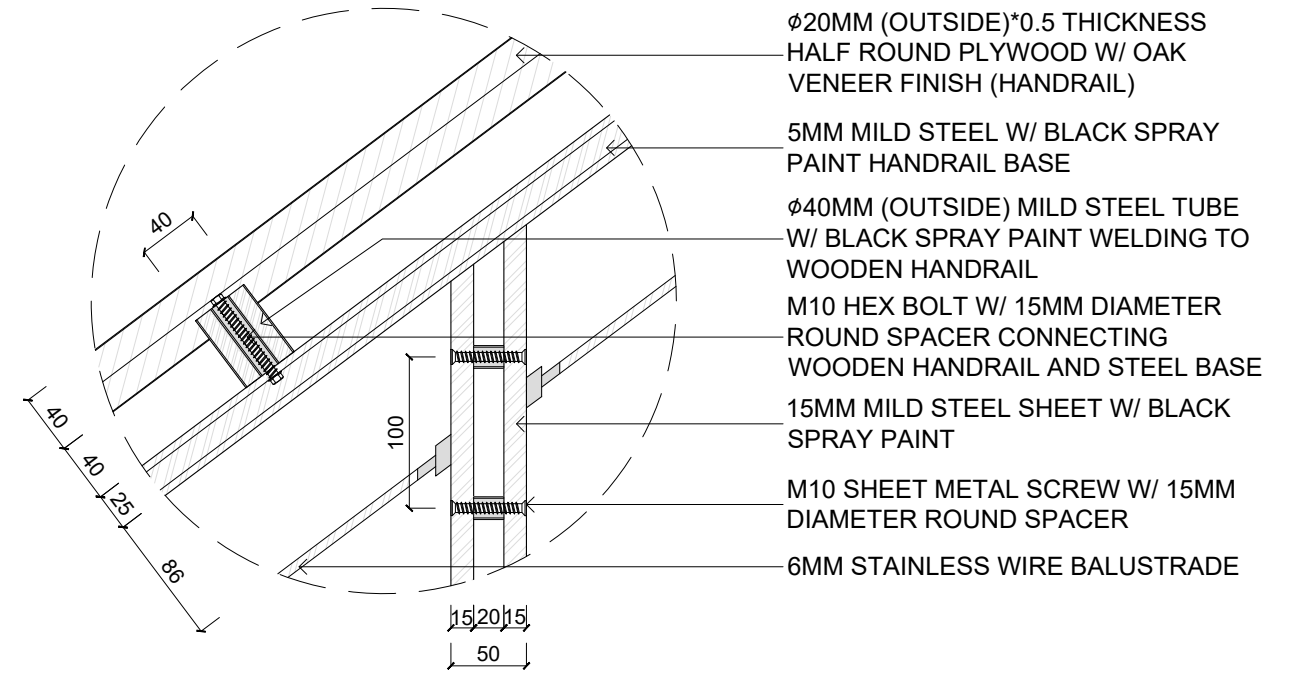

DETAIL B-1 1:5
MAIN STAIRCASE HANDRAIL

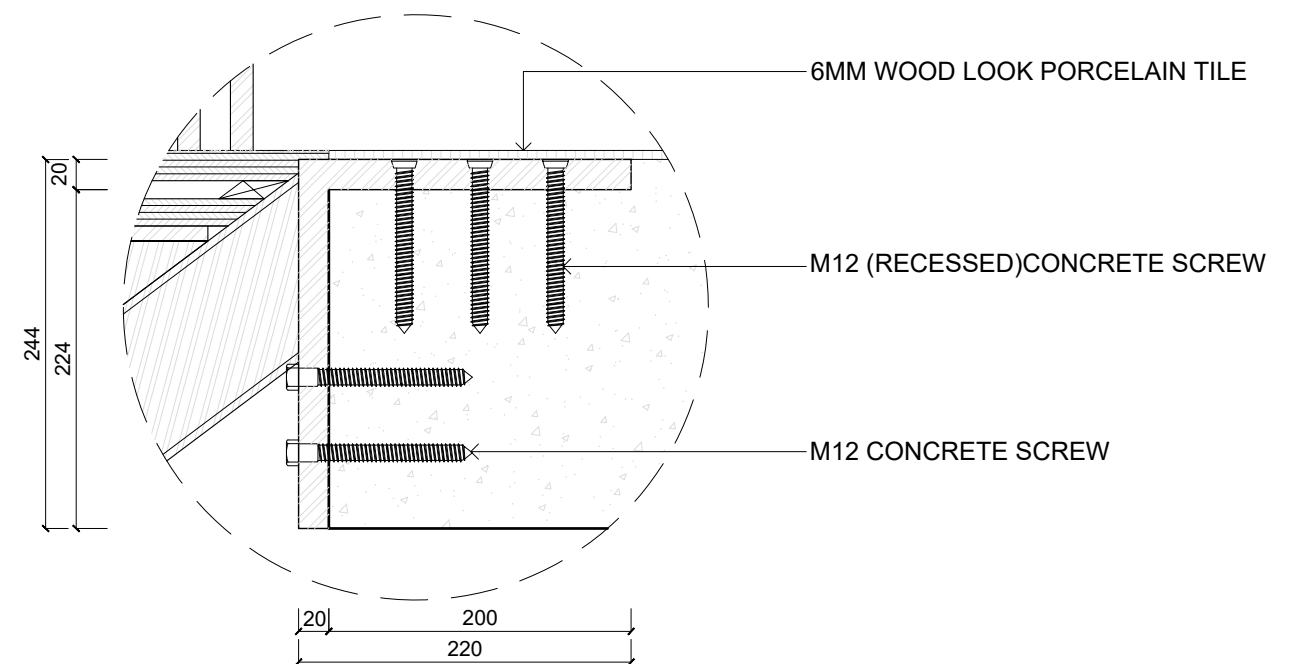

DETAIL C-1 1:5
MAIN STAIRCASE STRUCTURE
(CONNECTING TO PLATFORM)

GENERAL NOTES

1. ALL DIMENSIONS ARE IN MILLIMETERS UNLESS OTHERWISE SPECIFIED.
2. DO NOT SCALE THE DRAWINGS.
3. ALL DIMENSIONS SHALL BE VERIFIED ON SITE WITH CONTRACTORS BEFORE PROCEEDING WORK.
4. ALL DESIGNS ARE PROPERTY OF SO PAK LING. NO REPRODUCTION IS PERMITTED WITHOUT CONSENT.

SPECIFIC NOTES

REVISION

NO.	DATE	ISSUE

PROJECT TITLE

WHITECHAPEL HANDICRAFT LIBRARY

DRAWING TITLE

MAIN STAIRCASE DETAILING

PROJECT NO.

FMP-01

DATE

13 MAR 2021

DRAWN BY

SO PAK LING

REVISION NO.





01

SCALE

AS SHOWN
(A3)

DRAWING NO.

DE-01-03

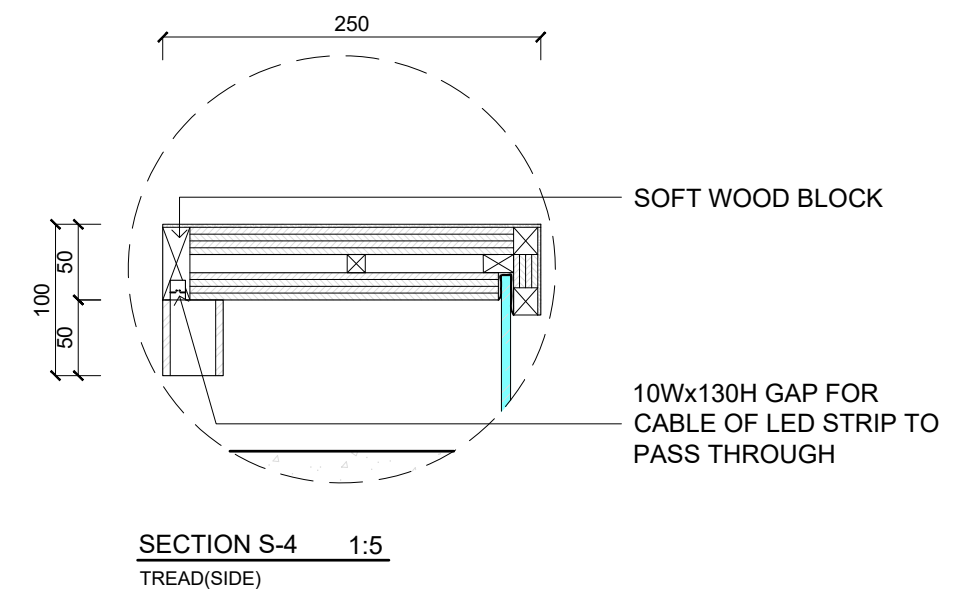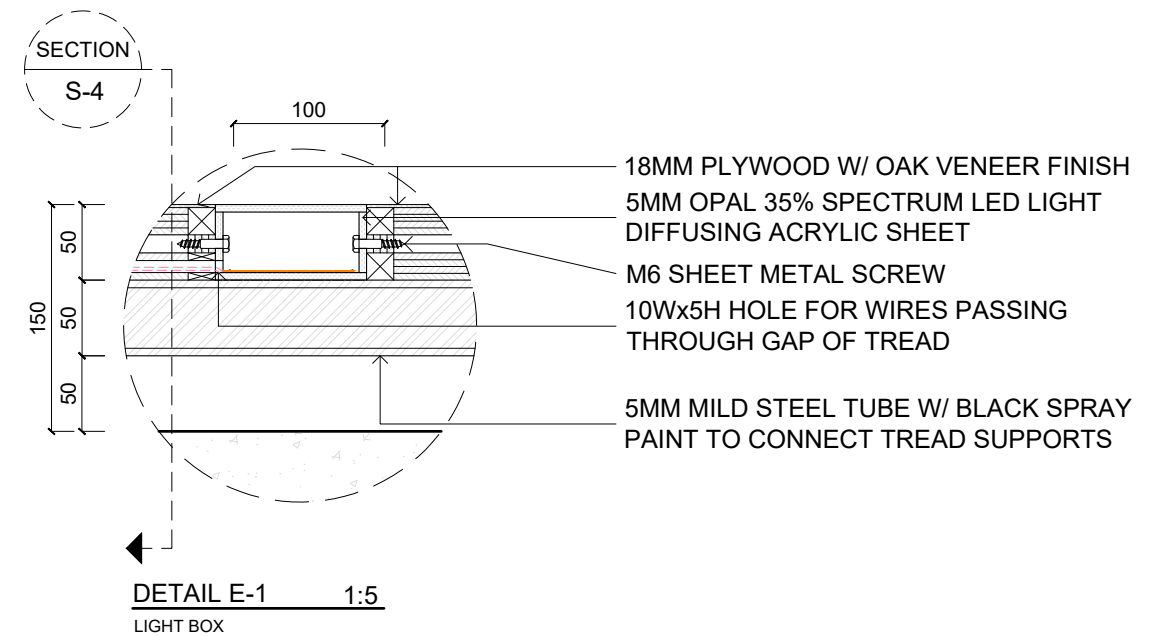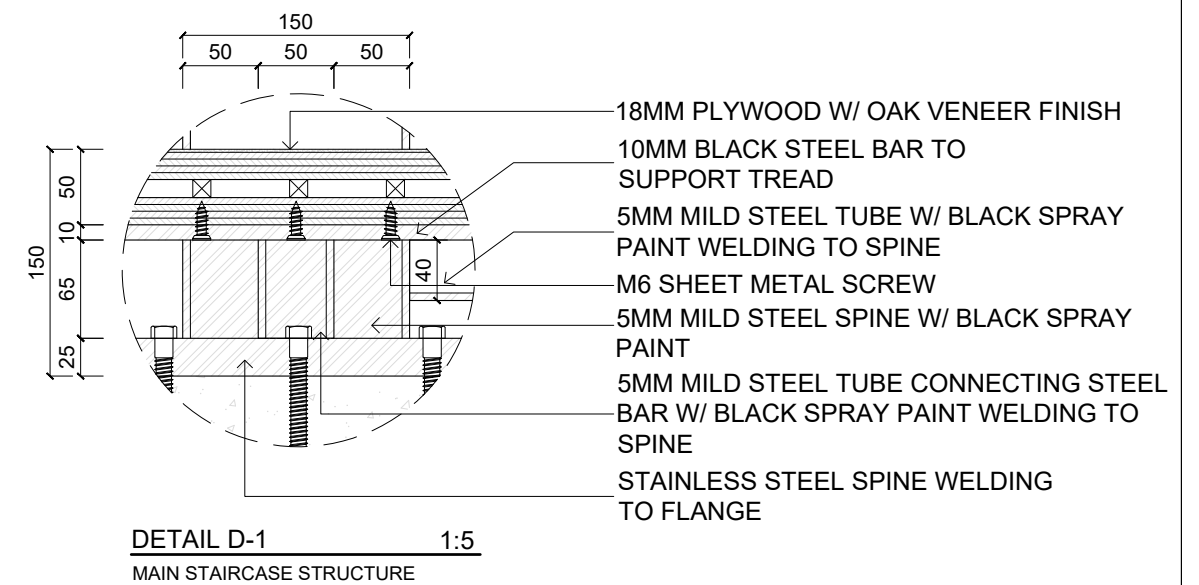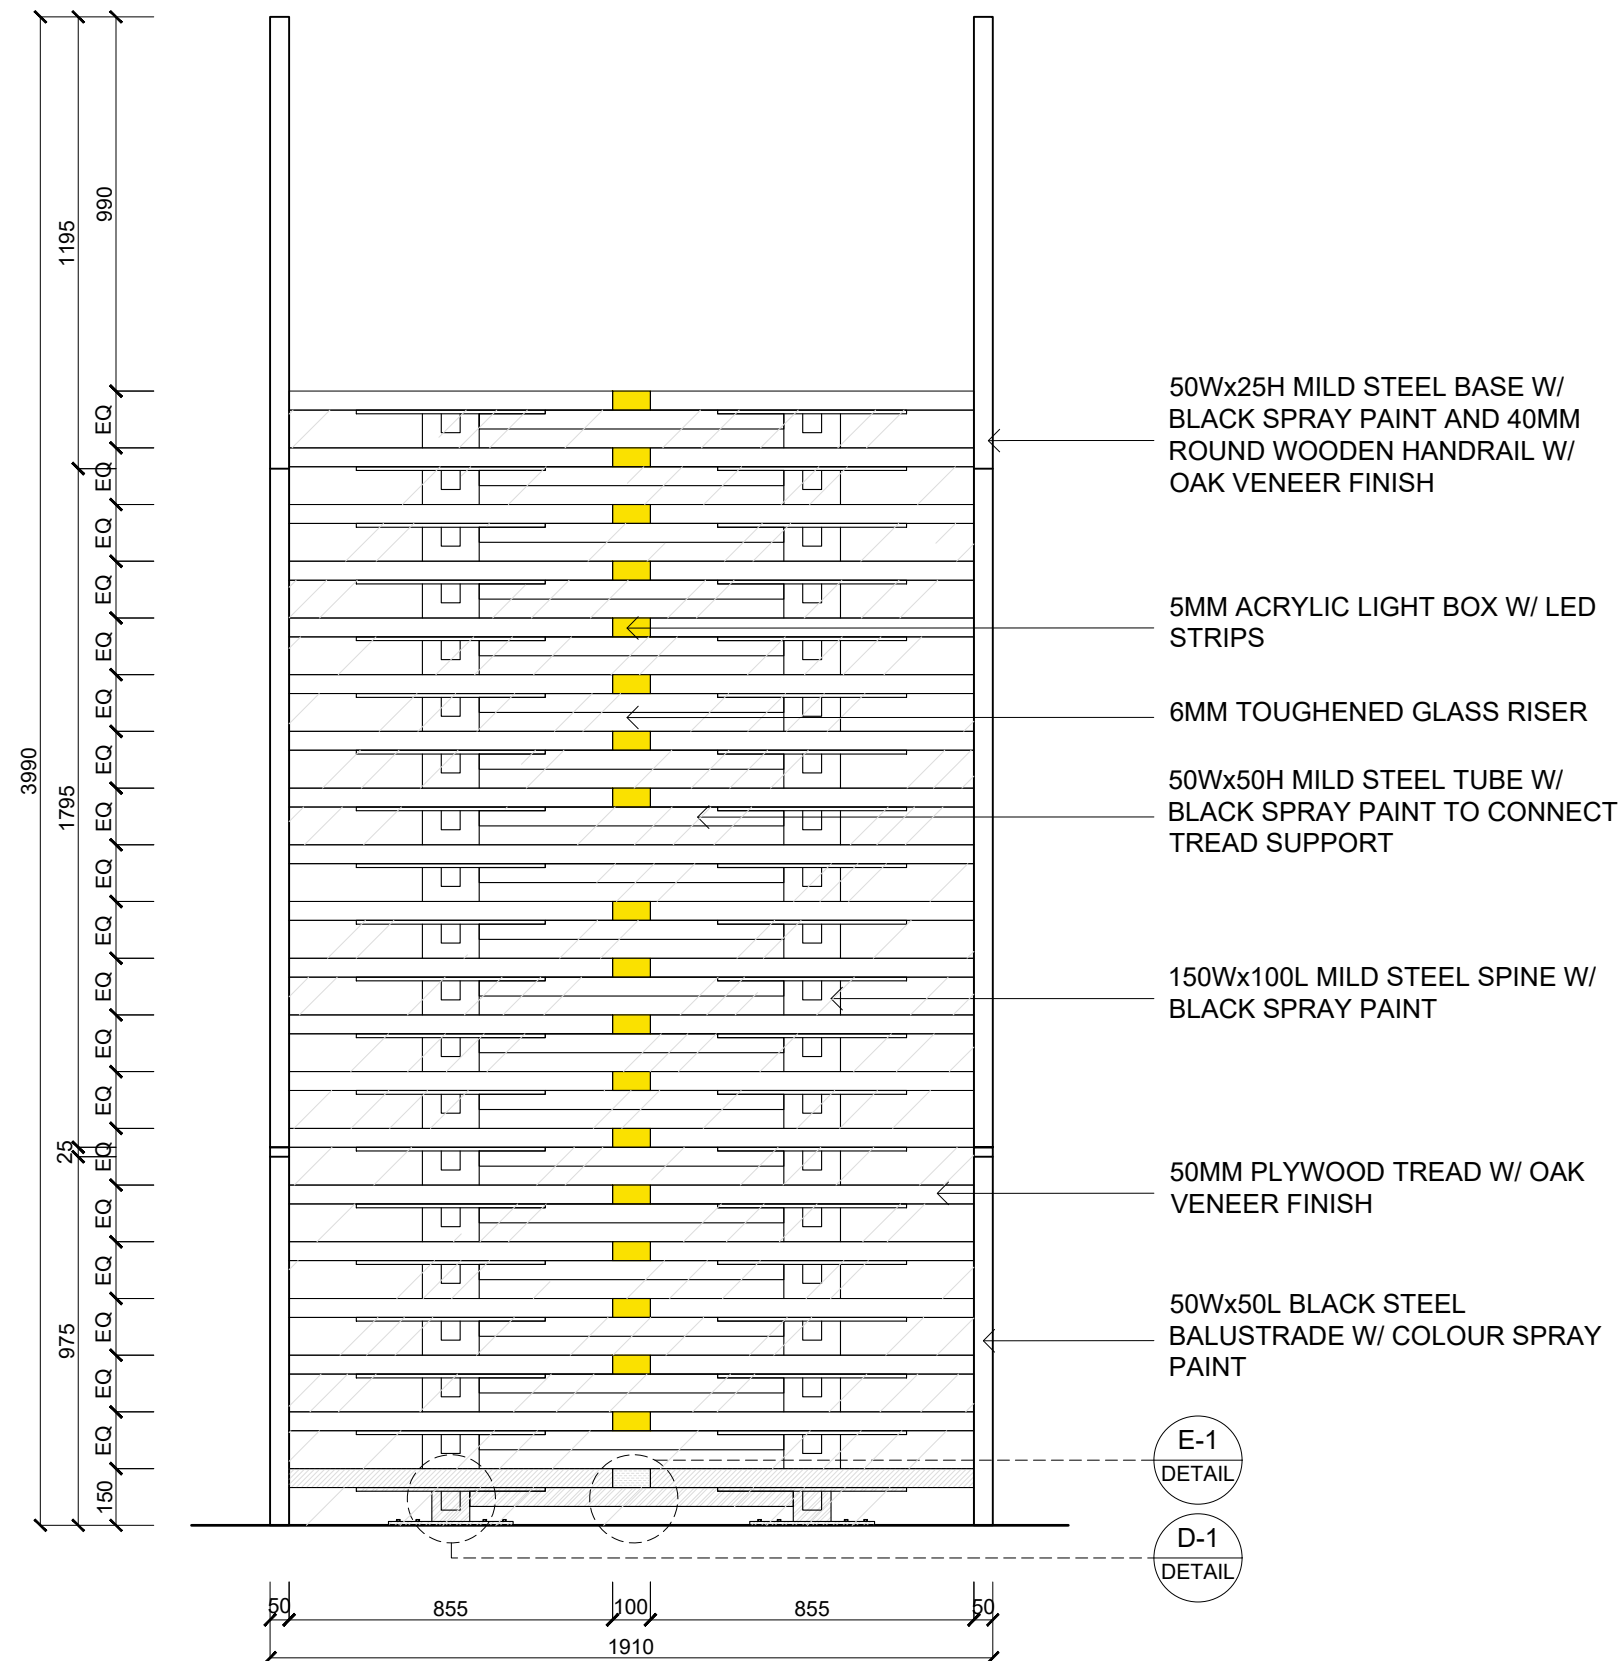

KS
Design

GENERAL NOTES

1. ALL DIMENSIONS ARE IN MILLIMETERS UNLESS OTHERWISE SPECIFIED. DO NOT SCALE THE DRAWINGS.
2. ALL DIMENSIONS SHALL BE VERIFIED ON SITE WITH CONTRACTORS BEFORE PROCEEDING WORK.
3. ALL DESIGNS ARE PROPERTY OF SO PAK LING. NO REPRODUCTION IS PERMITTED WITHOUT CONSENT.

SPECIFIC NOTES

REVISION		
NO.	DATE	ISSUE

PROJECT TITLE
WHITECHAPEL HANDICRAFT LIBRARY

DRAWING TITLE
MAIN STAIRCASE DETAILING

PROJECT NO.
FMP-01


DATE
13 MAR 2021

DRAWN BY
SO PAK LING

REVISION NO.
01

SCALE
AS SHOWN
(A3)

DRAWING NO.
DE-01-04

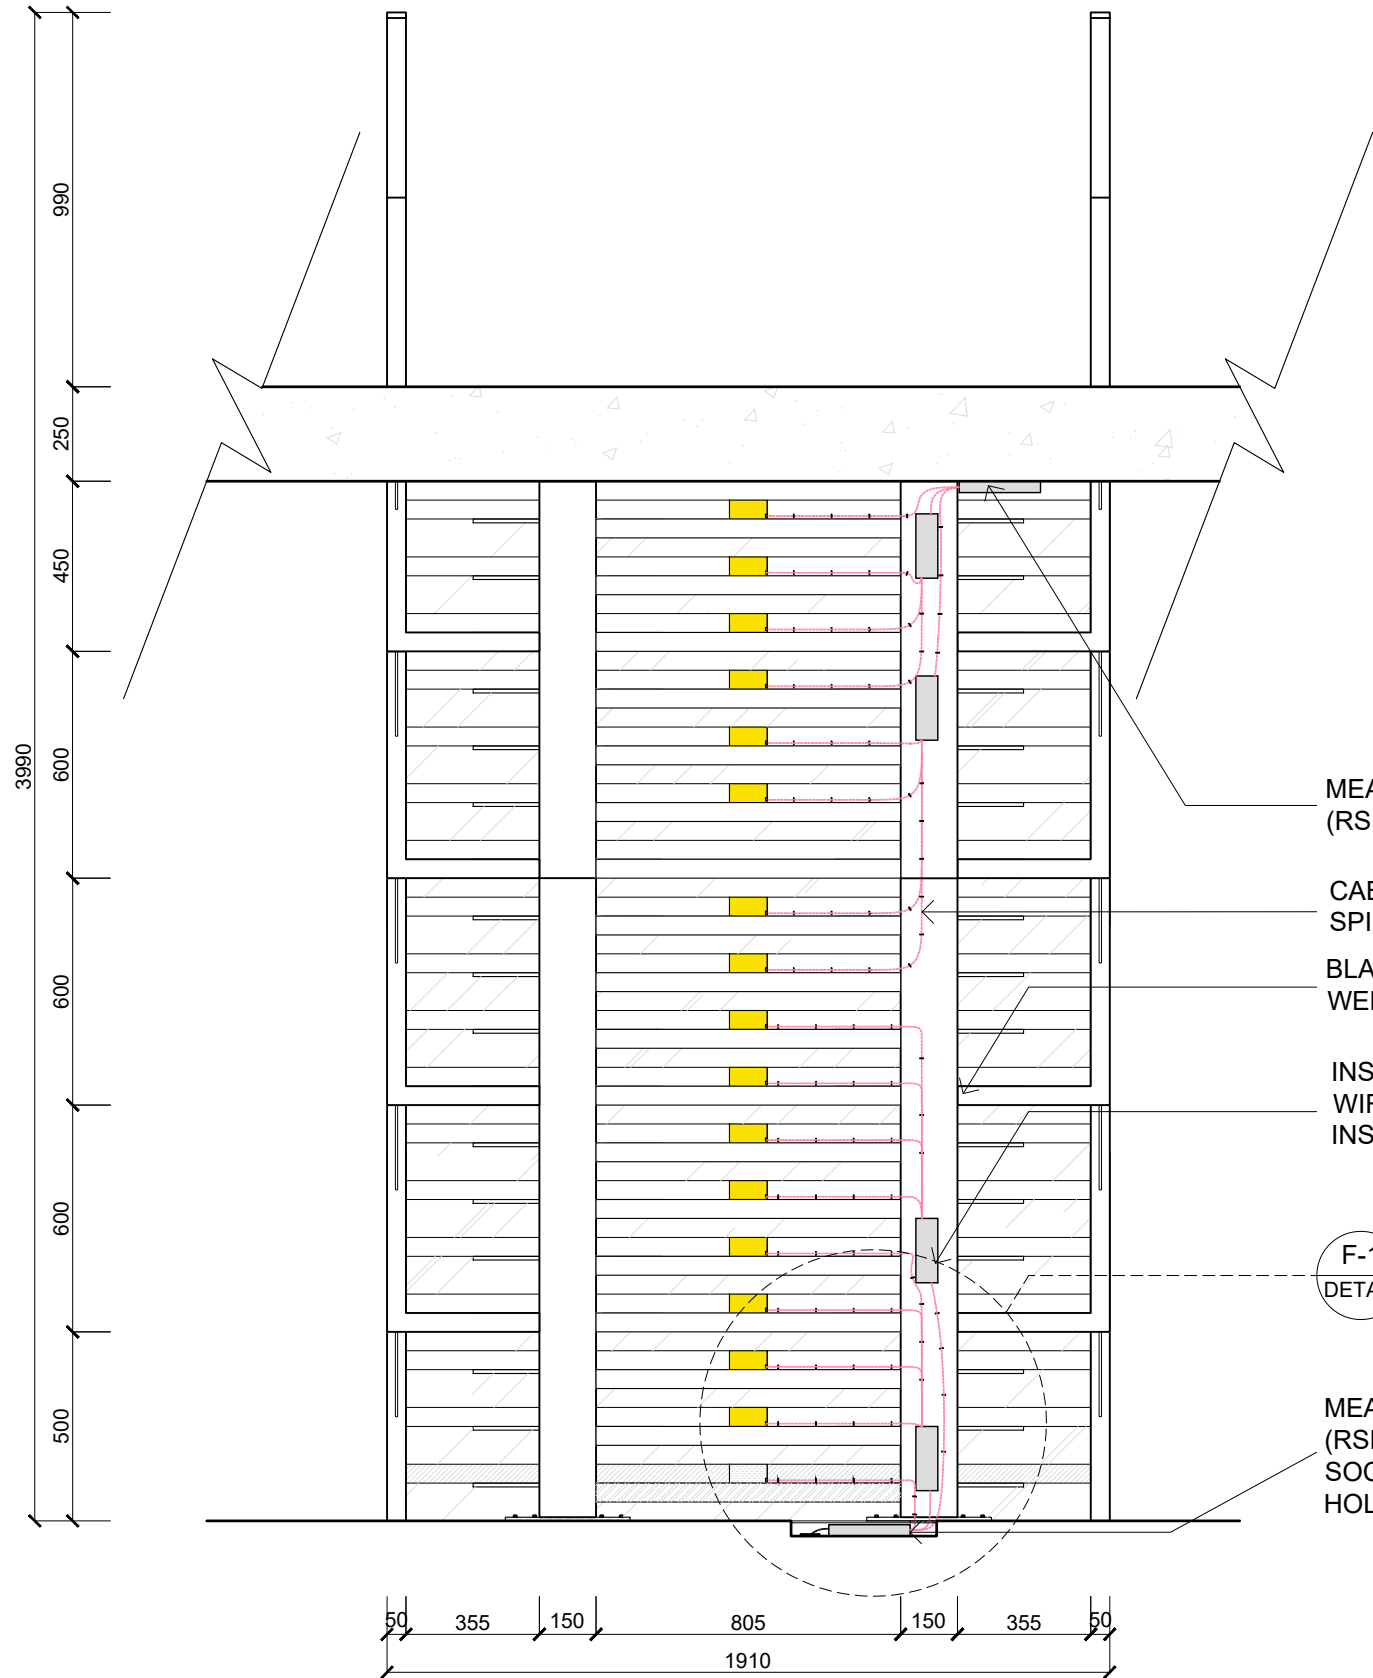

SECTION S-3
MAIN STAIRCASE

1:20



FIG.7

CABLE CONNECTING LED STRIP TO POWER
10MM SILICON MOUNTING CLIP W/ SCREWS
4-CHANNEL WIRELESS RECEIVER (170L*58W*30H)
10Wx8H HOLE FOR CABLE PASS THROUGH SPINE AND CONNECT TO POWER SUPPLY
ACRYLIC LIGHT BOX (DETAIL F-2)
GAP FOR CABLE PASS THROUGH TREAD AND CONNECT TO POWER SUPPLY


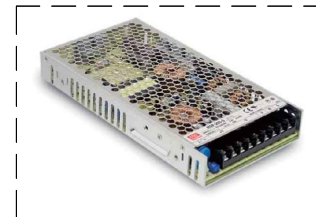


FIG.8

MEAN WELL 200W LED DRIVER W/ 3 OUTPUT SLOT (215L*115W*30H)

DETAIL F-1
LED STRIPS

1:10

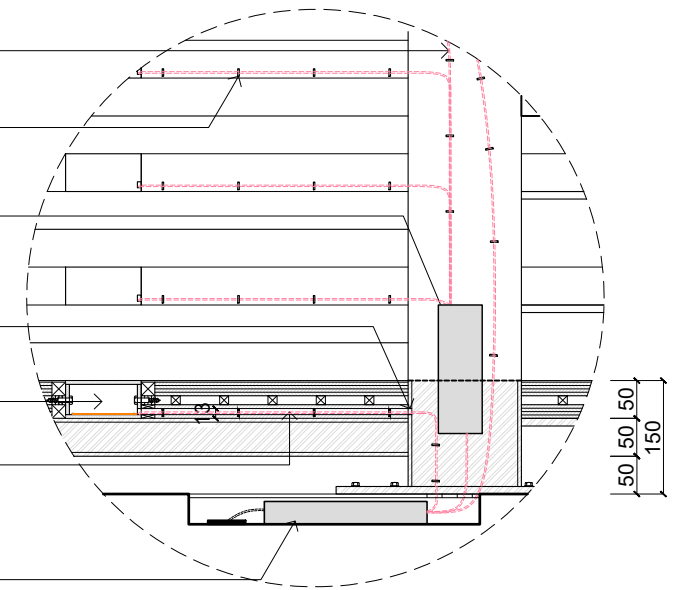

50 50 50 150

MEAN WELL 200WATT LED DRIVER (RSP-200-12) ATTACH TO CEILING

CABLE OF LED STRIP PASS THROUG SPINE

BLACK STEEL BALUSTRADE WELDING TO SPINE

INSTYLE MULTICHANNEL WIRELESS RECEIVER INSTALL INSIDE SPINE (4-CHANNEL, 12V)

F-1
DETAIL

MEAN WELL 200WATT LED DRIVER (RSP-200-12) CONNECTING TO SOCKET UNDERGROUND W/ 20MM HOLES TO RELEASE HEAT



FIG.9


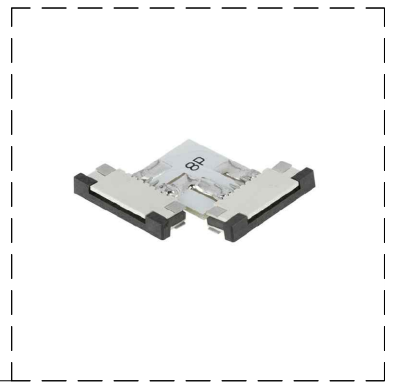


FIG.10

8MM FLEXIBLE LIGHT STRIP 90 DEGREE CONNECT

8MM 10WATT WHITE LED STRIP

10Wx8H HOLE FOR WIRES

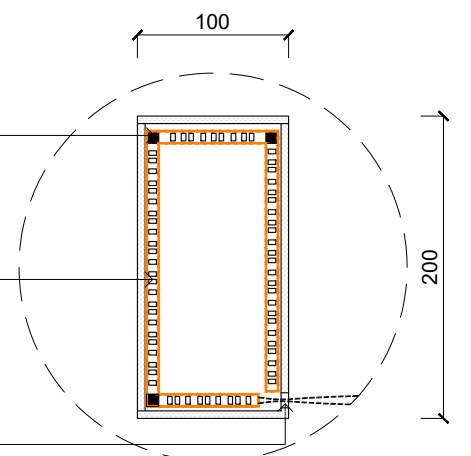

100 200

DETAIL F-2
LIGHT BOX(TOP)

1:5

KS

GENERAL NOTES

1. ALL DIMENSIONS ARE IN MILLIMETERS UNLESS OTHERWISE SPECIFIED. DO NOT SCALE THE DRAWINGS.
2. ALL DIMENSIONS SHALL BE VERIFIED ON SITE WITH CONTRACTORS BEFORE PROCEEDING WORK.
3. ALL DESIGNS ARE PROPERTY OF SO PAK LING. NO REPRODUCTION IS PERMITTED WITHOUT CONSENT.

SPECIFIC NOTES

1. MATERIAL AND LOOSE FURNITURE ARE SUBJECT TO CHANGE UPON AVAILABILITY
- REFERENCE
FIG.7 Insstyle LED (2019) 4-Channel LED Receiver (8mm) (online) available from <https://www.insstyleled.com/multichannel-receiver/> (1 March 2021)
FIG.8 Super Bright LEDs Inc. (2021) Mean Well LED Switching Power Supply (online) available from <https://www.superbrightleds.com/mean-well-led-switching-power-supply/> (1 March 2021)
FIG.9 8mm 10Watt White LED Strip (online) available from <https://www.superbrightleds.com/8mm-10watt-white-led-strip/> (1 March 2021)
FIG.10 Super Bright LEDs Inc. (2021) 8mm 10Watt White LED Strip (online) available from <https://www.superbrightleds.com/8mm-10watt-white-led-strip/> (1 March 2021)

REVISION

NO.	DATE	ISSUE

PROJECT TITLE

WHITECHAPEL HANDICRAFT LIBRARY

DRAWING TITLE

MAIN STAIRCASE DETAILING

PROJECT NO.

FMP-01

DATE

13 MAR 2021

DRAWN BY

SO PAK LING

REVISION NO.


01

SCALE

AS SHOWN (A3)

DRAWING NO.

DE-01-05

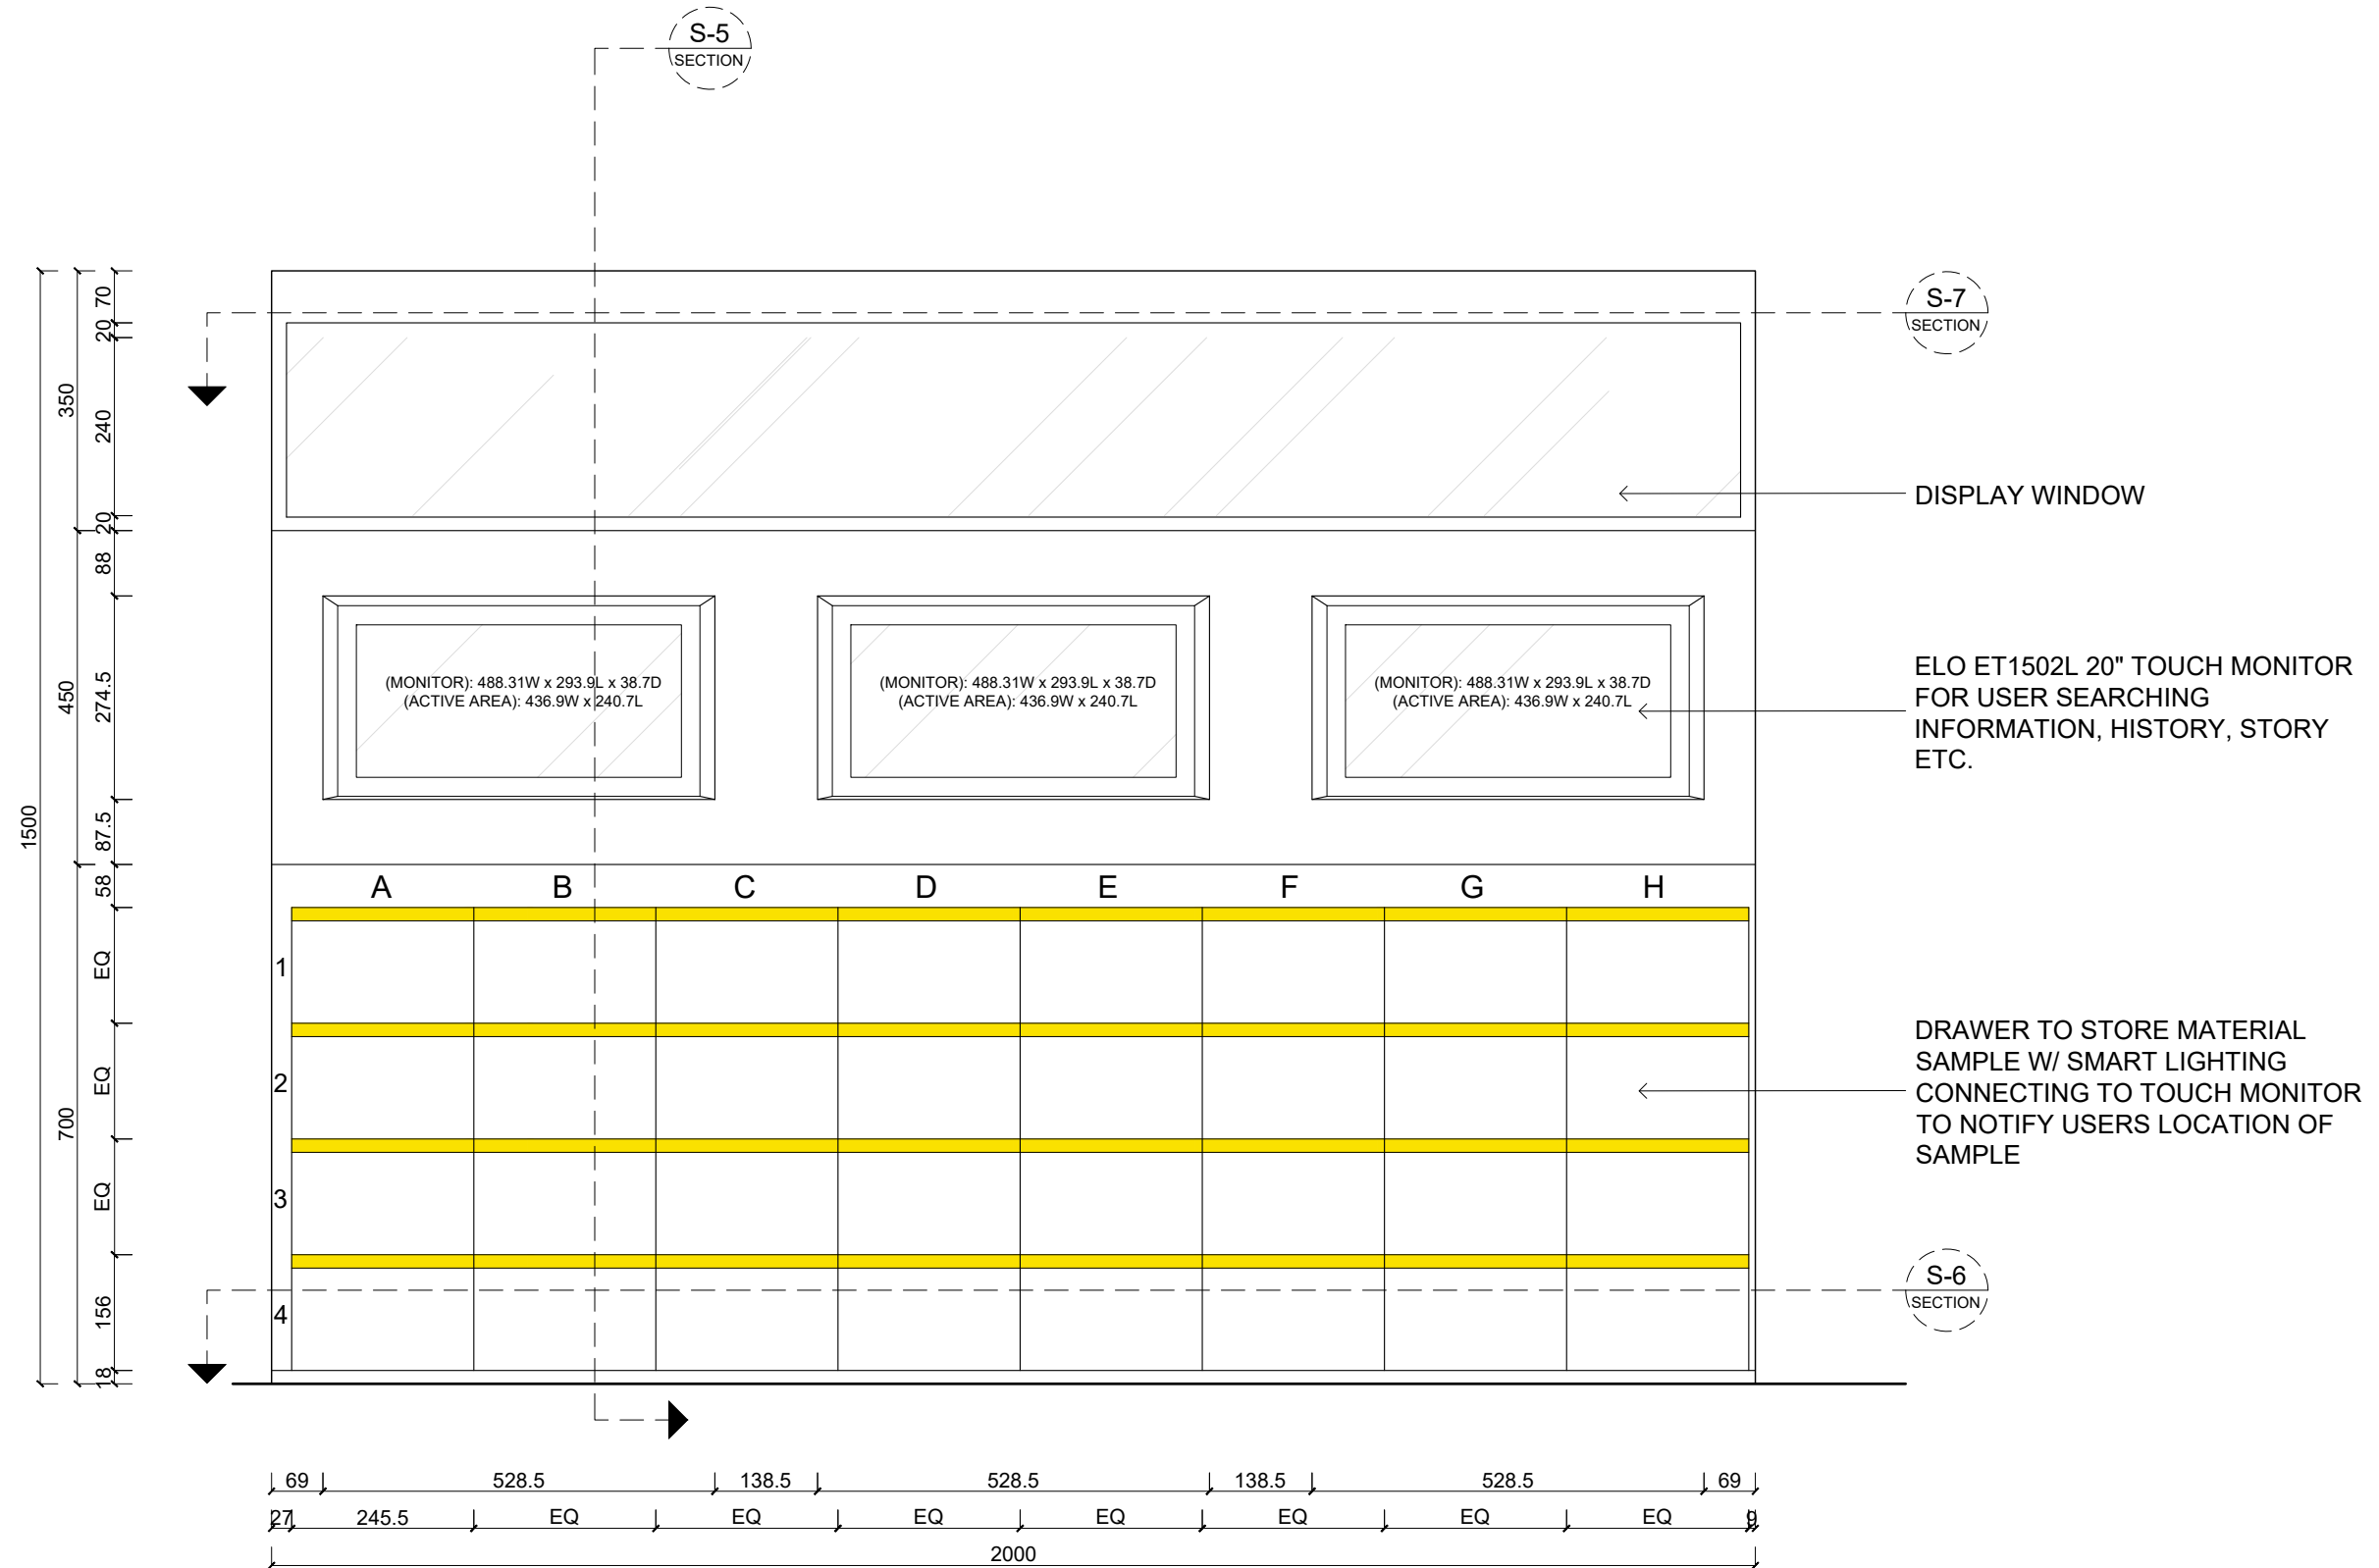

ELEVATION (FRONT) 1:10
MATERIAL LIBRARY



GENERAL NOTES

- ALL DIMENSIONS ARE IN MILLIMETERS UNLESS OTHERWISE SPECIFIED. DO NOT SCALE THE DRAWINGS.
- ALL DIMENSIONS SHALL BE VERIFIED ON SITE WITH CONTRACTORS BEFORE PROCEEDING WORK.
- ALL DESIGNS ARE PROPERTY OF SO PAK LING. NO REPRODUCTION IS PERMITTED WITHOUT CONSENT.

SPECIFIC NOTES

- MATERIAL AND LOOSE FURNITURE ARE SUBJECT TO CHANGE UPON AVAILABILITY

REFERENCE

FIG 5 BLT Direct Ltd. (2021) 2 Metre Recessed Surface Black LED Profile P4 (15mm x 7mm) C/W Clear Cover [online] available from <https://www.bltdirect.com/2-metre-recessed-surface-black-led-profile-p4-15mm-x-7mm?adclid=pla&gclid=Cj0KCQwI7yCBQJAPRwMMPsQMZ2BQ4AJmo9AATTBBL6W6GusKvIperCB83CJapC3XFR_jR8awwABWEALe_wcB> [15 March 2021]

FIG 6 Elsey (2021) Wine Red Premium 100% Cotton Velvet Fabric Material - 112cm (44") wide [online] available from <<https://www.elsay.com/elling/52728286/wine-red-premium-100-cotton-velvet>> [15 March 2021]

REVISION		
NO.	DATE	ISSUE

PROJECT TITLE

WHITECHAPEL HANDICRAFT LIBRARY

DRAWING TITLE

MATERIAL LIBRARY DETAILING

PROJECT NO.

FMP-01

DATE

15 MAR 2021

DRAWN BY

SO PAK LING

REVISION NO.


01

SCALE

1:10 (A3)

DRAWING NO.

DE-02-01

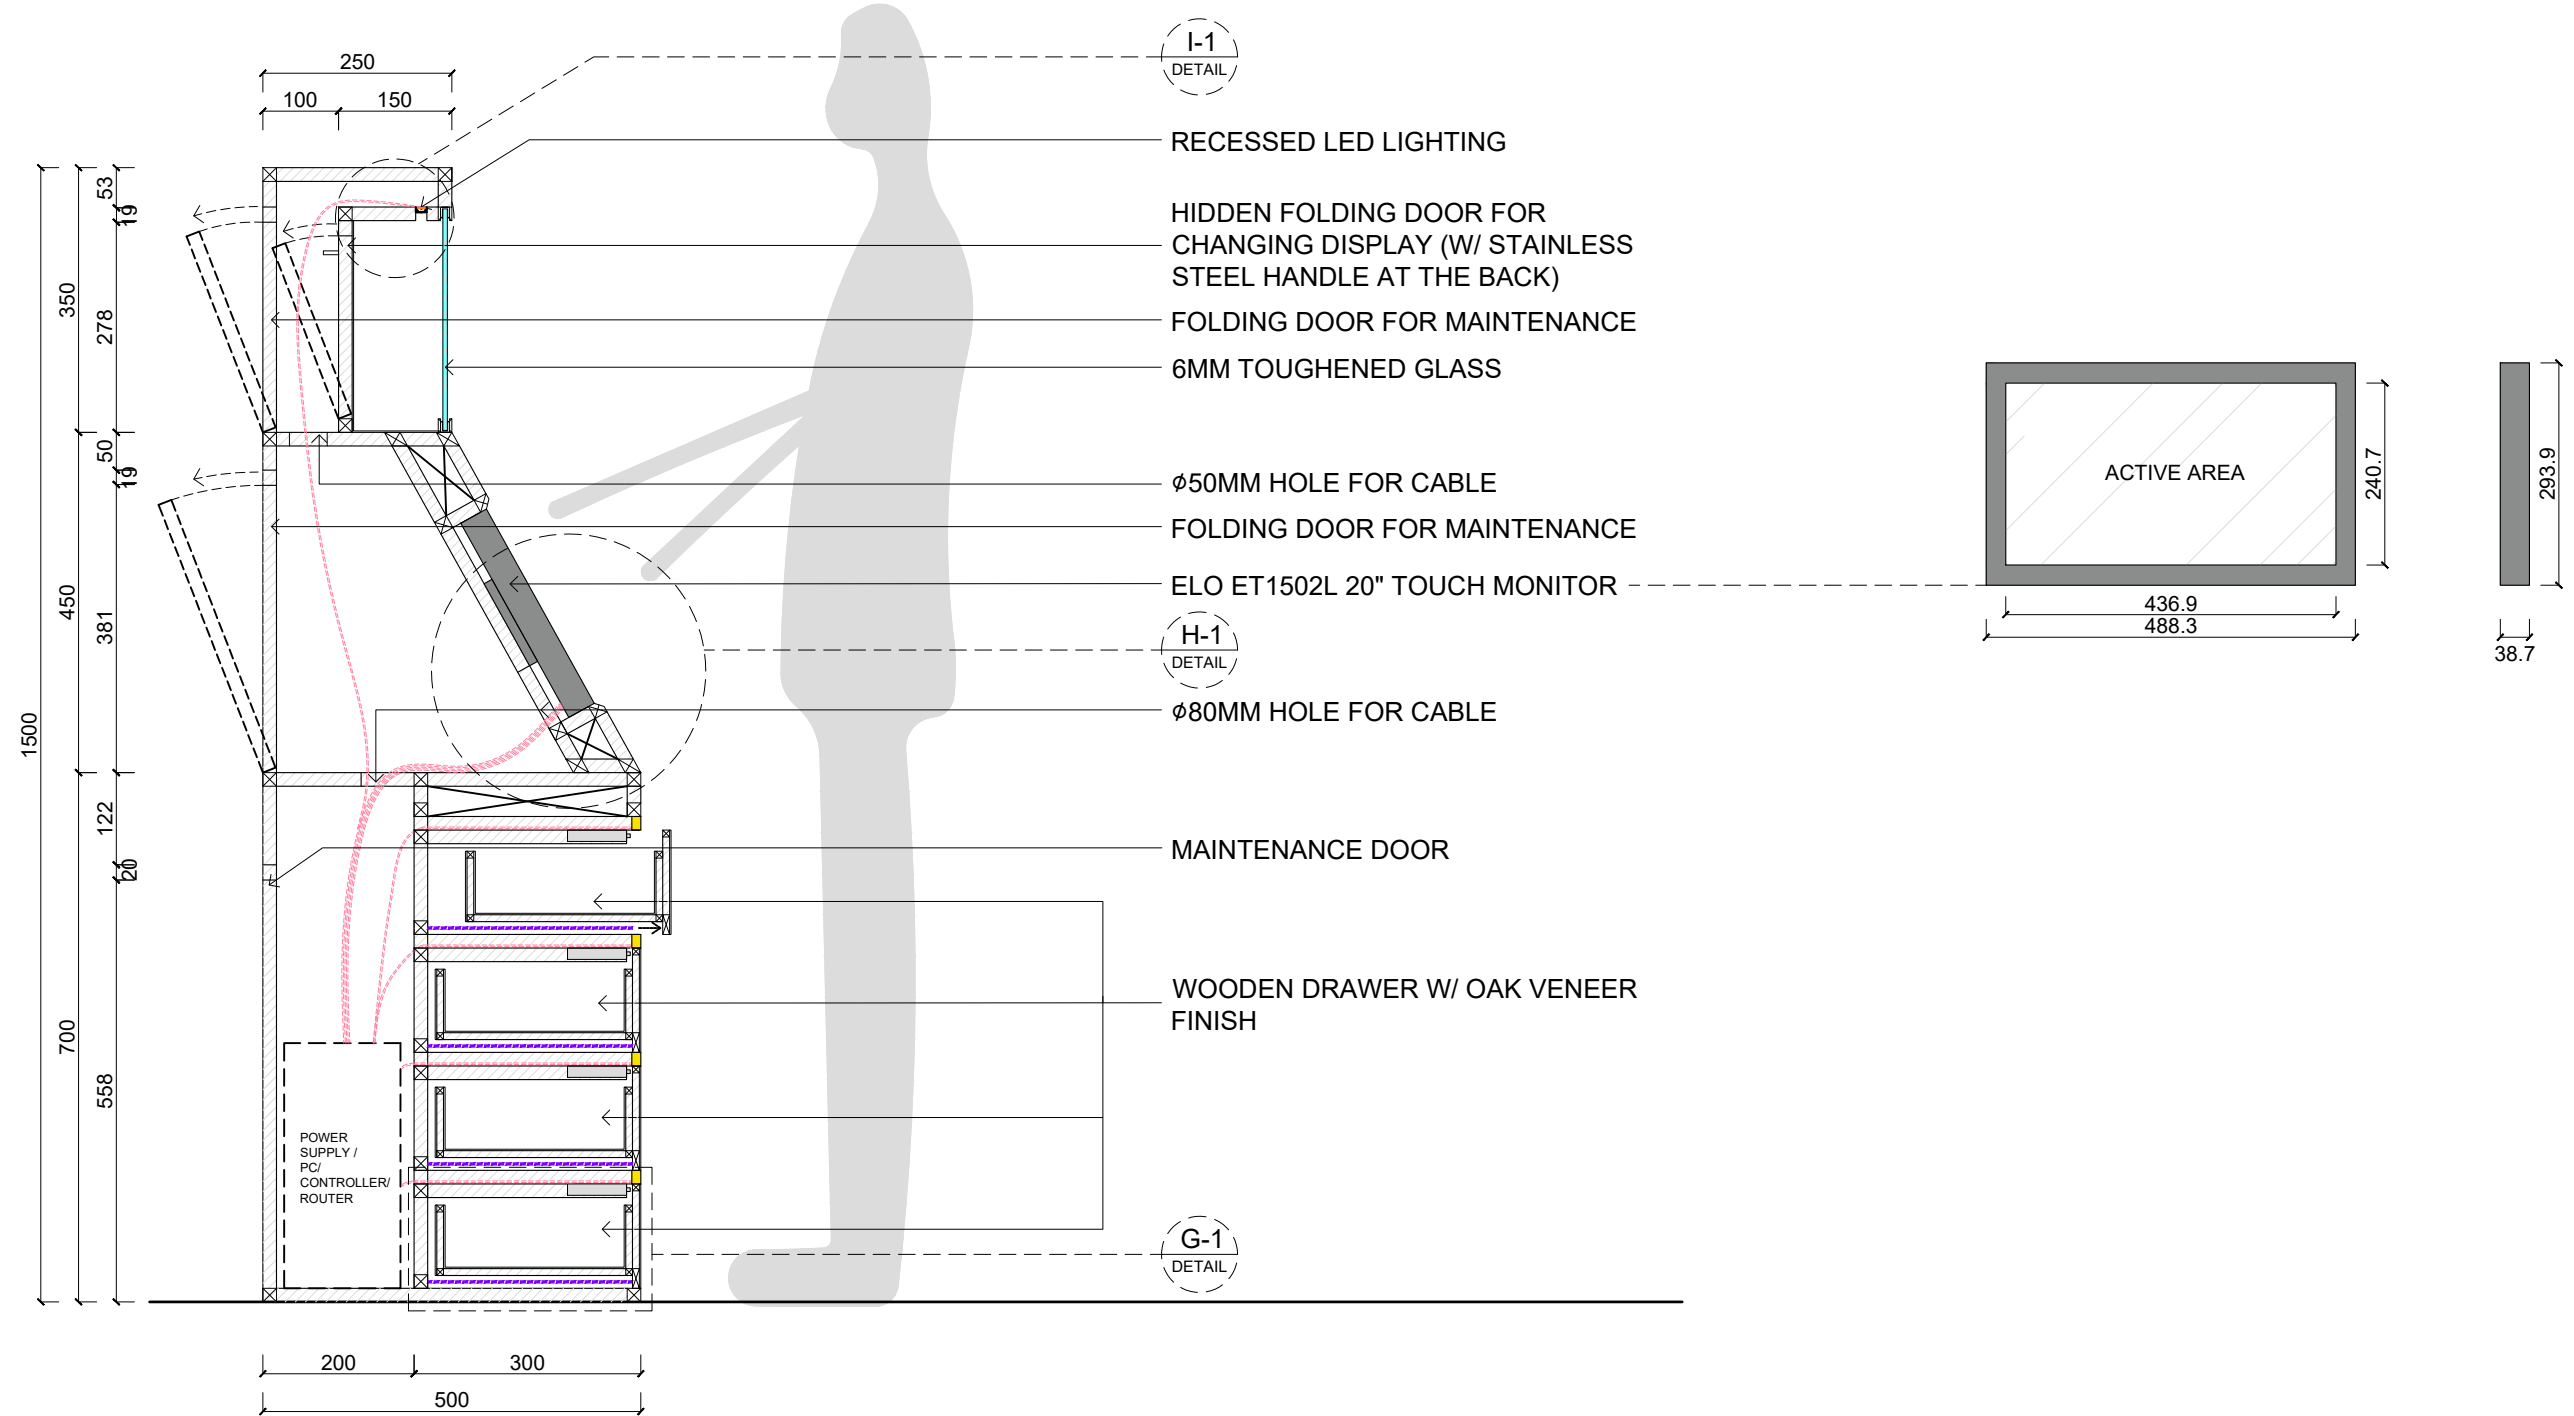

SECTION S-5 1:10
MATERIAL LIBRARY







GENERAL NOTES


1. ALL DIMENSIONS ARE IN MILLIMETERS UNLESS OTHERWISE SPECIFIED.
2. DO NOT SCALE THE DRAWINGS.
3. ALL DIMENSIONS SHALL BE VERIFIED ON SITE WITH CONTRACTORS BEFORE PROCEEDING WORK.
4. ALL DESIGNS ARE PROPERTY OF SO PAK LING. NO REPRODUCTION IS PERMITTED WITHOUT CONSENT.

SPECIFIC NOTES


REVISION		
NO.	DATE	ISSUE

PROJECT TITLE	PROJECT NO.	DRAWN BY	SCALE
WHITECHAPEL HANDICRAFT LIBRARY	FMP-01	SO PAK LING	1:10 (A3)
DRAWING TITLE	DATE	REVISION NO.	DRAWING NO.
MATERIAL LIBRARY DETAILING	15 MAR 2021	01	DE-02-02

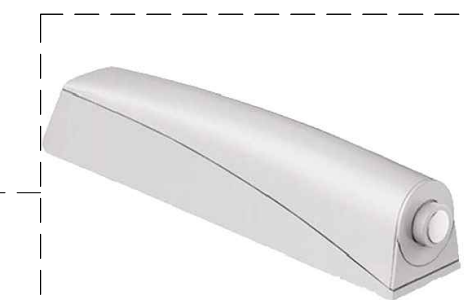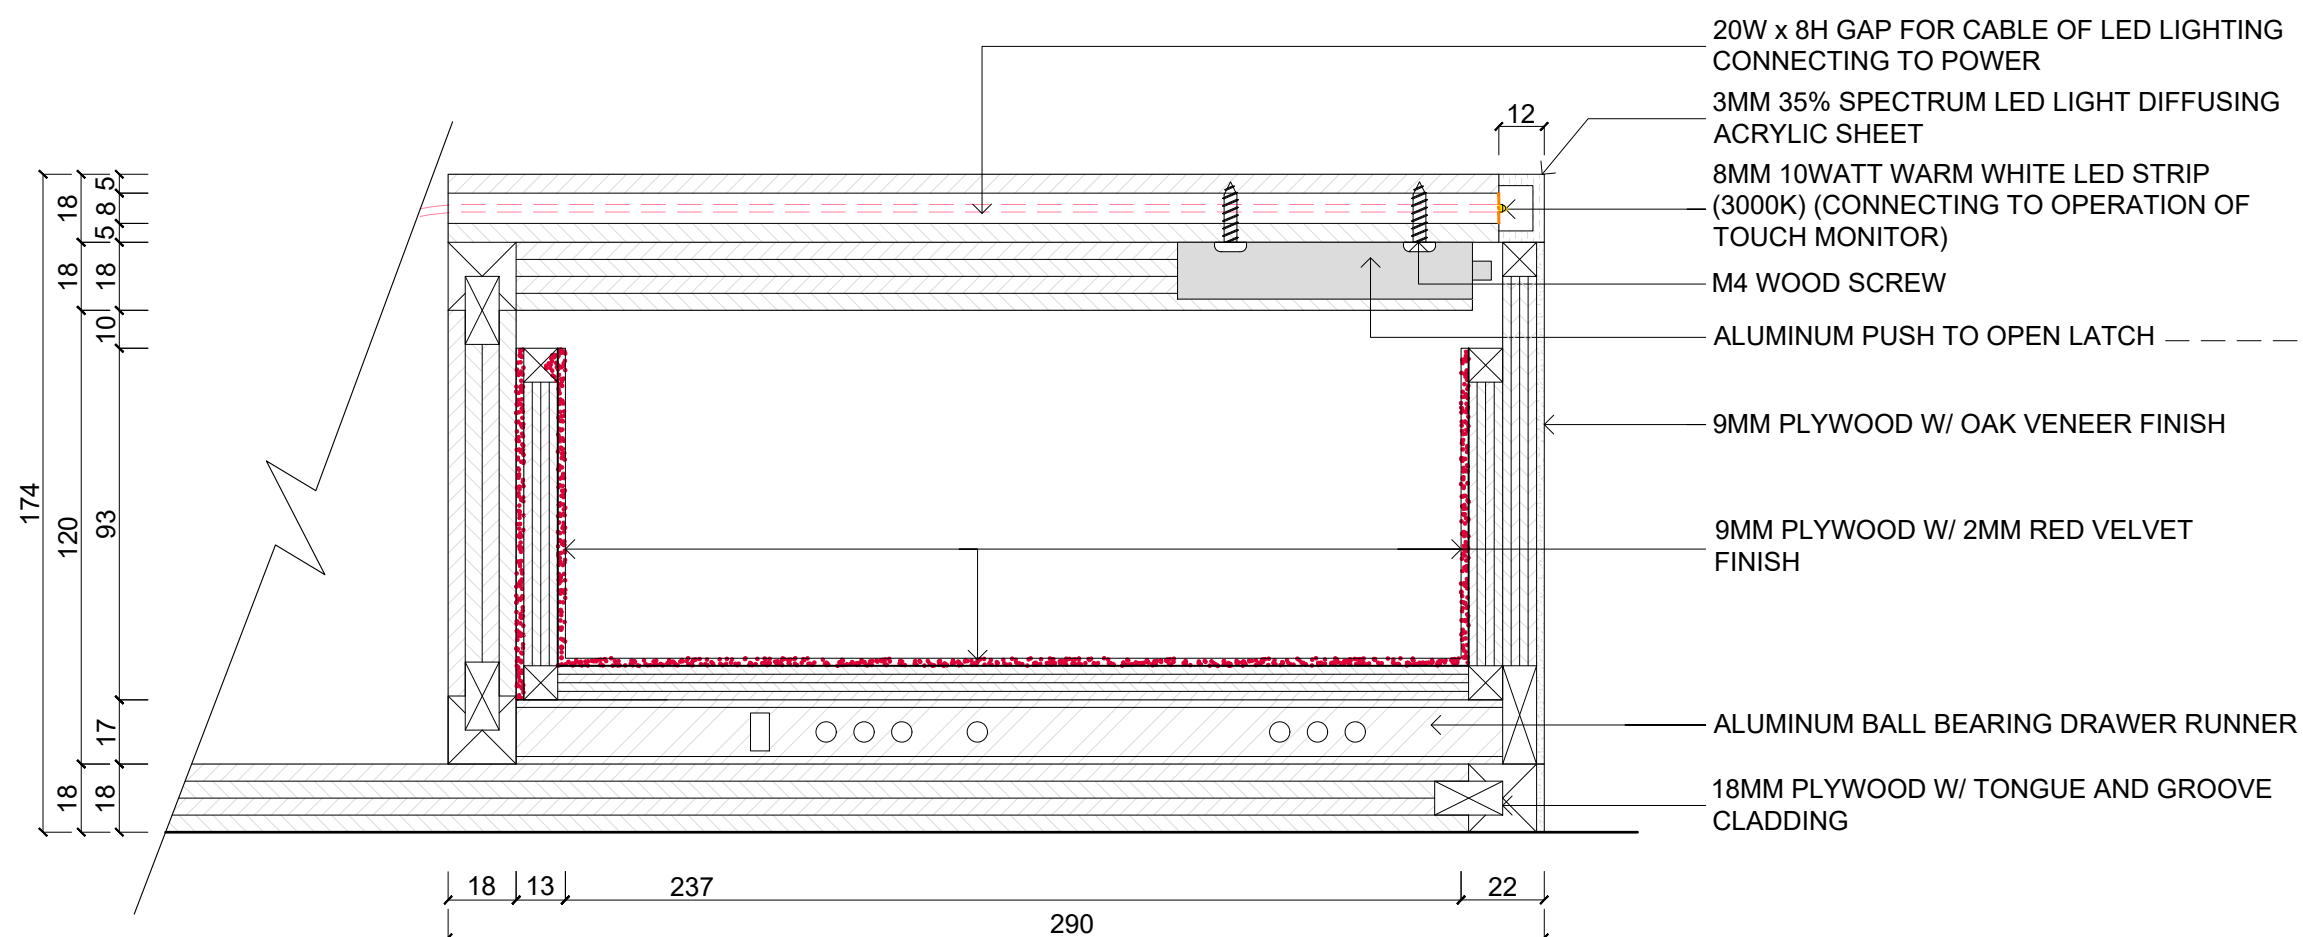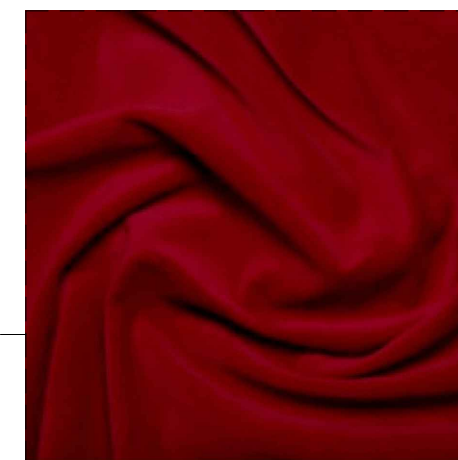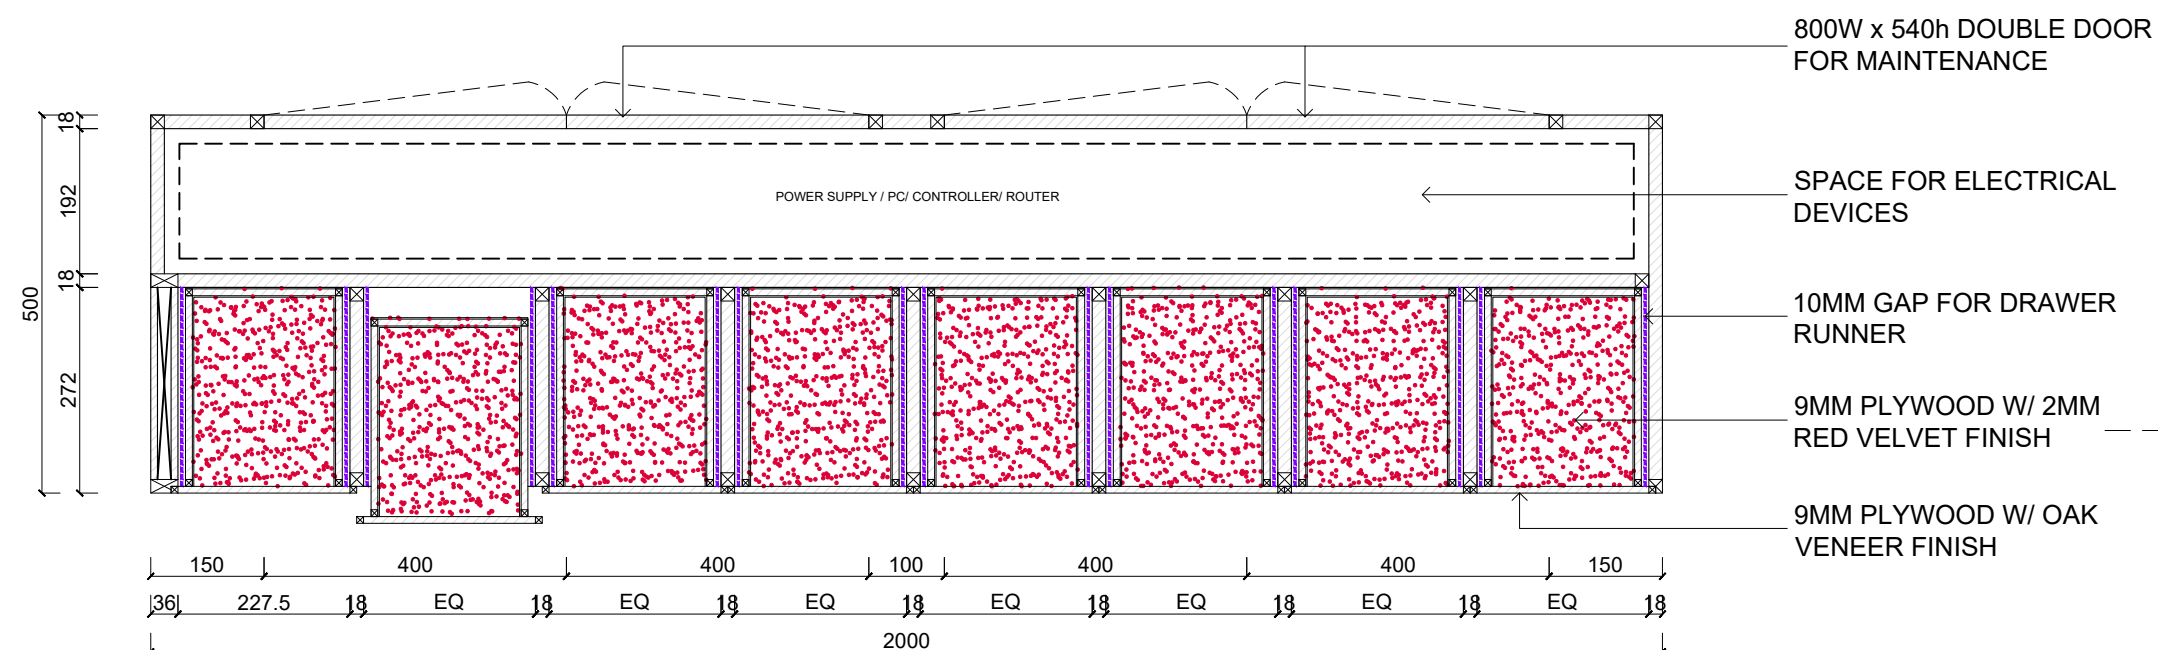

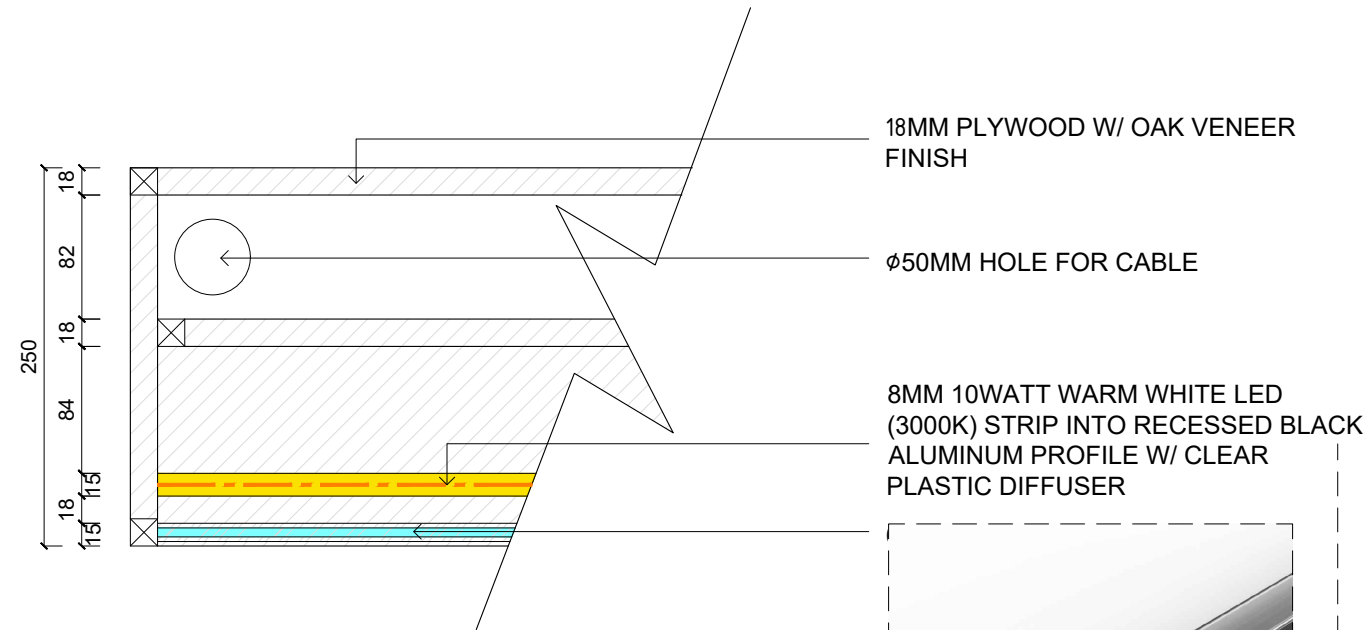

SECTION S-7
MATERIAL LIBRARY - DISPLAY WINDOW

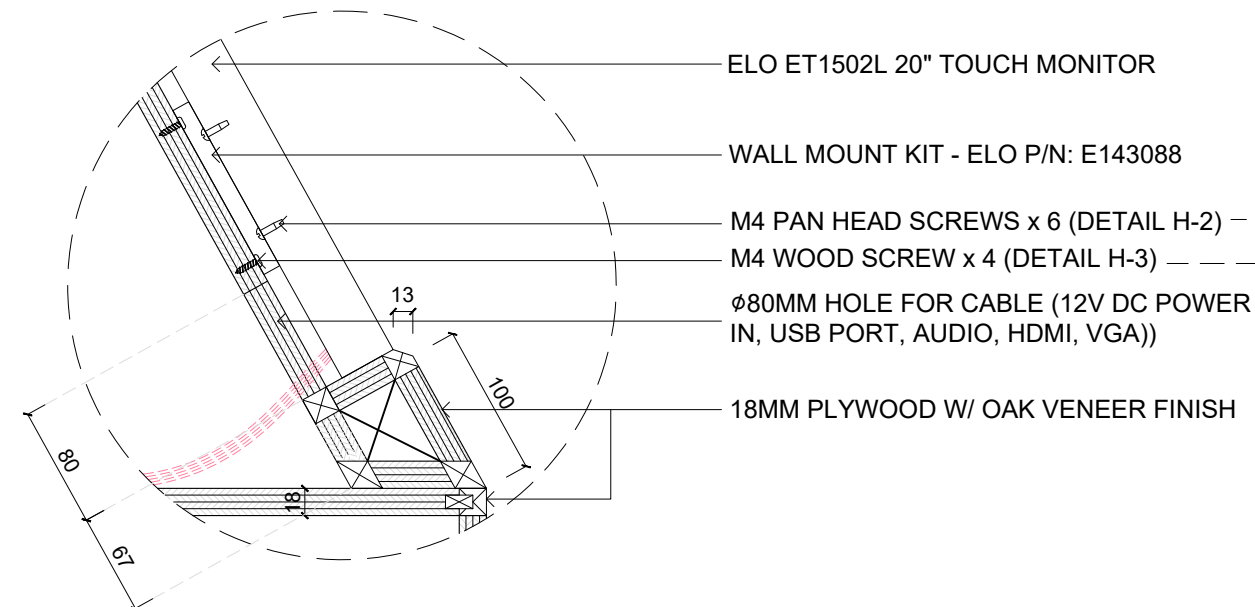

DETAIL H-1
TOUCH MONITOR


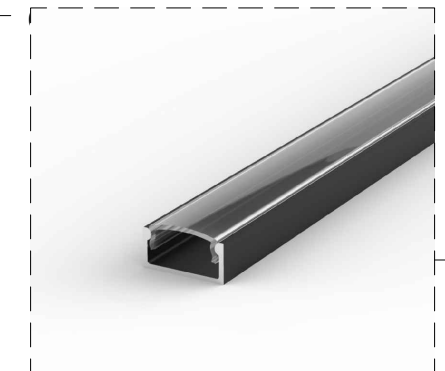



FIG. 13

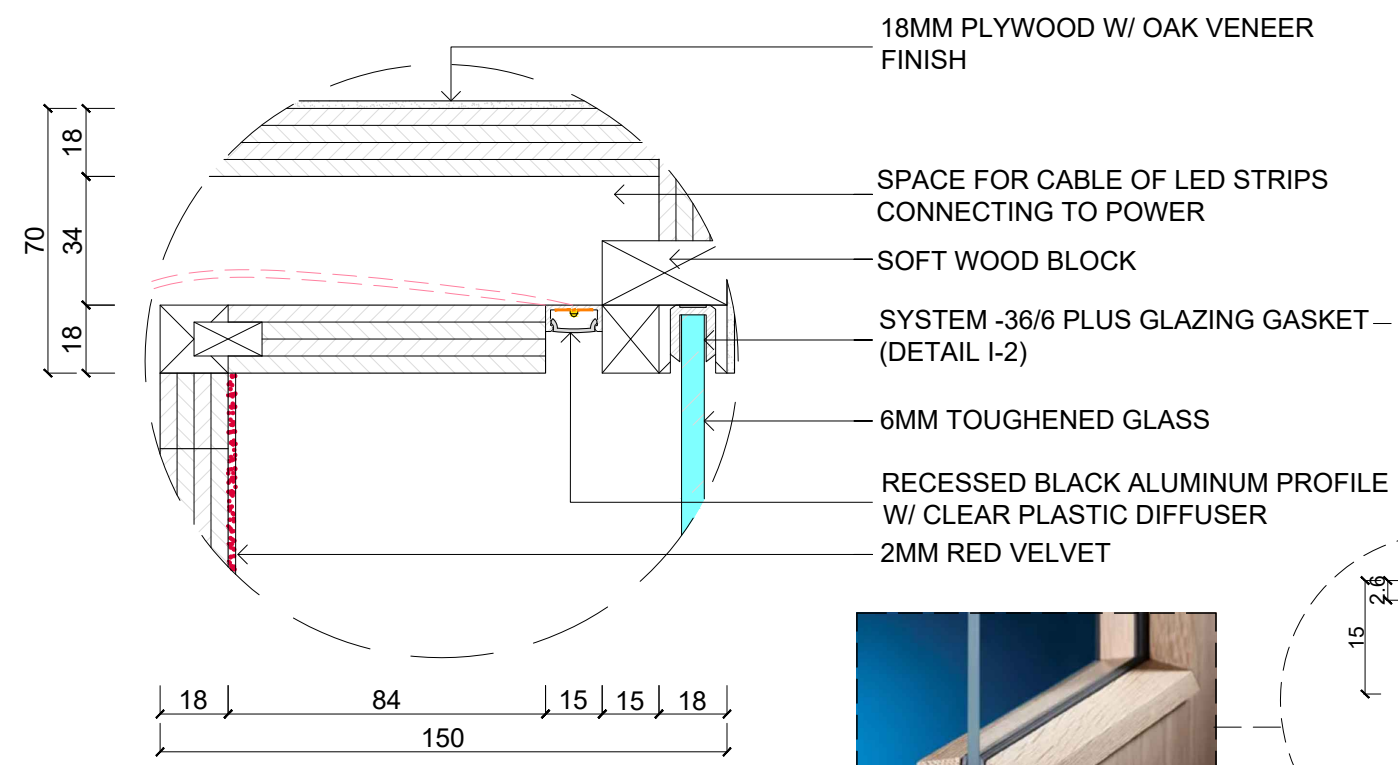

DETAIL I-1
DISPLAY WINDOW - LED LIGHTING



FIG. 14

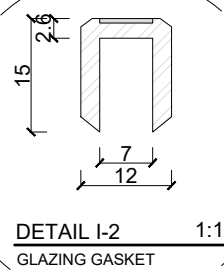

DETAIL I-2
GLAZING GASKET


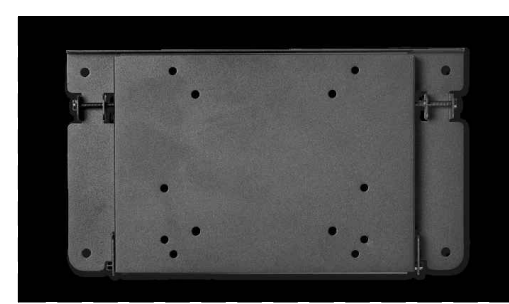


FIG. 15

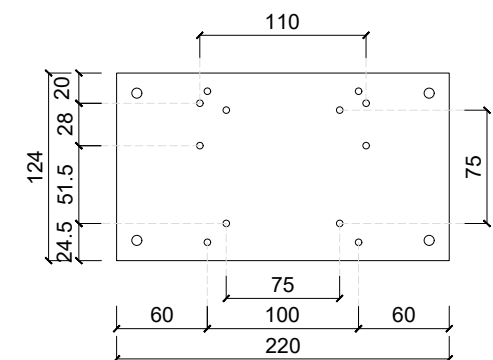

DETAIL H-2
WALL MOUNT KIT
(FRONT)




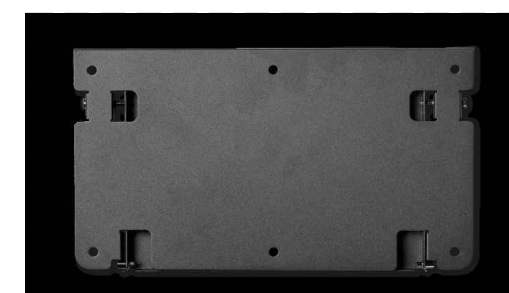



FIG. 16

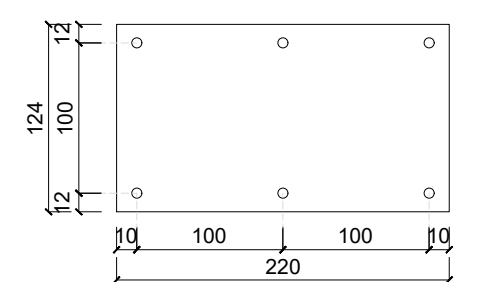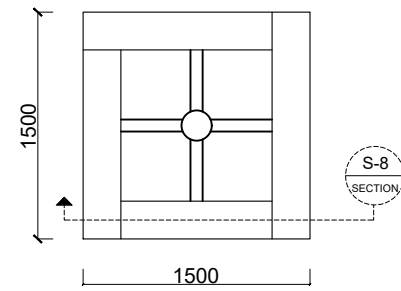


DETAIL H-3
WALL MOUNT KIT
(BACK)

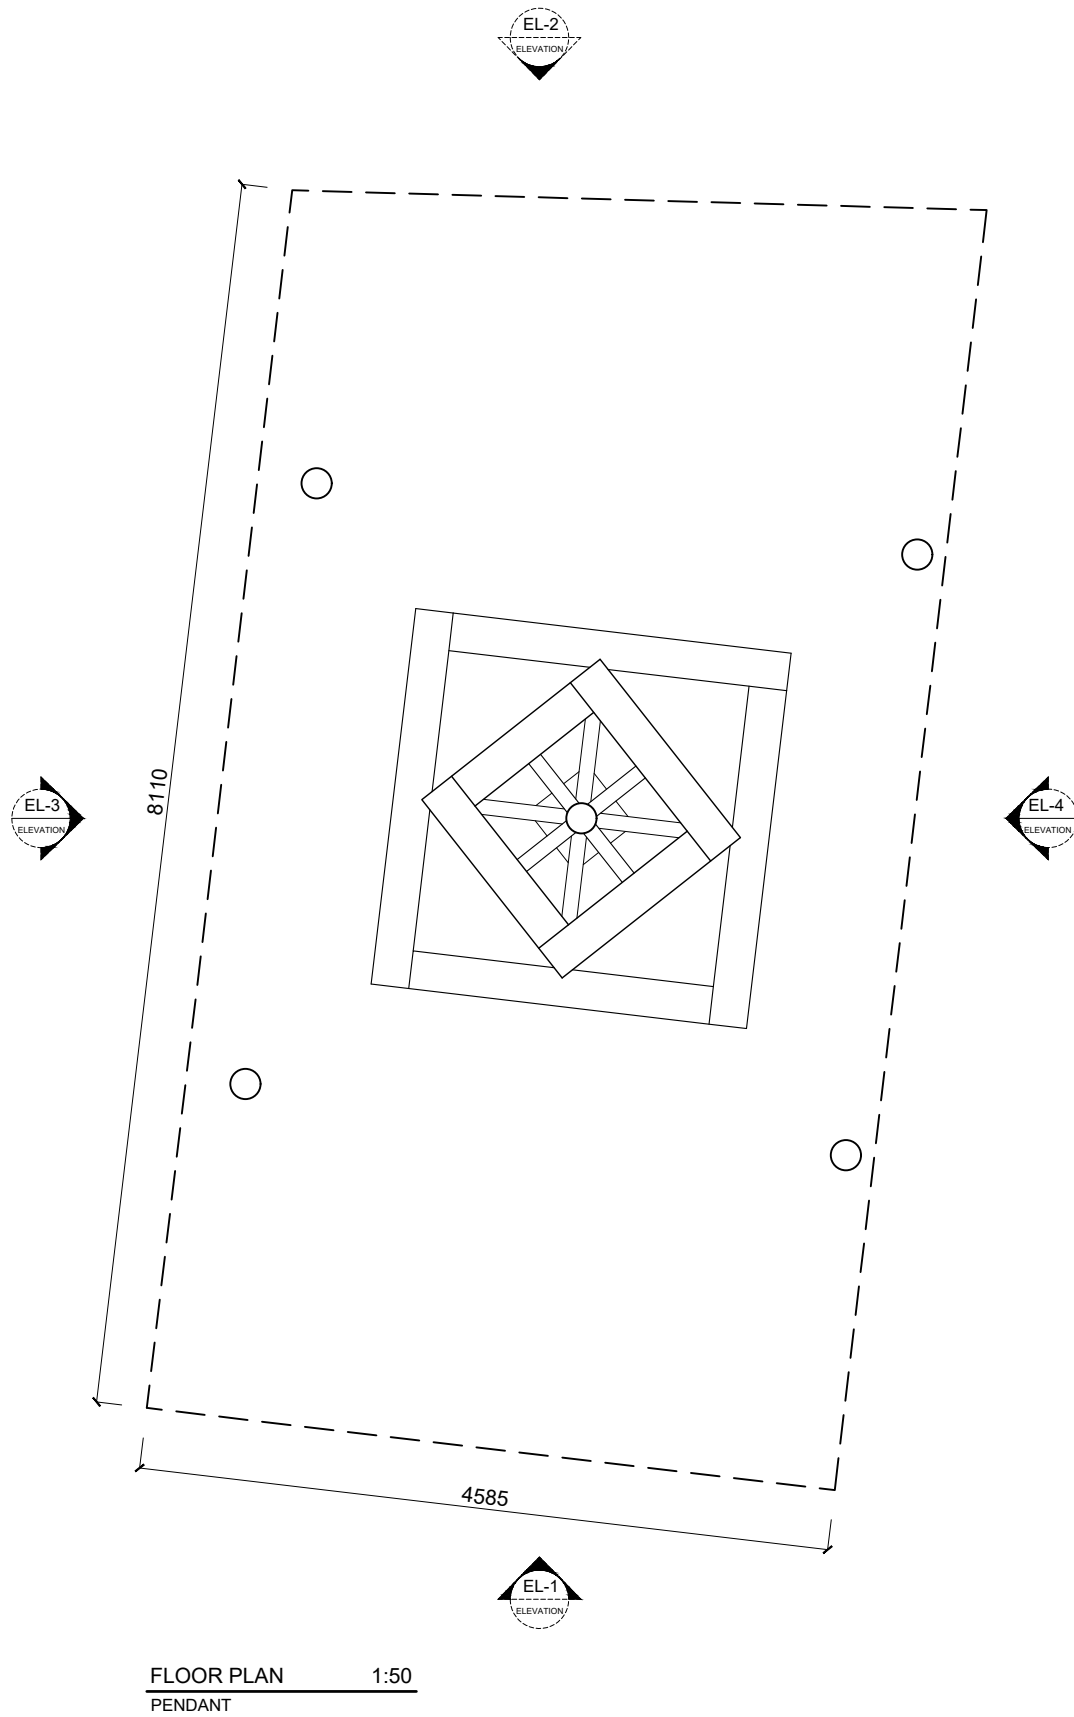



FLOOR PLAN 1:50
PENDANT (LV. 1)

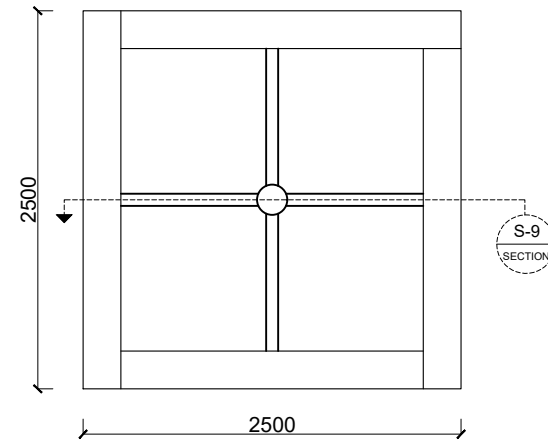

FLOOR PLAN 1:50
PENDANT (LV. 2)

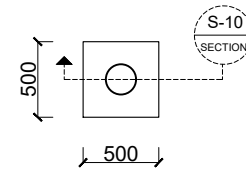

FLOOR PLAN 1:50
PENDANT (LV. 3)

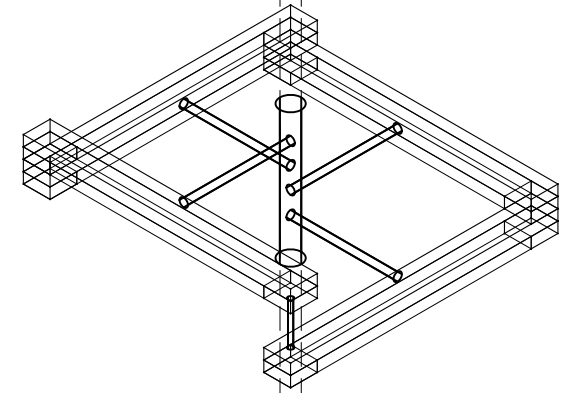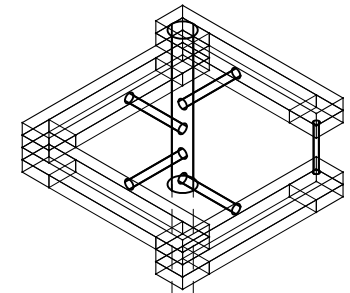

ISOMETRIC 1:50
PENDANT (LV. 3)

KS
Design

GENERAL NOTES

1. ALL DIMENSIONS ARE IN MILLIMETERS UNLESS OTHERWISE SPECIFIED.
2. DO NOT SCALE THE DRAWINGS.
3. ALL DIMENSIONS SHALL BE VERIFIED ON SITE WITH CONTRACTORS BEFORE PROCEEDING WORK.
4. ALL DESIGNS ARE PROPERTY OF SO PAK LING. NO REPRODUCTION IS PERMITTED WITHOUT CONSENT.

SPECIFIC NOTES

REVISION		
NO.	DATE	ISSUE

PROJECT TITLE
WHITECHAPEL HANDICRAFT LIBRARY

DRAWING TITLE
CUSTOMIZED PENDANT DETAILING

PROJECT NO.
FMP-01


DATE
19 MAR 2021

DRAWN BY
SO PAK LING

REVISION NO.
01


SCALE
1:50 (A3)

DRAWING NO.
DE-03-01

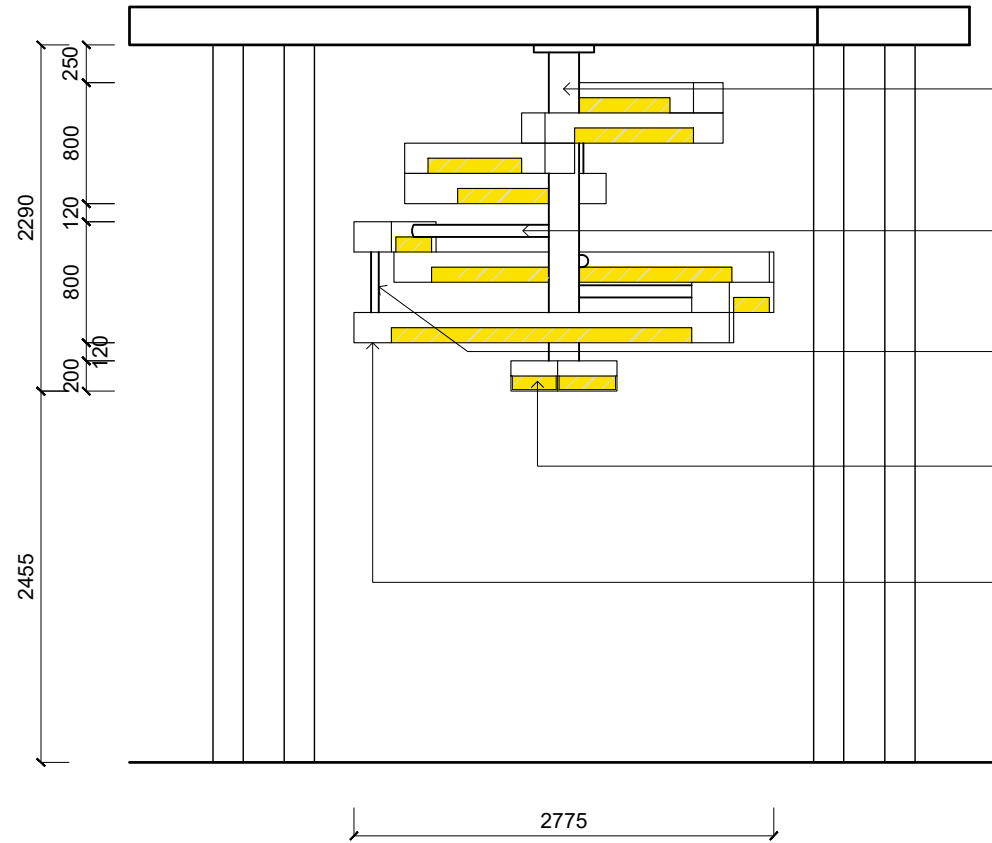


ELEVATION(EL-1) 1:50
PENDANT


- Ø200MM GUNMETAL MAIN COLUMN W/ BLACK SPRAY PAINT FINISH ATTACHED TO CEILING
- Ø80MM GUNMETAL TUBE W/ BLACK SPRAY PAINT FINISH CONNECTING LIGHT BOX TO MAIN COLUMN
- Ø50MM GUNMETAL COLUMN CONNECTING TWO LIGHT BOXES
- OLED LIGHTING W/ SATIN-FINISHED CLEAR GLASS CASE
- 20MM GUNMETAL PLATE

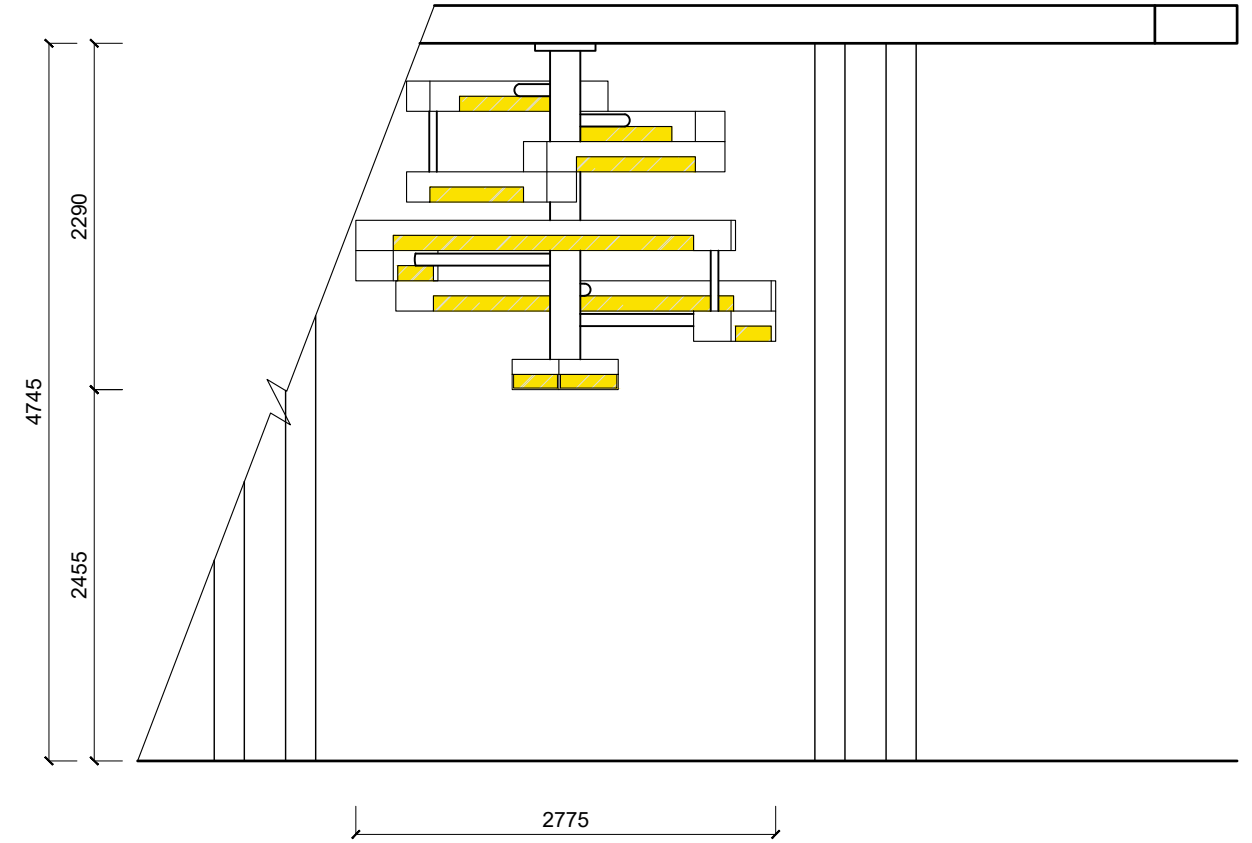

ELEVATION(EL-3) 1:50
PENDANT

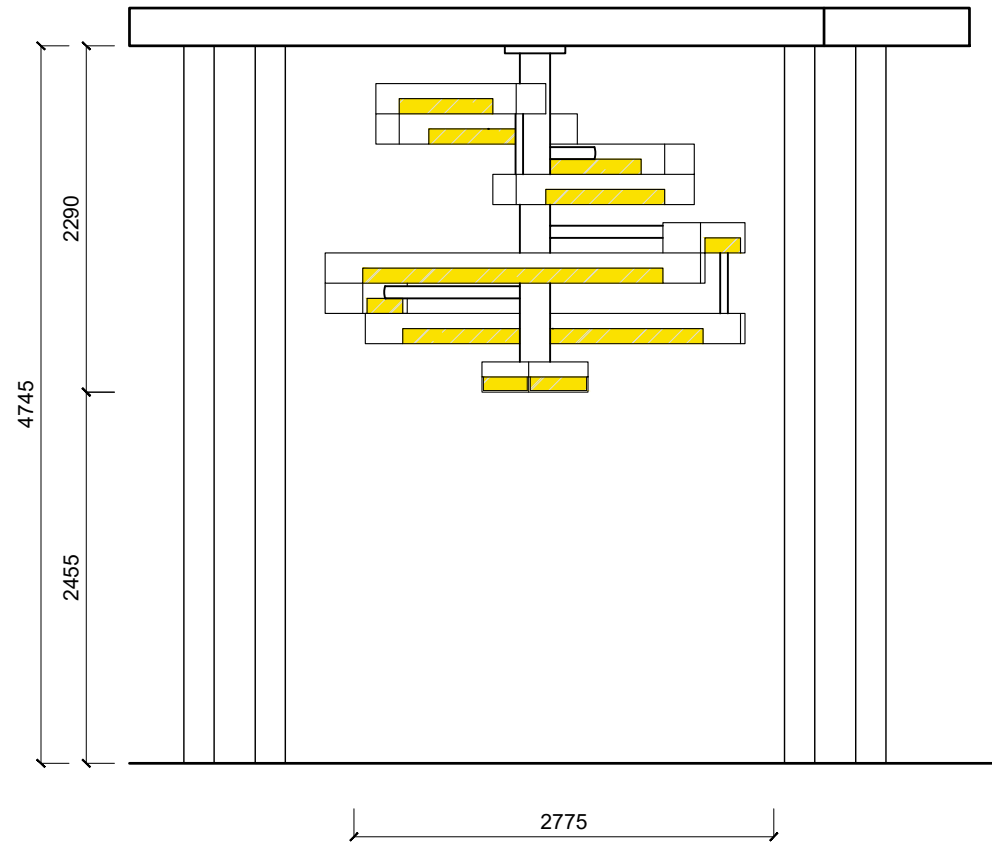

ELEVATION(EL-2) 1:50
PENDANT

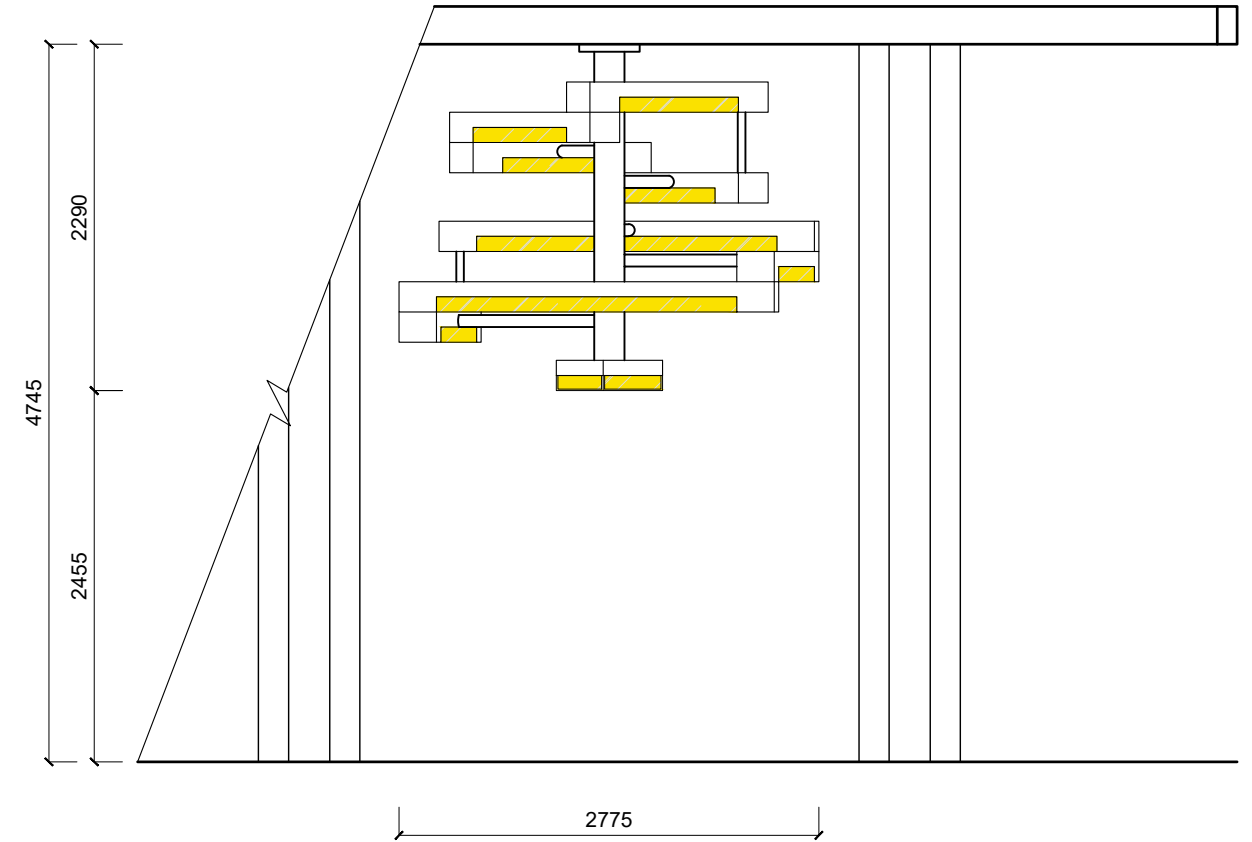

ELEVATION(EL-4) 1:50
PENDANT



- GENERAL NOTES
1. ALL DIMENSIONS ARE IN MILLIMETERS UNLESS OTHERWISE SPECIFIED.
 2. DO NOT SCALE THE DRAWINGS.
 3. ALL DIMENSIONS SHALL BE VERIFIED ON SITE WITH CONTRACTORS BEFORE PROCEEDING WORK.
 4. ALL DESIGNS ARE PROPERTY OF SO PAK LING. NO REPRODUCTION IS PERMITTED WITHOUT CONSENT.

SPECIFIC NOTES

REVISION		
NO.	DATE	ISSUE
01	19 MAR2021	PROPOSED DESIGN LAYOUT
02	14 APR 2021	UPDATED LAYOUT AS PER ADVICES

PROJECT TITLE
WHITECHAPEL HANDICRAFT LIBRARY

DRAWING TITLE
CUSTOMIZED PENDANT DETAILING

PROJECT NO.
FMP-01


DATE
14 APR 2021

DRAWN BY
SO PAK LING

REVISION NO.
02


SCALE
1:50 (A3)

DRAWING NO.
DE-03-02

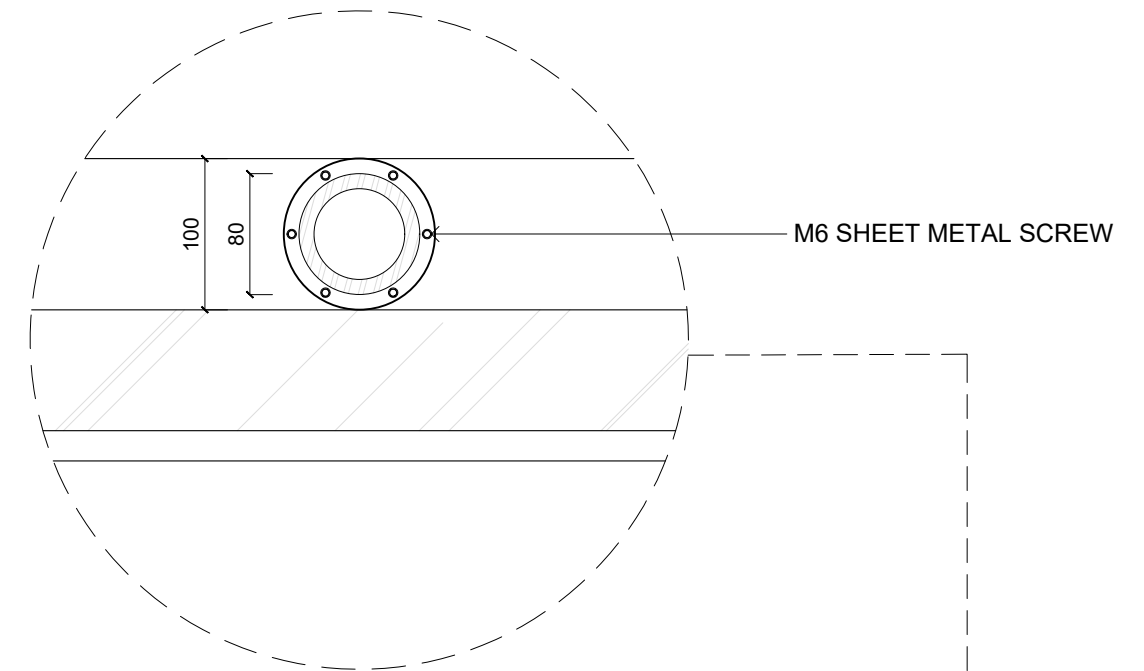


DETAIL J-2 1:5

COLUMN CONNECTING
TO LIGHT BOX

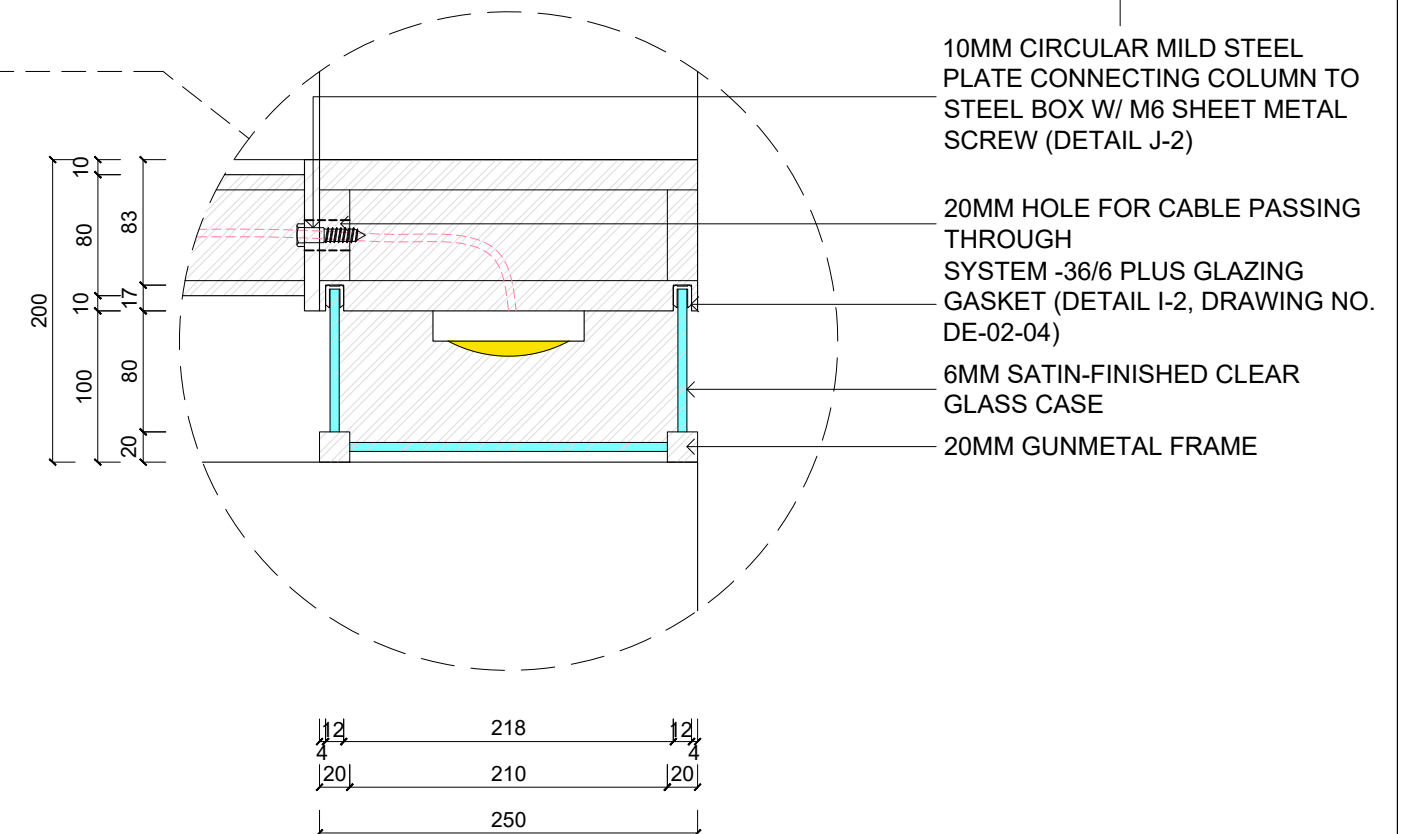

DETAIL J-1 1:5

PENDANT LIGHT BOX

 


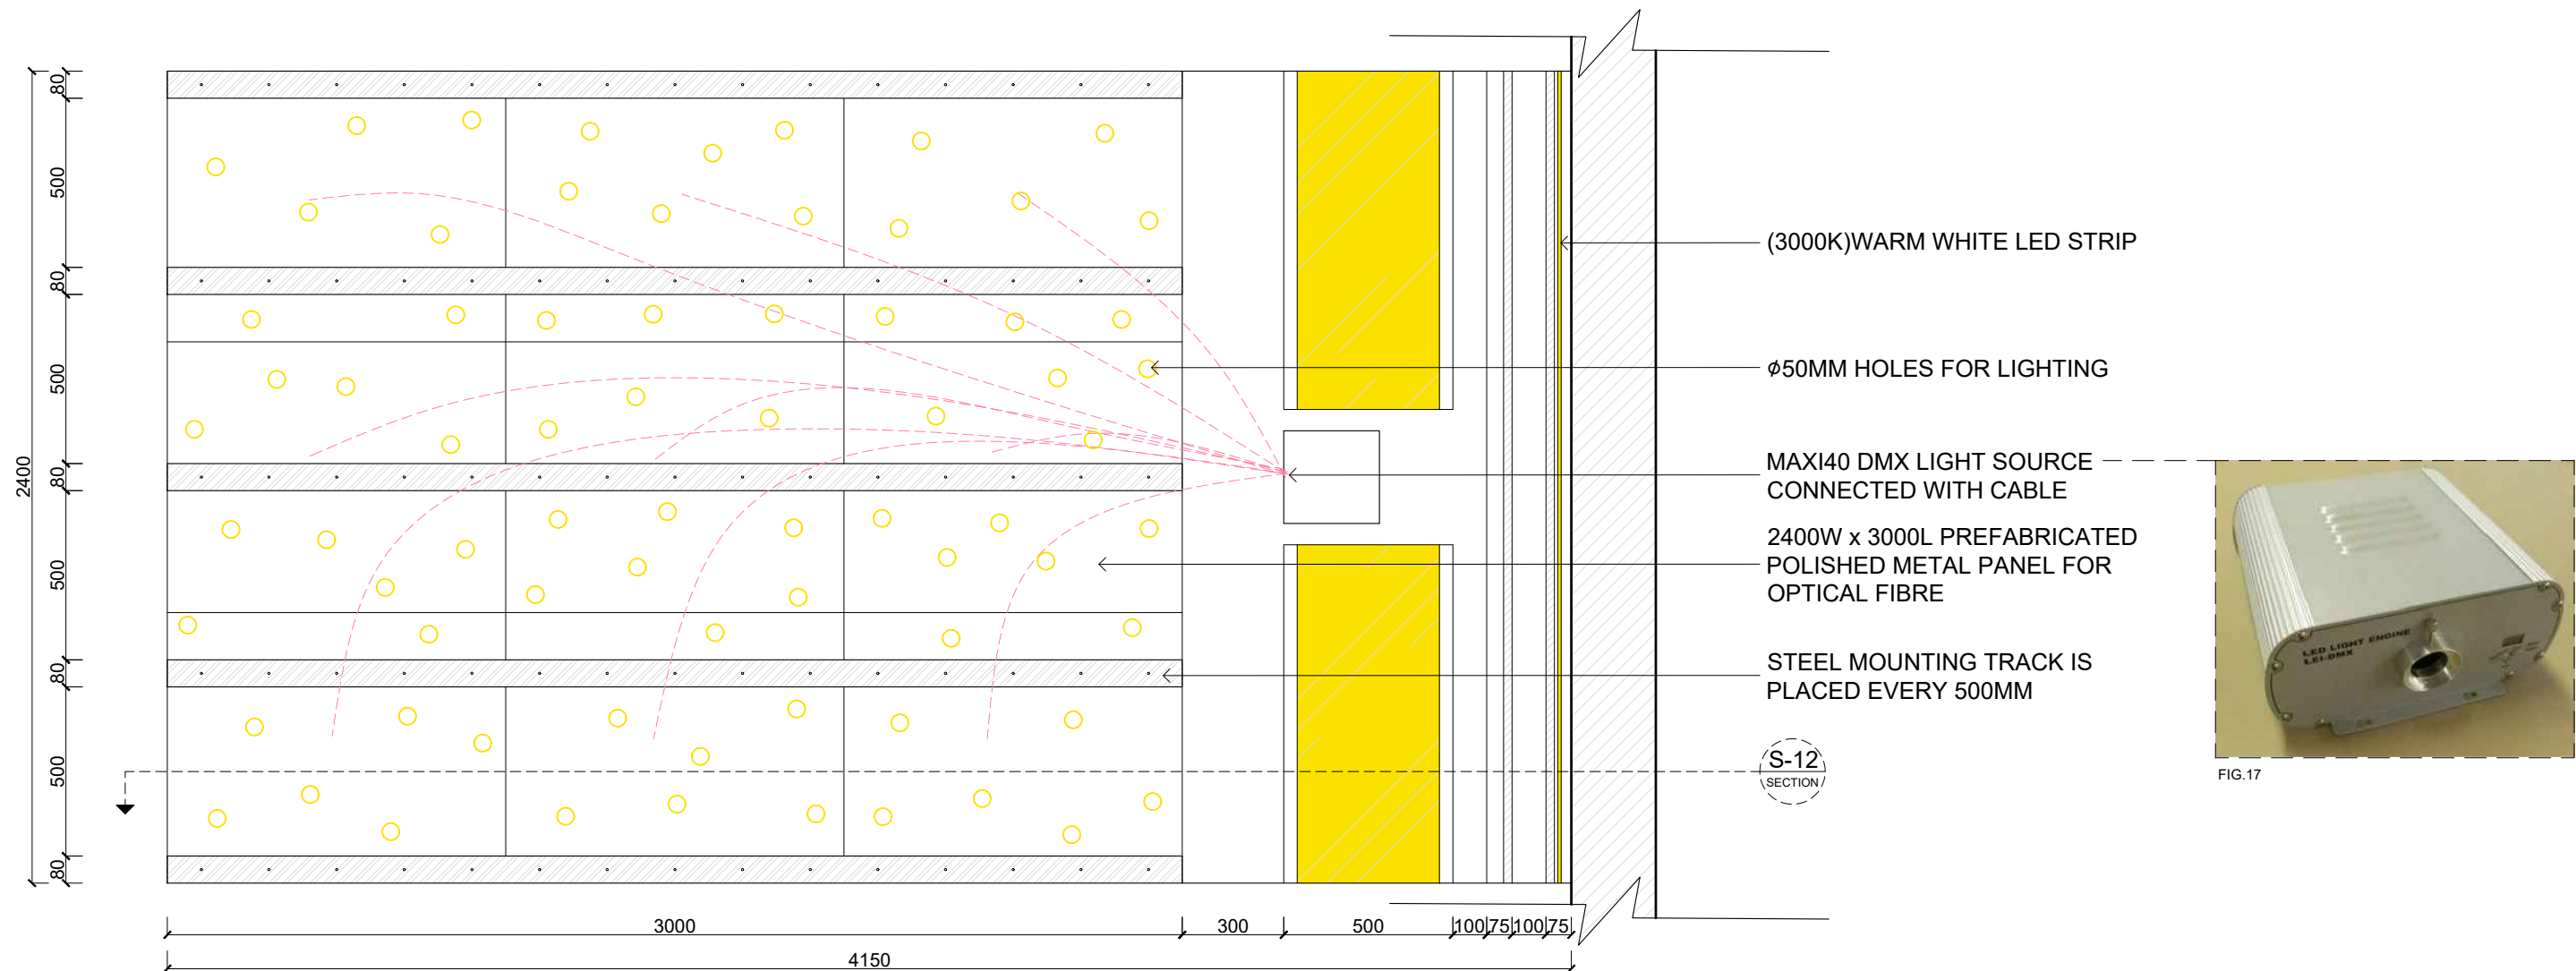


FIG. 17

SECTION S-11 1:20
FALSE CEILING

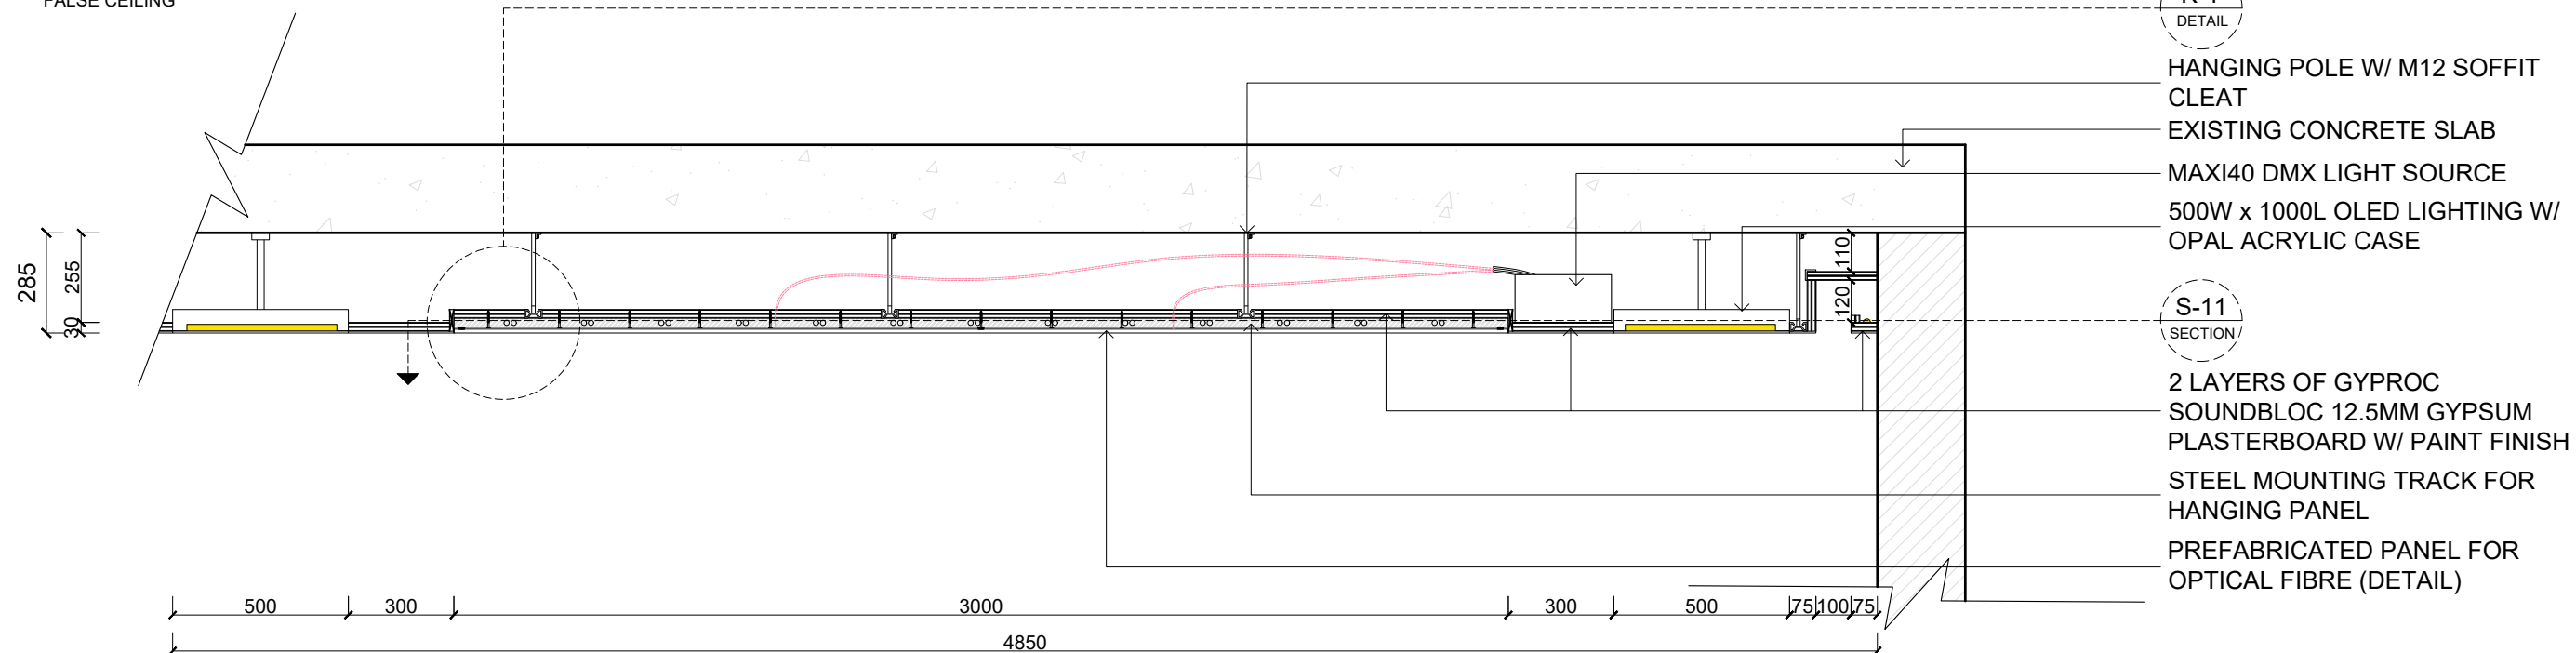

SECTION S-12 1:20
FALSE CEILING

KS
Design

GENERAL NOTES

1. ALL DIMENSIONS ARE IN MILLIMETERS UNLESS OTHERWISE SPECIFIED. DO NOT SCALE THE DRAWINGS.
2. ALL DIMENSIONS SHALL BE VERIFIED ON SITE WITH CONTRACTORS BEFORE PROCEEDING WORK.
3. ALL DESIGNS ARE PROPERTY OF SO PAK LING. NO REPRODUCTION IS PERMITTED WITHOUT CONSENT.

SPECIFIC NOTES

1. MATERIAL AND LOOSE FURNITURE ARE SUBJECT TO CHANGE UPON AVAILABILITY
- REFERENCE
FIG. 17 Staircase (2021) Maxi40 DMX light source [online] available from
<https://staircase-shop.mykaggle.com/collections/tire-optic-light-sources/products/maxi40-dmx-light-source> [06 March 2021]

REVISION

NO.	DATE	ISSUE
01	28 MAR 2021	PROPOSED DESIGN LAYOUT
02	18 APR 2021	UPDATED LAYOUT AS PER ADVICES

PROJECT TITLE

WHITECHAPEL HANDICRAFT LIBRARY

DRAWING TITLE

FALSE CEILING DETAILING

PROJECT NO.

FMP-01

DATE

18 APR 2021

DRAWN BY

SO PAK LING

REVISION NO.



02

SCALE

1:20 (A3)


DRAWING NO.

DE-04-01

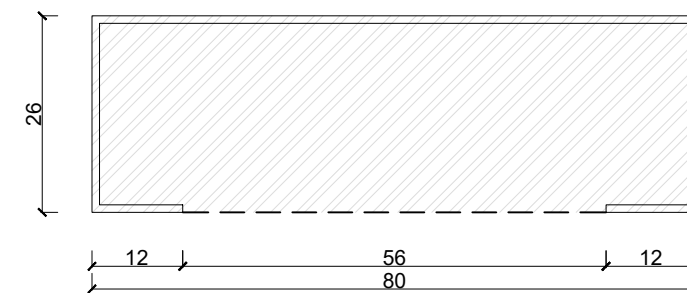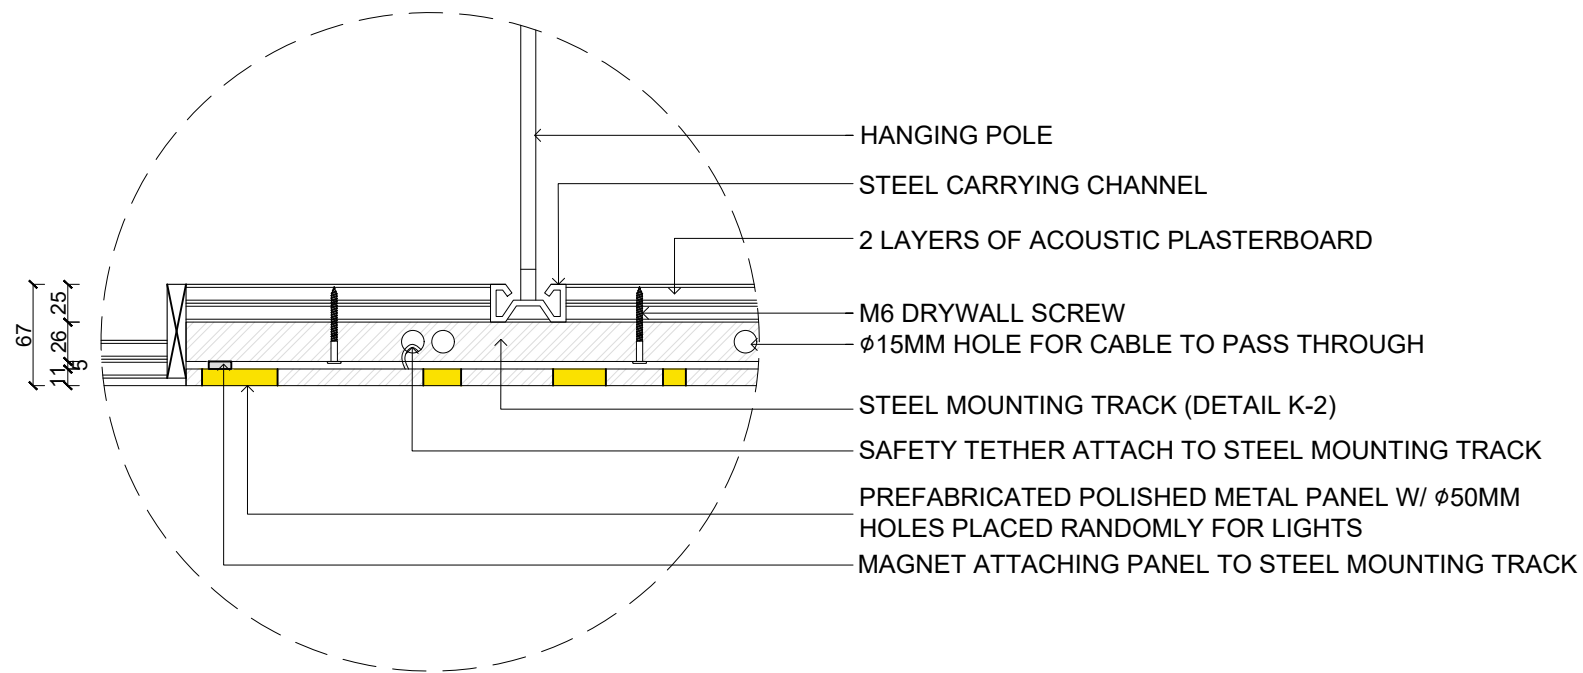

DETAIL K-2 1:1
STEEL MOUNTING TRACK SECTION

DETAIL K-1 1:2
OPTICAL FIBRE CEILING

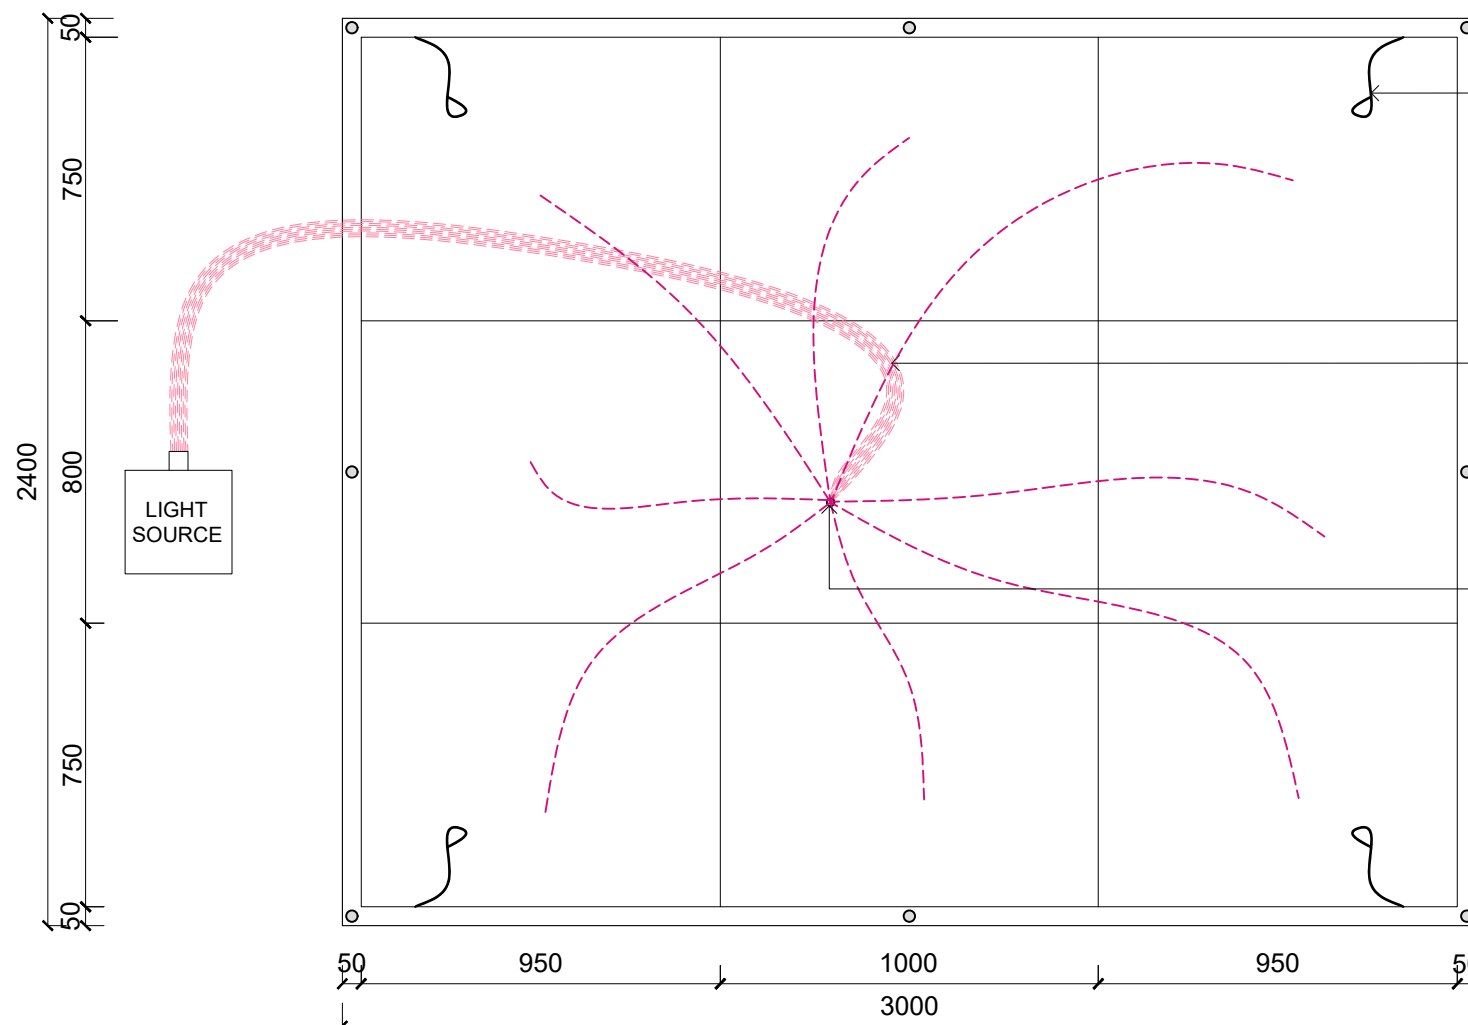

FLOOR PLAN 1:20
PREFABRICATED PANEL

KS

GENERAL NOTES

1. ALL DIMENSIONS ARE IN MILLIMETERS UNLESS OTHERWISE SPECIFIED.
2. DO NOT SCALE THE DRAWINGS.
3. ALL DIMENSIONS SHALL BE VERIFIED ON SITE WITH CONTRACTORS BEFORE PROCEEDING WORK.
4. ALL DESIGNS ARE PROPERTY OF SO PAK LING. NO REPRODUCTION IS PERMITTED WITHOUT CONSENT.

SPECIFIC NOTES

REVISION

NO.	DATE	ISSUE
01	28 MAR 2021	PROPOSED DESIGN LAYOUT
02	18 APR 2021	UPDATED LAYOUT AS PER ADVICES

PROJECT TITLE

WHITECHAPEL HANDICRAFT LIBRARY

DRAWING TITLE

FALSE CEILING DETAILING

PROJECT NO.

FMP-01

DATE

18 APR 2021

DRAWN BY

SO PAK LING

REVISION NO.

02

SCALE

AS SHOWN (A3)

DRAWING NO.

DE-04-02