

A3 TECHNICAL PACK

Project Title:

Sustainable Hotel

Location:


Al meydan road,Alquoz,
Dubai,United Arab Emirates

Drawn by: Bahareh Ghazi
BA Interior Architecture & Design
Coventry University, UK
Date: 30 April 2021


DRAWING LIST			
SHEET NO.	DRAWING NO.	DRAWING TITLE	SCALE
01	LP-01	Location plan	1:1250
02	SP-01	Site plan	1:500
03	FLP-01	Ground floor plan	1:50
04	FLP-02	First floor plan	1:50
05	FLP-03	second floor plan	1:50
06	FLP-04	Basement floor plan	1:50
07	FLP-05	Roof floor plan	1:50
08	EE-01	External elevation	1:50
09	SE-01	Section A-A	1:50
10	SE-02	Section B-B	1:50
11	SE-03	Section C-C	1:50
12	IE-01	Internal ELV - Lounge	1:50
13	IE-02	Internal ELV-Indoor garden	1:50
14	IE-03	Internal ELV-Conference room	1:50
15	IE-04	Internal ELV-Outdoor	1:50
16	RCP-01	Ground floor ceiling lighting plan	1:50
17	RCP-02	1st floor ceiling lighting plan	1:50
18	RCP-03	2nd floor ceiling lighting plan	1:50
19	RCP-04	Basement floor ceiling lighting plan	1:50
20	RCP-05	Roof floor ceiling lighting plan	1:50
21	DE-A01	Helical staircase	As shown
22	DE-A02	Helical staircase	As shown
23	DE-A03	Helical staircase	As shown
24	DE-A04	Helical staircase	As shown
25	DE-B01	Bedroom vertical garden	As shown
26	DE-B02	Bedroom vertical garden	As shown
27	DE-C01	Glass roof	As shown
28	DE-D01	Lounge wave screen	As shown
29	DE-D02	Lounge wave screen	As shown

Materials specification			
SYMBOL	DESCRIPTION	SPECIFICATION	LOCATION
PT	Tree	Palm tree	Level: G,1
VG	living wall	Vertical garden	Level: G,1,2
SH	Herb	Scent herbs	Level: G
TT	Tree	Traditional trees&plants	Level: G,1
FG	Glass	Frosted glass	Level: G,1,2
WT	water	Pool water	Level: G,1
EW	Wood	Walnut engineered wood -hardwood	Level: G,1,2
RP	Plaster	Off white rough plaster	Level: G,1,2
AW	Wood	American walnut	Level: G
SS	Metal	Black stainless steel	Level: G,1,R
WG	Glass	Window glass	Level: G,1,2,R
ST	Stone	Stone flooring	Level: G
AL	Metal	Brushed Aluminum	Level: G,R
TL	Tile	Ceramic tile	Level: G,1,2
MW	Wood	Maple wood	Level: 1
PF	Fiber	Beige Polyester fiber	Level: 1
LG	Glass	Laminate glass	Level: G,1,R
RM	Wood	Roman marble wood	Level: 1
CR	Carpet	Carpet	Level: G,1
AS	Asphalt	Gray asphalt	Level: B
CN	Concrete	Gray concrete	Level: R

Lighting specification			
SYMBOL	DESCRIPTION	SPECIFICATION	LOCATION
	Lighting	Day light	Level: G,1,2,R
	Lighting	High frequency light	Level: B
	Lighting	Recessed spot light	Level:B,G,1,2,R
	Lighting	Feature light	Level: G,1
	Lighting	Plant growing light	Level: G,1,2
	Lighting	Suspended light pendent	Level: G,1,2
	Lighting	Chandelier	Level: G
	Lighting	Wall mounted light	Level: G,1,2
	Lighting	Spot light	Level: G,1
	Lighting	LED strip light	Level: G,1
	Lighting	Floor spot light	Level: G,1,2,R

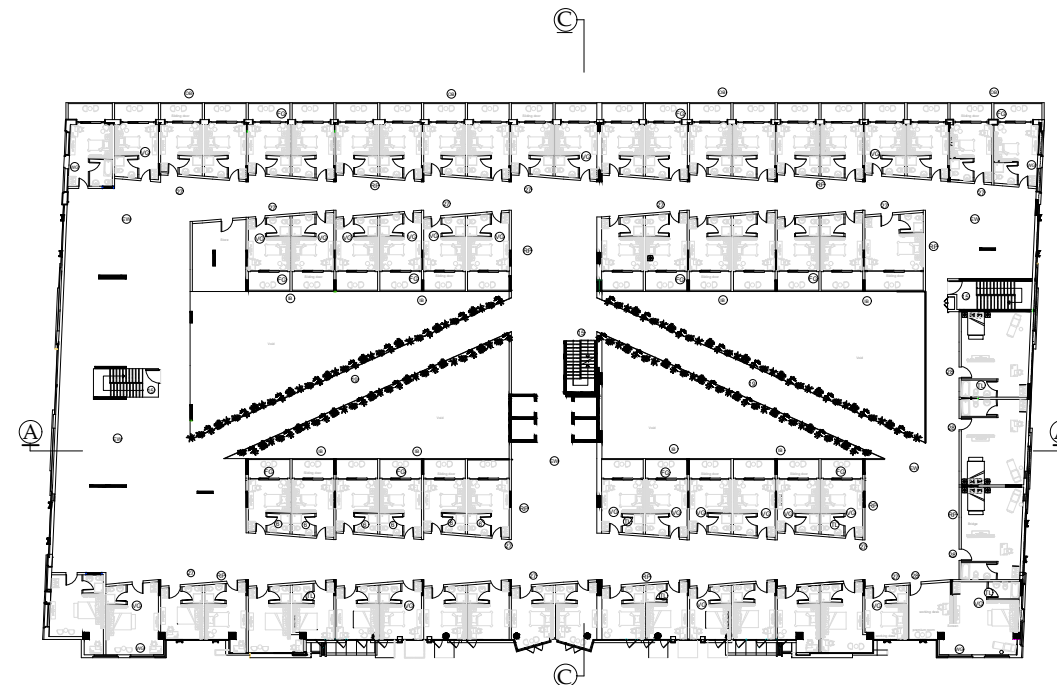

LEGEND	
	Toilet
	Staircase
	Bridge
	Standard room
	Premium room
	Indoor balcony
	Outdoor balcony
	Vertical garden
	Frosted glass
	Walnut engineered wood-hardwood
	Rough plaster
	Woodless glass

 

Project title :
Sustainable Hotel
Dubai, UAE

Drawn by :
Bahareh Ghazi



Drawing title:
Second floor plan


Drawing NO:
FLP- 03

Model code:
3001AAD


Scale :
As shown

Sheet size:	A3
-------------	----

Date :	30/04/2021
--------	------------

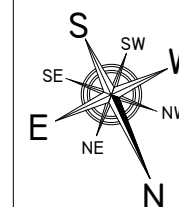

Notes :

 


Sustainable Hotel
Dubai, UAE

Bahareh Ghazi





Model code:
3001AAD



Date :
30/04/2021

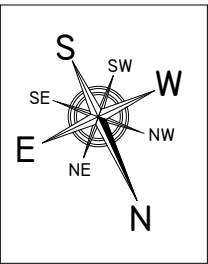

Notes :

 

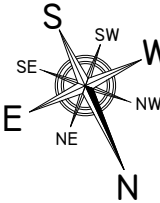	Project title : Sustainable Hotel Dubai, UAE	Drawn by : Bahareh Ghazi		Drawing title: Section A-A Drawing NO: SE - 01 Model code: 3001AAD	Scale : As shown Sheet size: A3 Date : 30/04/2021		Notes :
---	--	--	---	--	---	---	----------------

 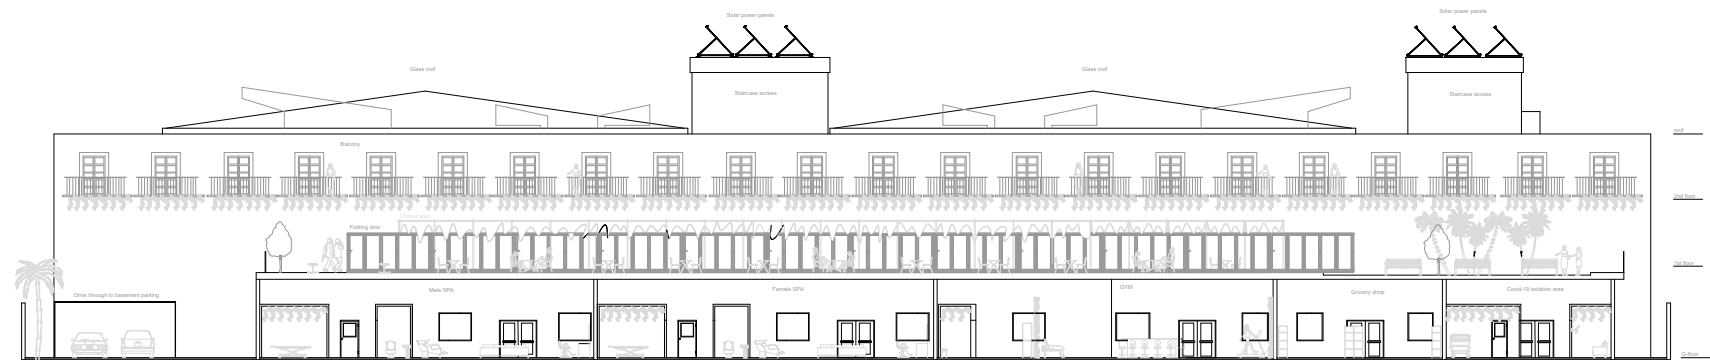

Project title :
Sustainable Hotel
Dubai, UAE

Drawn by :
Bahareh Ghazi



Drawing title:
Section B-B


Drawing NO:
SE- 02

Model code:
3001AAD



Scale :
As shown

Sheet size:
A3

Date :
30/04/2021

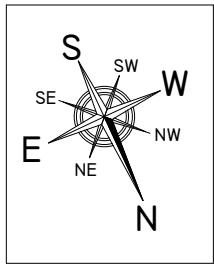

Notes :

 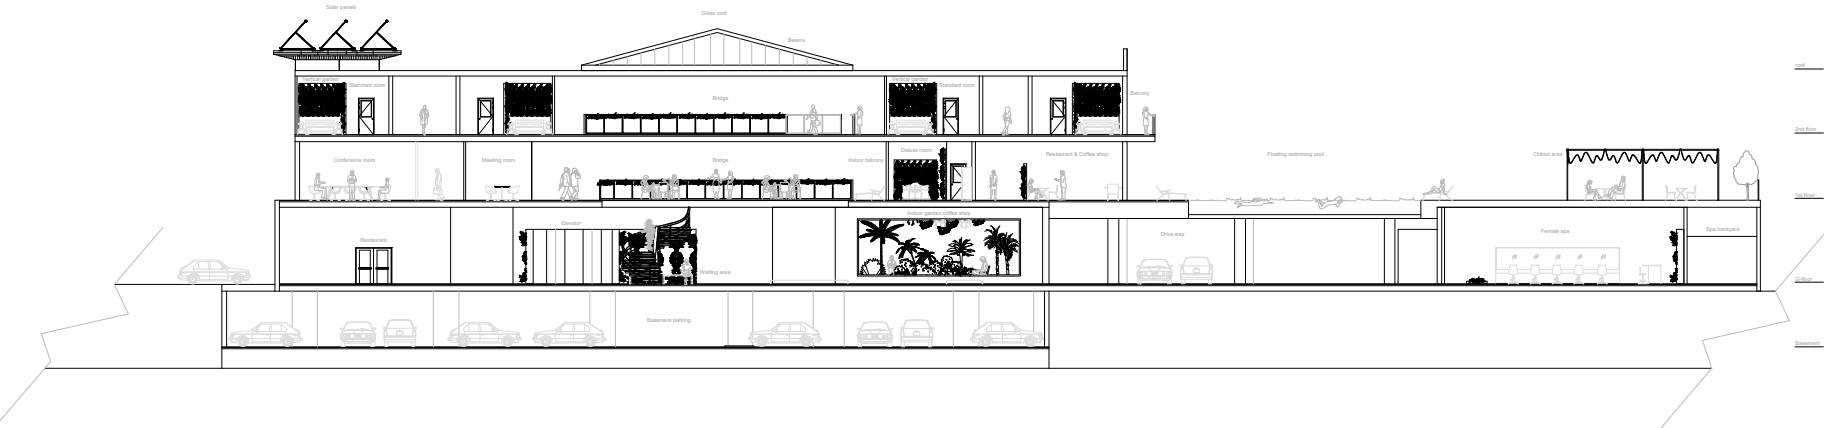

Project title :
Sustainable Hotel
Dubai, UAE

Drawn by :
Bahareh Ghazi



Drawing title:
Section C-C


Drawing NO:
SE - 03

Model code:
3001AAD

Scale :
As shown

Sheet size:
A3

Date :
30/04/2021

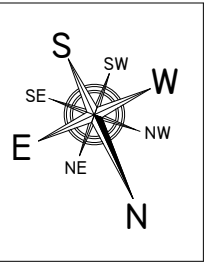

Notes :