


Project title :
Sustainable Hotel
Dubai, UAE

Drawn by :
Bahareh Ghazi





Drawing title:
Business lounge internal
elevation
Drawing NO:
IE - 01
Model code:
3001AAD


Scale :
As shown
Sheet size:
A3
Date :
30/04/2021

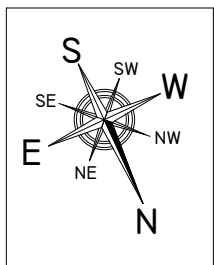

Notes :

 

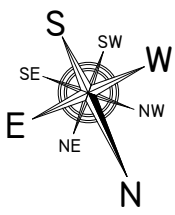	Project title : Sustainable Hotel Dubai, UAE	Drawn by : Bahareh Ghazi		Drawing title: Indoor garden internal elevation Drawing NO: IE - 02 Model code: 3001AAD	Scale : As shown Sheet size: A3 Date : 30/04/2021		Notes :
---	--	--	---	--	--	---	----------------

 

Project title :
Sustainable Hotel
Dubai, UAE

Drawn by :
Bahareh Ghazi




Drawing title:
Outdoor area internal
elevation
Drawing NO:
IE - 04

Model code:
3001AAD

Scale :
As shown



Sheet size:
A3

Date :
30/04/2021

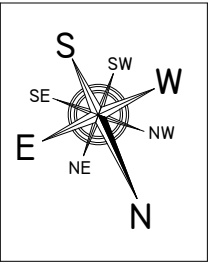



Notes :


LEGEND	
SYMBOL	DESCRIPTION
	DAY LIGHT
	HIGH FREQUENCY LIGHT
	RECESSED SPOT LIGHT
	FEATURE LIGHT
	PLANT GROWING LIGHT
	SUSPENDED LIGHT PENDANT
	CHANDELIER
	WALL MOUNTED LIGHT
	SPOT LIGHT
	LED STRIP LIGHT
	FLOOR SPOT LIGHT

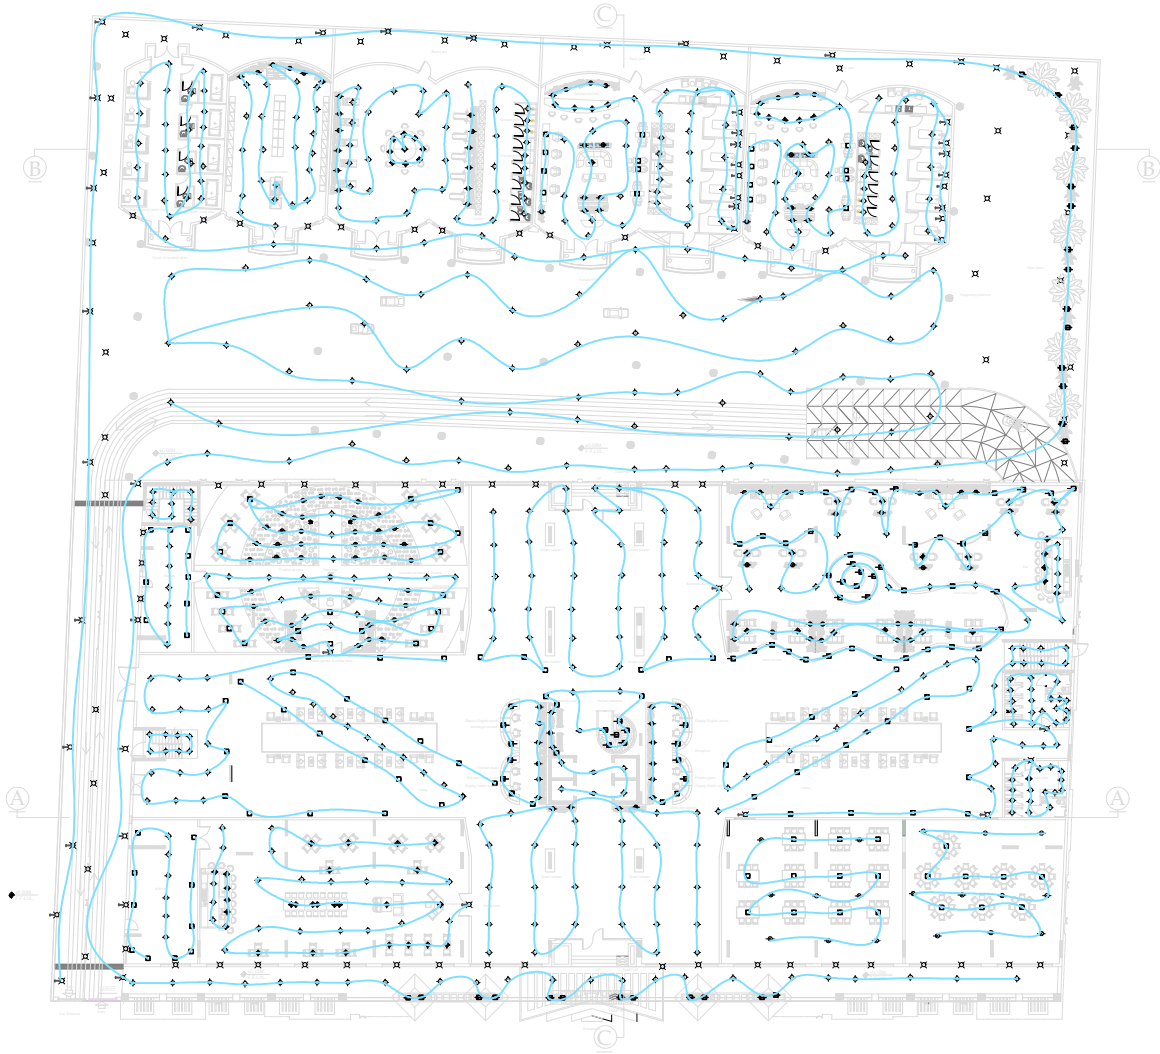 



	Project title :	Drawn by :		Drawing title:	Scale :		Notes :
	Sustainable Hotel Dubai, UAE	Bahareh Ghazi		Ground floor lighting plan	As shown		
				Drawing NO: RCP-01	Sheet size: A3		
				Model code: 3001AAD	Date : 30/04/2021		

LEGEND	
SYMBOL	DESCRIPTION
	DAY LIGHT
	HIGH FREQUENCY LIGHT
	RECESSED SPOT LIGHT
	FEATURE LIGHT
	PLANT GROWING LIGHT
	SUSPENDED LIGHT PENDANT
	CHANDELIER
	WALL MOUNTED LIGHT
	SPOT LIGHT
	LED STRIP LIGHT
	FLOOR SPOT LIGHT

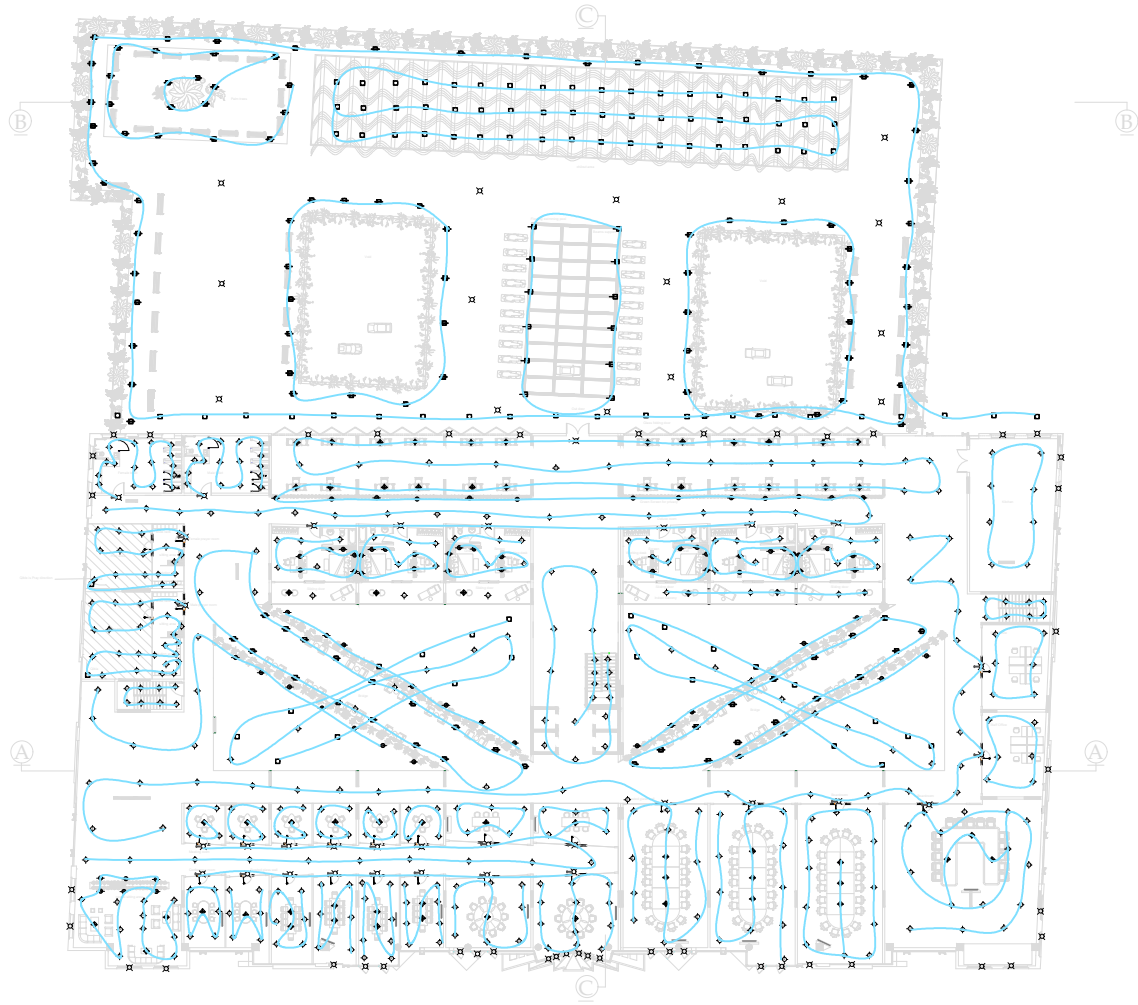 

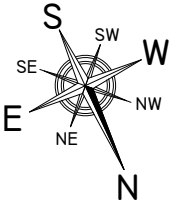	Project title :	Drawn by :		Drawing title: First floor lighting plan	Scale : As shown		Notes :
	Sustainable Hotel Dubai, UAE	Bahareh Ghazi		Drawing NO: RCP-02	Sheet size: A3		
				Model code: 3001AAD	Date : 30/04/2021		

LEGEND	
SYMBOL	DESCRIPTION
	DAY LIGHT
	HIGH FREQUENCY LIGHT
	RECESSED SPOT LIGHT
	FEATURE LIGHT
	PLANT GROWING LIGHT
	SUSPENDED LIGHT PENDANT
	CHANDELIER
	WALL MOUNTED LIGHT
	SPOT LIGHT
	LED STRIP LIGHT
	FLOOR SPOT LIGHT

 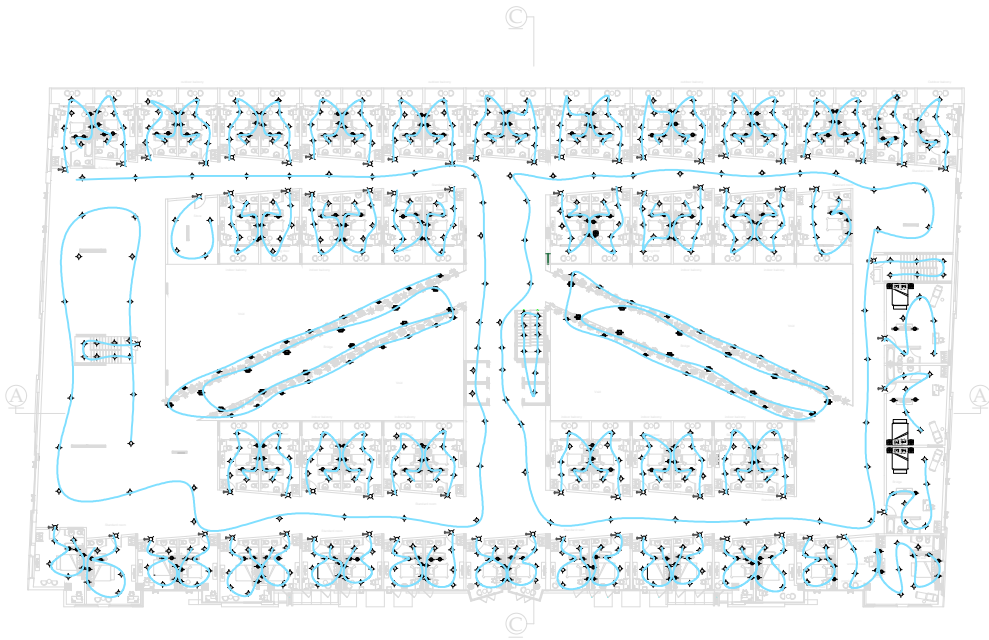



	Project title :	Drawn by :		Drawing title:	Scale :		Notes :
	Sustainable Hotel Dubai, UAE	Bahareh Ghazi		Second floor lighting plan	As shown		
				Drawing NO: RCP-03	Sheet size: A3		
				Model code: 3001AAD	Date : 30/04/2021		

LEGEND	
SYMBOL	DESCRIPTION
	DAY LIGHT
	HIGH FREQUENCY LIGHT
	RECESSED SPOT LIGHT
	FEATURE LIGHT
	PLANT GROWING LIGHT
	SUSPENDED LIGHT PENDANT
	CHANDELIER
	WALL MOUNTED LIGHT
	SPOT LIGHT
	LED STRIP LIGHT
	FLOOR SPOT LIGHT





Recessed spot light - Bronze

 High frequency light - white

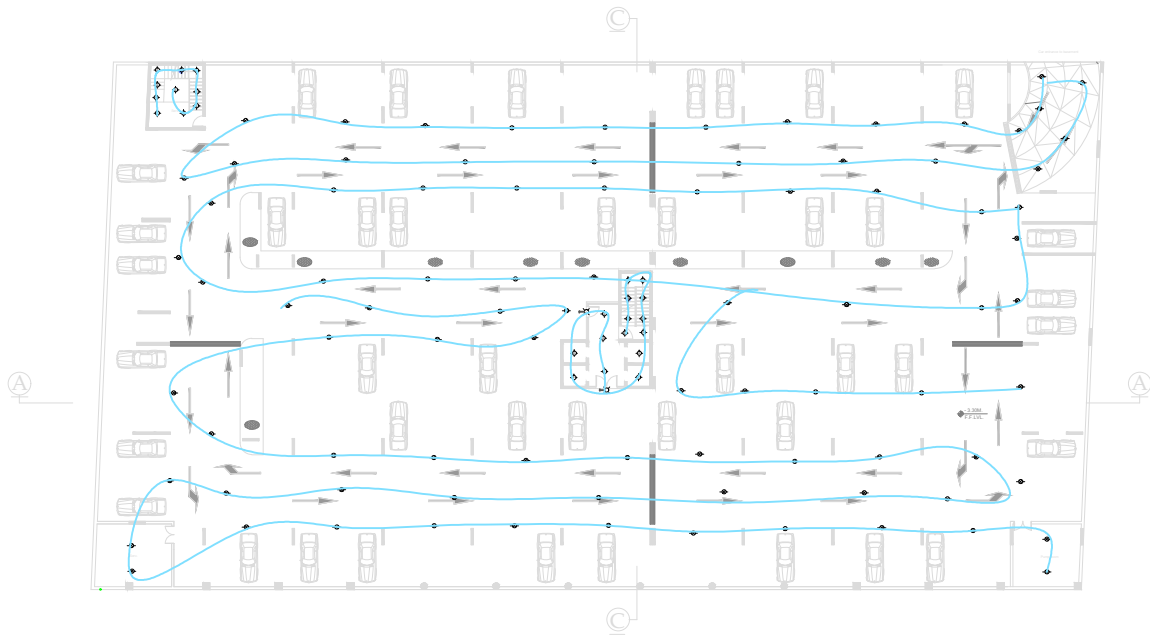

	Project title :	Drawn by :		Drawing title:	Scale :		Notes :
	Sustainable Hotel Dubai, UAE	Bahareh Ghazi		Basement lighting plan	As shown		
				Drawing NO: RCP-04	Sheet size: A3		
				Model code: 3001AAD	Date : 30/04/2021		

LEGEND	
SYMBOL	DESCRIPTION
	DAY LIGHT
	HIGH FREQUENCY LIGHT
	RECESSED SPOT LIGHT
	FEATURE LIGHT
	PLANT GROWING LIGHT
	SUSPENDED LIGHT PENDANT
	CHANDELIER
	WALL MOUNTED LIGHT
	SPOT LIGHT
	LED STRIP LIGHT
	FLOOR SPOT LIGHT

 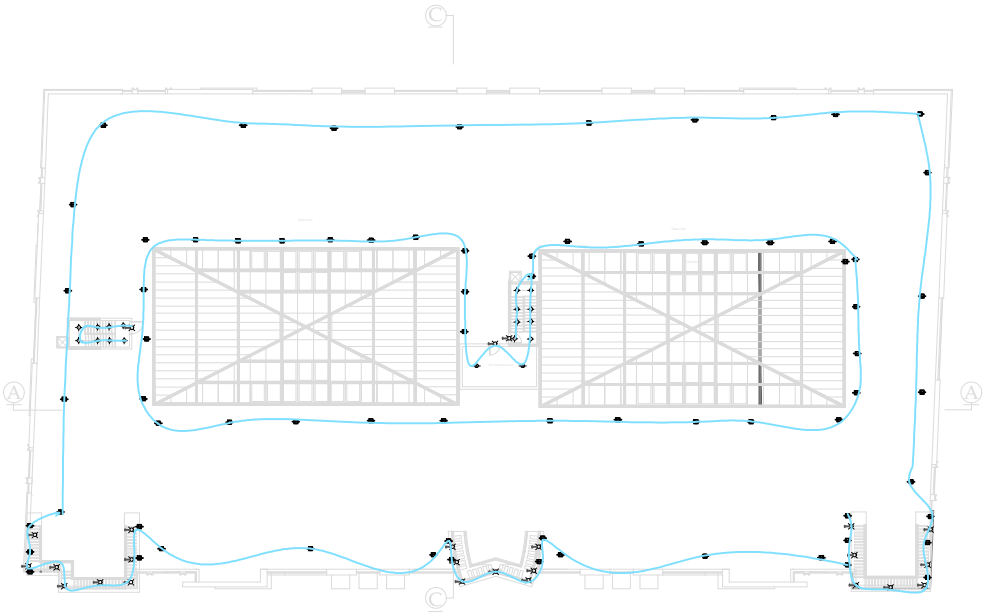

	Project title :	Drawn by :		Drawing title:	Scale :		Notes :
	Sustainable Hotel Dubai, UAE	Bahareh Ghazi		Drawing NO: RCP-05	Sheet size: A3		
				Model code: 3001AAD	Date : 30/04/2021		