

A3 TECHNICAL PACK

PROJECT TITLE:

ZONE | COWORKING SPACE AND RENT OUT STUDIO

LOCATION:

45 VYNER STREET, LONDON, UNITED KINGDOM E2 9DQ

DATE: 28 APRIL 2021

PREPARED BY: TERRENCE, YUN CHUNG LIN

SCHOOL: COVENTRY UNIVERSITY

DRAWING LIST

SHEET NO.	DRAWING NO.	DRAWING TITLE	SCALE	REV 01	REV 02
01	S - 01	DRAWING LIST	N.T.S		
02	S - 02	MATERIAL SPESIFICATION	N.T.S		
03	SM - 01	LOCATION PLAN	1 : 1250		
04	SM - 02	SITE PLAN	1 : 500		
05	FLP - 00	BASEMENT PROPOSED LAYOUT PLAN	1 : 125		
06	FLP - 01	GROUND FLOOR PROPOSED LAYOUT PLAN	1 : 125		
07	FLP - 02	1ST FLOOR PROPOSED LAYOUT PLAN	1 : 125		
08	FLP - 03	2ND FLOOR PROPOSED LAYOUT PLAN	1 : 125		
09	FLP - 04	R00FTOP PROPOSED LAYOUT PLAN	1 : 125		
10	EE - 01	EXTERIOR ELEVATION A	1 : 100		
11	SE - 01	SECTION ELEVATION A-A	1 : 100		
12	SE - 02	SECTION ELEVATION B-B	1 : 100		
13	LP - 00	BASEMENT PROPOSED LIGHTING PLAN	1 : 125		
14	LP - 01	GROUND FLOOR PROPOSED LIGHTING PLAN	1 : 125		

NOTE: ALL DIMENSIONS ARE IN MILLIMETERS, UNLESS OTHERWISE STADED. SO NOT SCALE DIRECT FROM DRAWINGS. ALL DIMENSIONS TO BE VERIFIED WHEN IN DOUBT. CONTRACTOR SHALL BE RESPONSIBLE TO VERIFY DIMENSION AT SITE WHERE REQUIRED.	PROJECT: ZONE AT 45 VYNER STREET, LONDON E2 9DQ	SCALE: N.T.S	DATE: APRL 2021
	DRAWING TITLE: DRAWING LIST		
	DRAWN BY: TERRENCE, YUN CHUNG LIN	JOB NO: 01	DRAWING NO: S-01

DRAWING LIST

15	LP - 02	1ST FLOOR PROPOSED LIGHTING PLAN	1 : 125		
16	LP - 03	2ND FLOOR PROPOSED LIGHTING PLAN	1 : 125		
17	LP - 04	ROOFTOP PROPOSED LIGHTING PLAN	1 : 125		
18	DE - 01	DOUBLE GLAZED FLAT SKYLIGH ROOF DETAILING	AS SHOWN		
19	DE - 02	WOOD DIVIDER DETAILING	AS SHOWN		
20	DE - 03	GROUND FLOOR STAIR HANDRAIL DETAILING	AS SHOWN		
21	DE - 04	CENTER LIGHT DETAILING	AS SHOWN		

 
NOTE: ALL DIMENSIONS ARE IN MILLIMETERS, UNLESS OTHERWISE STADED. SO NOT SCALE DIRECT FROM DRAWINGS. ALL DIMENSIONS TO BE VERIFIED WHEN IN DOUBT. CONTRACTOR SHALL BE RESPONSIBLE TO VERIFY DIMENSION AT SITE WHERE REQUIRED.	PROJECT: ZONE AT 45 VYNER STREET, LONDON E2 9DQ	SCALE: N.T.S	DATE: APRL 2021
	DRAWING TITLE: DRAWING LIST		
	DRAWN BY: TERRENCE, YUN CHUNG LIN	JOB NO: 01	DRAWING NO: S-01

MATERIAL SPESIFICATION

SYMBOL	DESCRIPTION	SPECIFICATION	SUPPLIES	LOCATION	REMARKS
GL - 01	GLASS	DOUBLE GLAZED GLASS	CONTRACTOR	LEVEL 1,R	SAMPLE REQUIRED FOR APPROVAL
GL - 02	GLASS	5MM GLASS	CONTRACTOR	LEVEL B,0,1,2,R	SAMPLE REQUIRED FOR APPROVAL
ME - 01	METAL	WHITE POWDER COATED STEEL	THE METAL STORE UK	LEVEL 0,1	SAMPLE REQUIRED FOR APPROVAL
ME - 02	METAL	SILVER METAL	THE METAL STORE UK	LEVEL B,0,1,2,R	SAMPLE REQUIRED FOR APPROVAL
KT	CERAMIC TILES	MATT SUBWAY WHITE TILE	DIESPEKER AND CO	LEVEL B,2,	SAMPLE REQUIRED FOR APPROVAL
LM - 01	LAMINATE	CHEPSTOW PLANED GRAY OAK	WOODPECKER FLOORING	LEVEL B,0	SAMPLE REQUIRED FOR APPROVAL
LM - 02	LAMINATE	BRECON GLACIAL OAK	WOODPECKER FLOORING	LEVEL B,0,1,2	SAMPLE REQUIRED FOR APPROVAL
PT - 01	PAINT	PRETTY PALE (WHITE)	VALSPAR PAINTING	LEVEL B,0,1,2,R	SAMPLE REQUIRED FOR APPROVAL
SW - 01	TIMBER	WOOD DIVIDER (PLYWOOD BATTEN)	HARDWOODS GROUP	LEVEL B,0,1,2	SAMPLE REQUIRED FOR APPROVAL
SW - 02	TIMBER	CENTER LIGHT STRUCTURE (OAK WOOD BATTEN)	HARDWOODS GROUP	LEVEL 1	SAMPLE REQUIRED FOR APPROVAL
CF	CONCRETE	POLISHED CONCRETE FLOORING	WOODPECKER FLOORING	LEVEL B,0,1,2	SAMPLE REQUIRED FOR APPROVAL
TA - 01	TERRAZZO	TERRAZZO TILES (TE114)	DIESPEKER AND CO	LEVEL B,1	SAMPLE REQUIRED FOR APPROVAL
TA - 02	TERRAZZO	TERRAZZO TILES (TE007)	DIESPEKER AND CO	LEVEL 0,1	SAMPLE REQUIRED FOR APPROVAL

NOTE: ALL DIMENSIONS ARE IN MILLIMETERS, UNLESS OTHERWISE STADED. SO NOT SCALE DIRECT FROM DRAWINGS. ALL DIMENSIONS TO BE VERIFIED WHEN IN DOUBT. CONTRACTOR SHALL BE RESPONSIBLE TO VERIFY DIMENSION AT SITE WHERE REQUIRED.	PROJECT: ZONE AT 45 VYNER STREET, LONDON E2 9DQ	SCALE: N.T.S	DATE: APRL 2021
	DRAWING TITLE: MATERIAL SPESIFICATION		
	DRAWN BY: TERRENCE, YUN CHUNG LIN	JOB NO: 01	DRAWING NO: S-02

MATERIAL SPESIFICATION


	LIGHTING	TUBE DOWNLIGHT (WARM WHITE)	IBL.CO.UK	LEVEL B,0,1,2,R	SAMPLE REQUIRED FOR APPROVAL
	LIGHTING	PENDANT LIGHT	TALA.CO.UK	LEVEL B,0,1,2,	SAMPLE REQUIRED FOR APPROVAL
	LIGHTING	RECTANGLE SHAPE LINEAR SUSPENDED LIGHT	299 LIGHTING UK	LEVEL B,0,1,2,	SAMPLE REQUIRED FOR APPROVAL
	LIGHTING	ADJUSTABLE LED STRIP	LED TECHNOLOGIES UK	LEVEL B,0,1,2,	SAMPLE REQUIRED FOR APPROVAL

NOTE: All DIMENSIONS ARE IN MILLIMETERS, UNLESS OTHERWISE STADED. SO NOT SCALE DIRECT FROM DRAWINGS. ALL DIMENSIONS TO BE VERIFIED WHEN IN DOUBT. CONTRACTOR SHALL BE RESPONSIBLE TO VERIFY DIMENSION AT SITE WHERE REQUIRED.	PROJECT: ZONE AT 45 VYNER STREET, LONDON E2 9DQ	SCALE: N.T.S	DATE: APRL 2021
	DRAWING TITLE: MATERIAL SPESIFICATION		
	DRAWN BY: TERRENCE, YUN CHUNG LIN	JOB NO: 01	DRAWING NO: S-02



LOCATION PLAN
SM-01 SCALE 1:1250


NOTE: All DIMENSIONS are in MILLIMETERS, UNLESS OTHERWISE STATED. SO NOT SCALE DIRECT FROM DRAWINGS. All DIMENSIONS TO BE VERIFIED WHEN IN DOUBT. CONTRACTOR SHALL BE RESPONSIBLE TO VERIFY DIMENSION AT SITE WHERE REQUIRED.	PROJECT: ZONE AT 45 VYNER STREET, LONDON E2 9DQ	SCALE: 1:1250	DATE: APRIL 2021
	DRAWING TITLE: LOCATION PLAN		
	DRAWN BY: TERRENCE, YUN CHUNG LIN	JOB NO: 01	DRAWING NO: SM-01

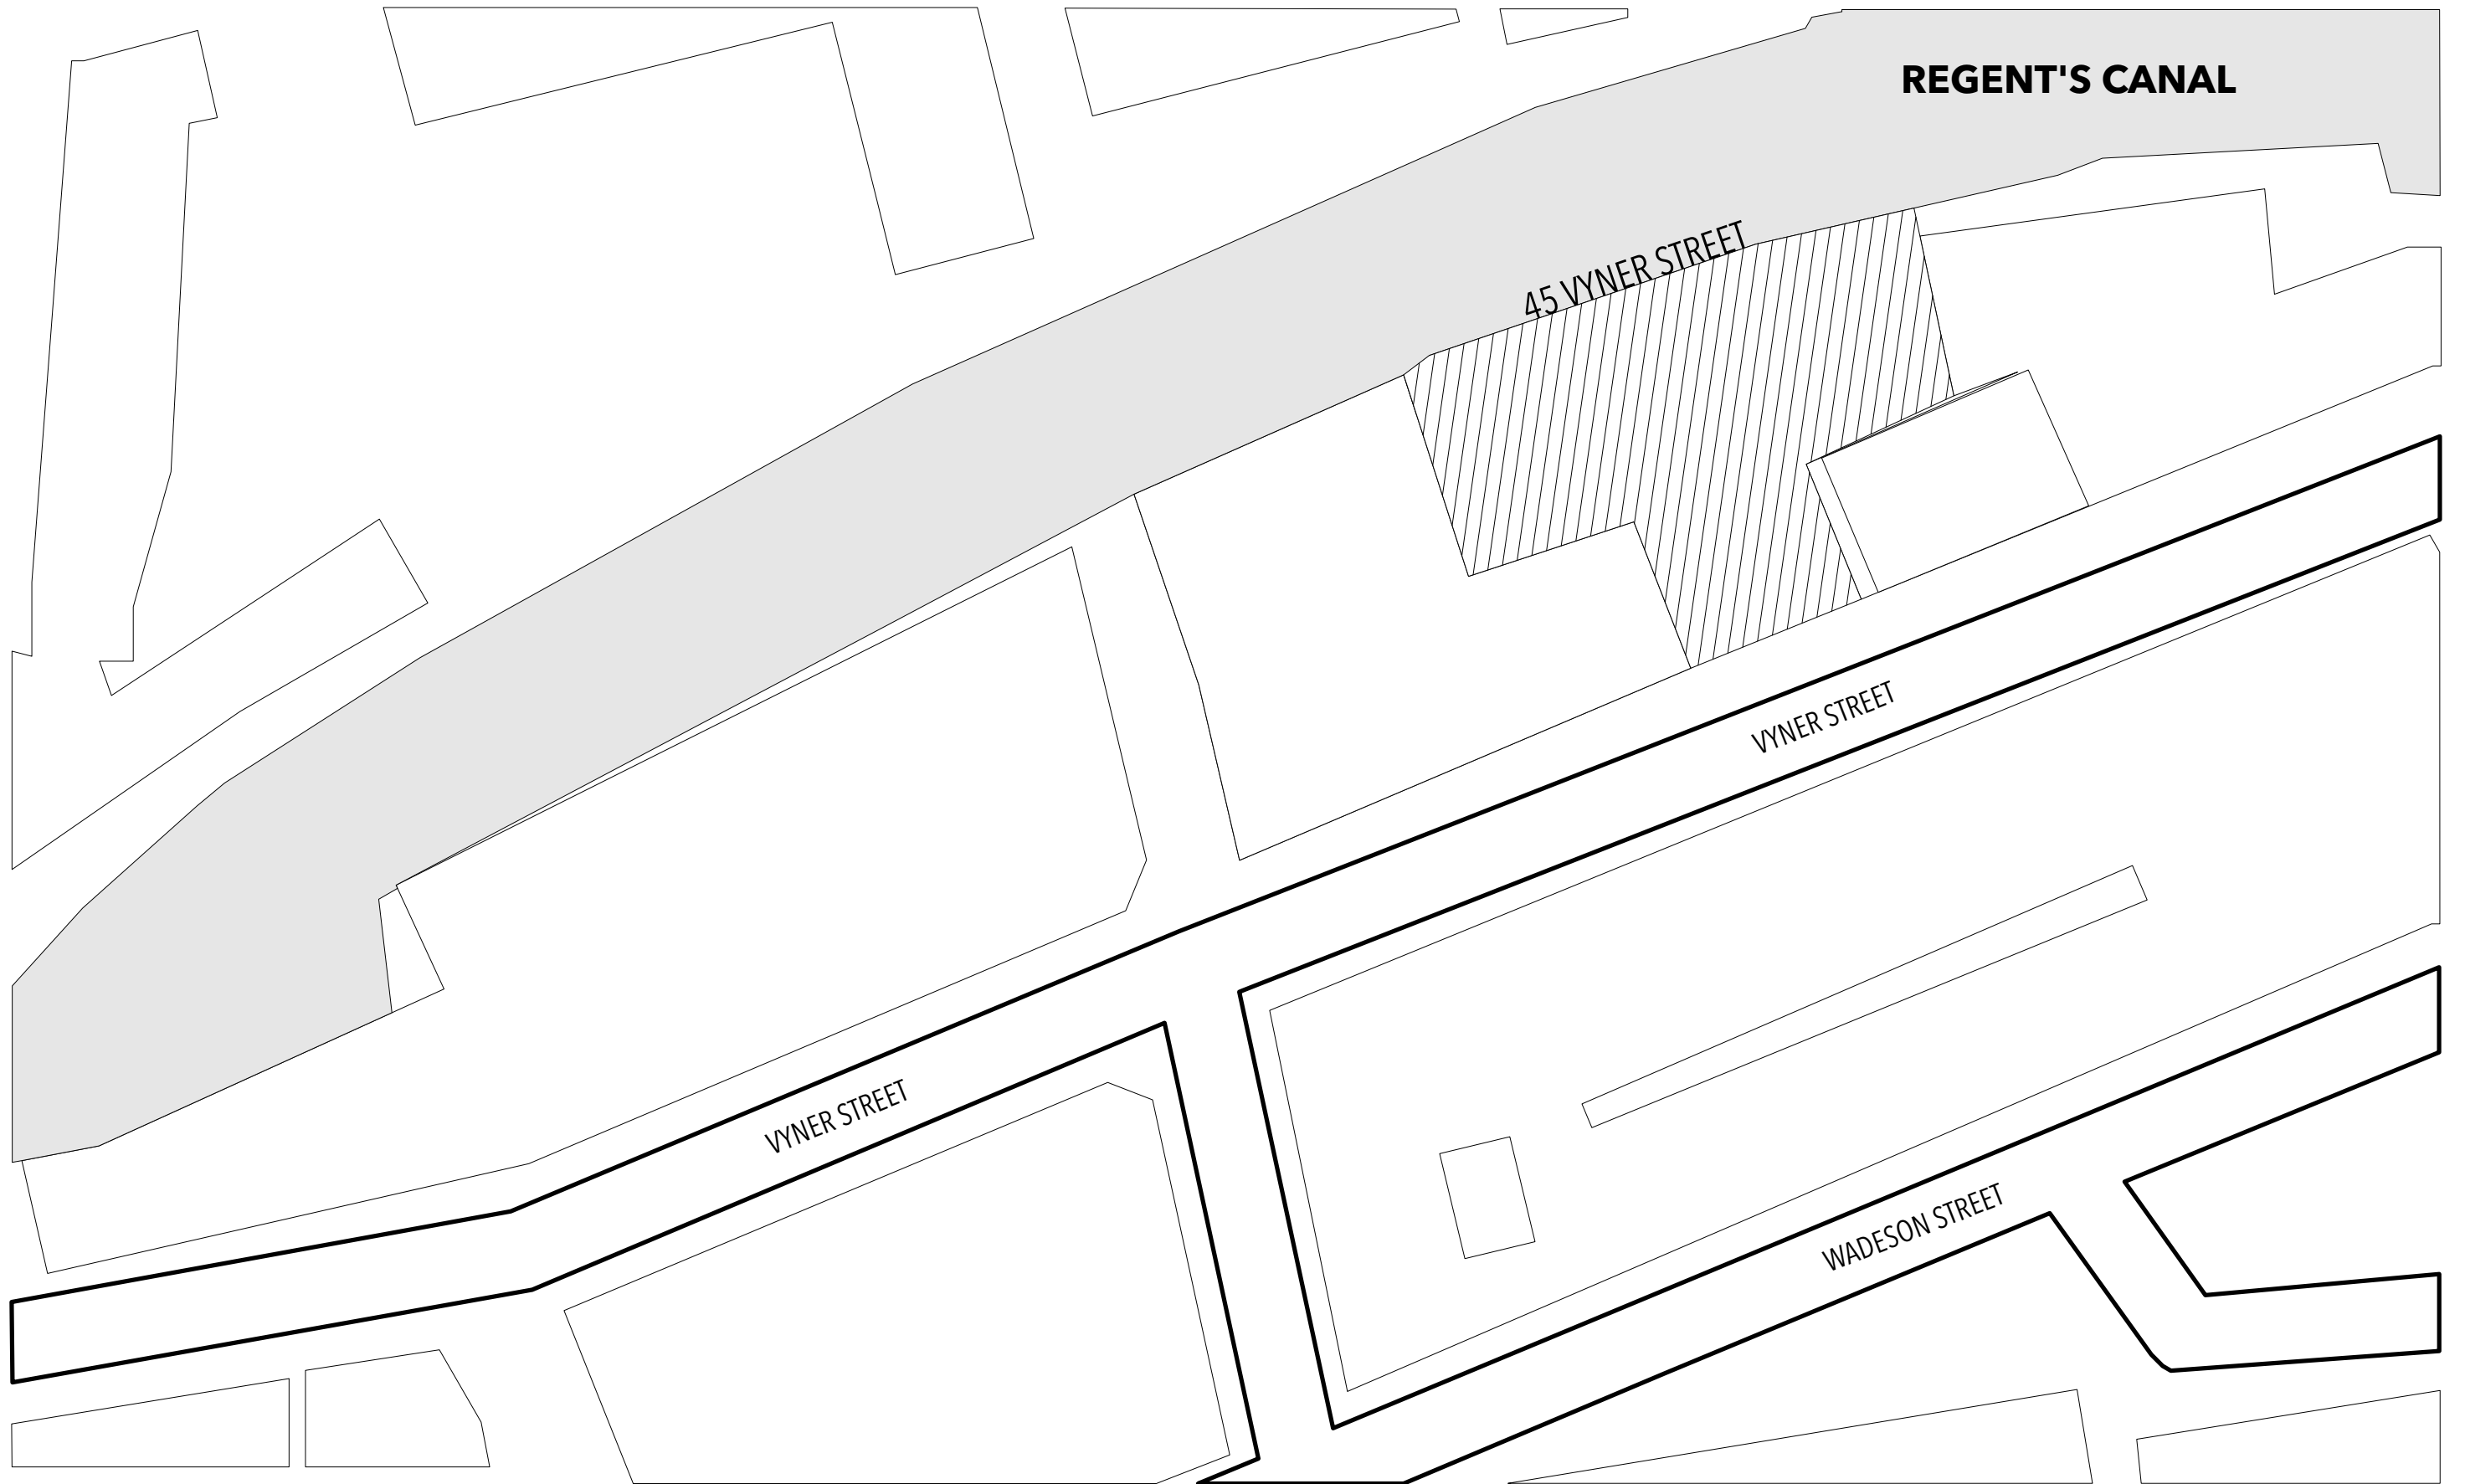

EXISTING SITE PLAN

SM-02 SCALE 1:500


NOTE: ALL DIMENSIONS ARE IN MILLIMETERS, UNLESS OTHERWISE STADED. SO NOT SCALE DIRECT FROM DRAWINGS. ALL DIMENSIONS TO BE VERIFIED WHEN IN DOUBT. CONTRACTOR SHALL BE RESPONSIBLE TO VERIFY DIMENSION AT SITE WHERE REQUIRED.	PROJECT: ZONE AT 45 VYNER STREET, LONDON E2 9DQ	SCALE: 1:500	DATE: APRIL 2021
	DRAWING TITLE: EXISTING SITE PLAN		
	DRAWN BY: TERRENCE, YUN CHUNG LIN	JOB NO: 01	DRAWING NO: SM-02

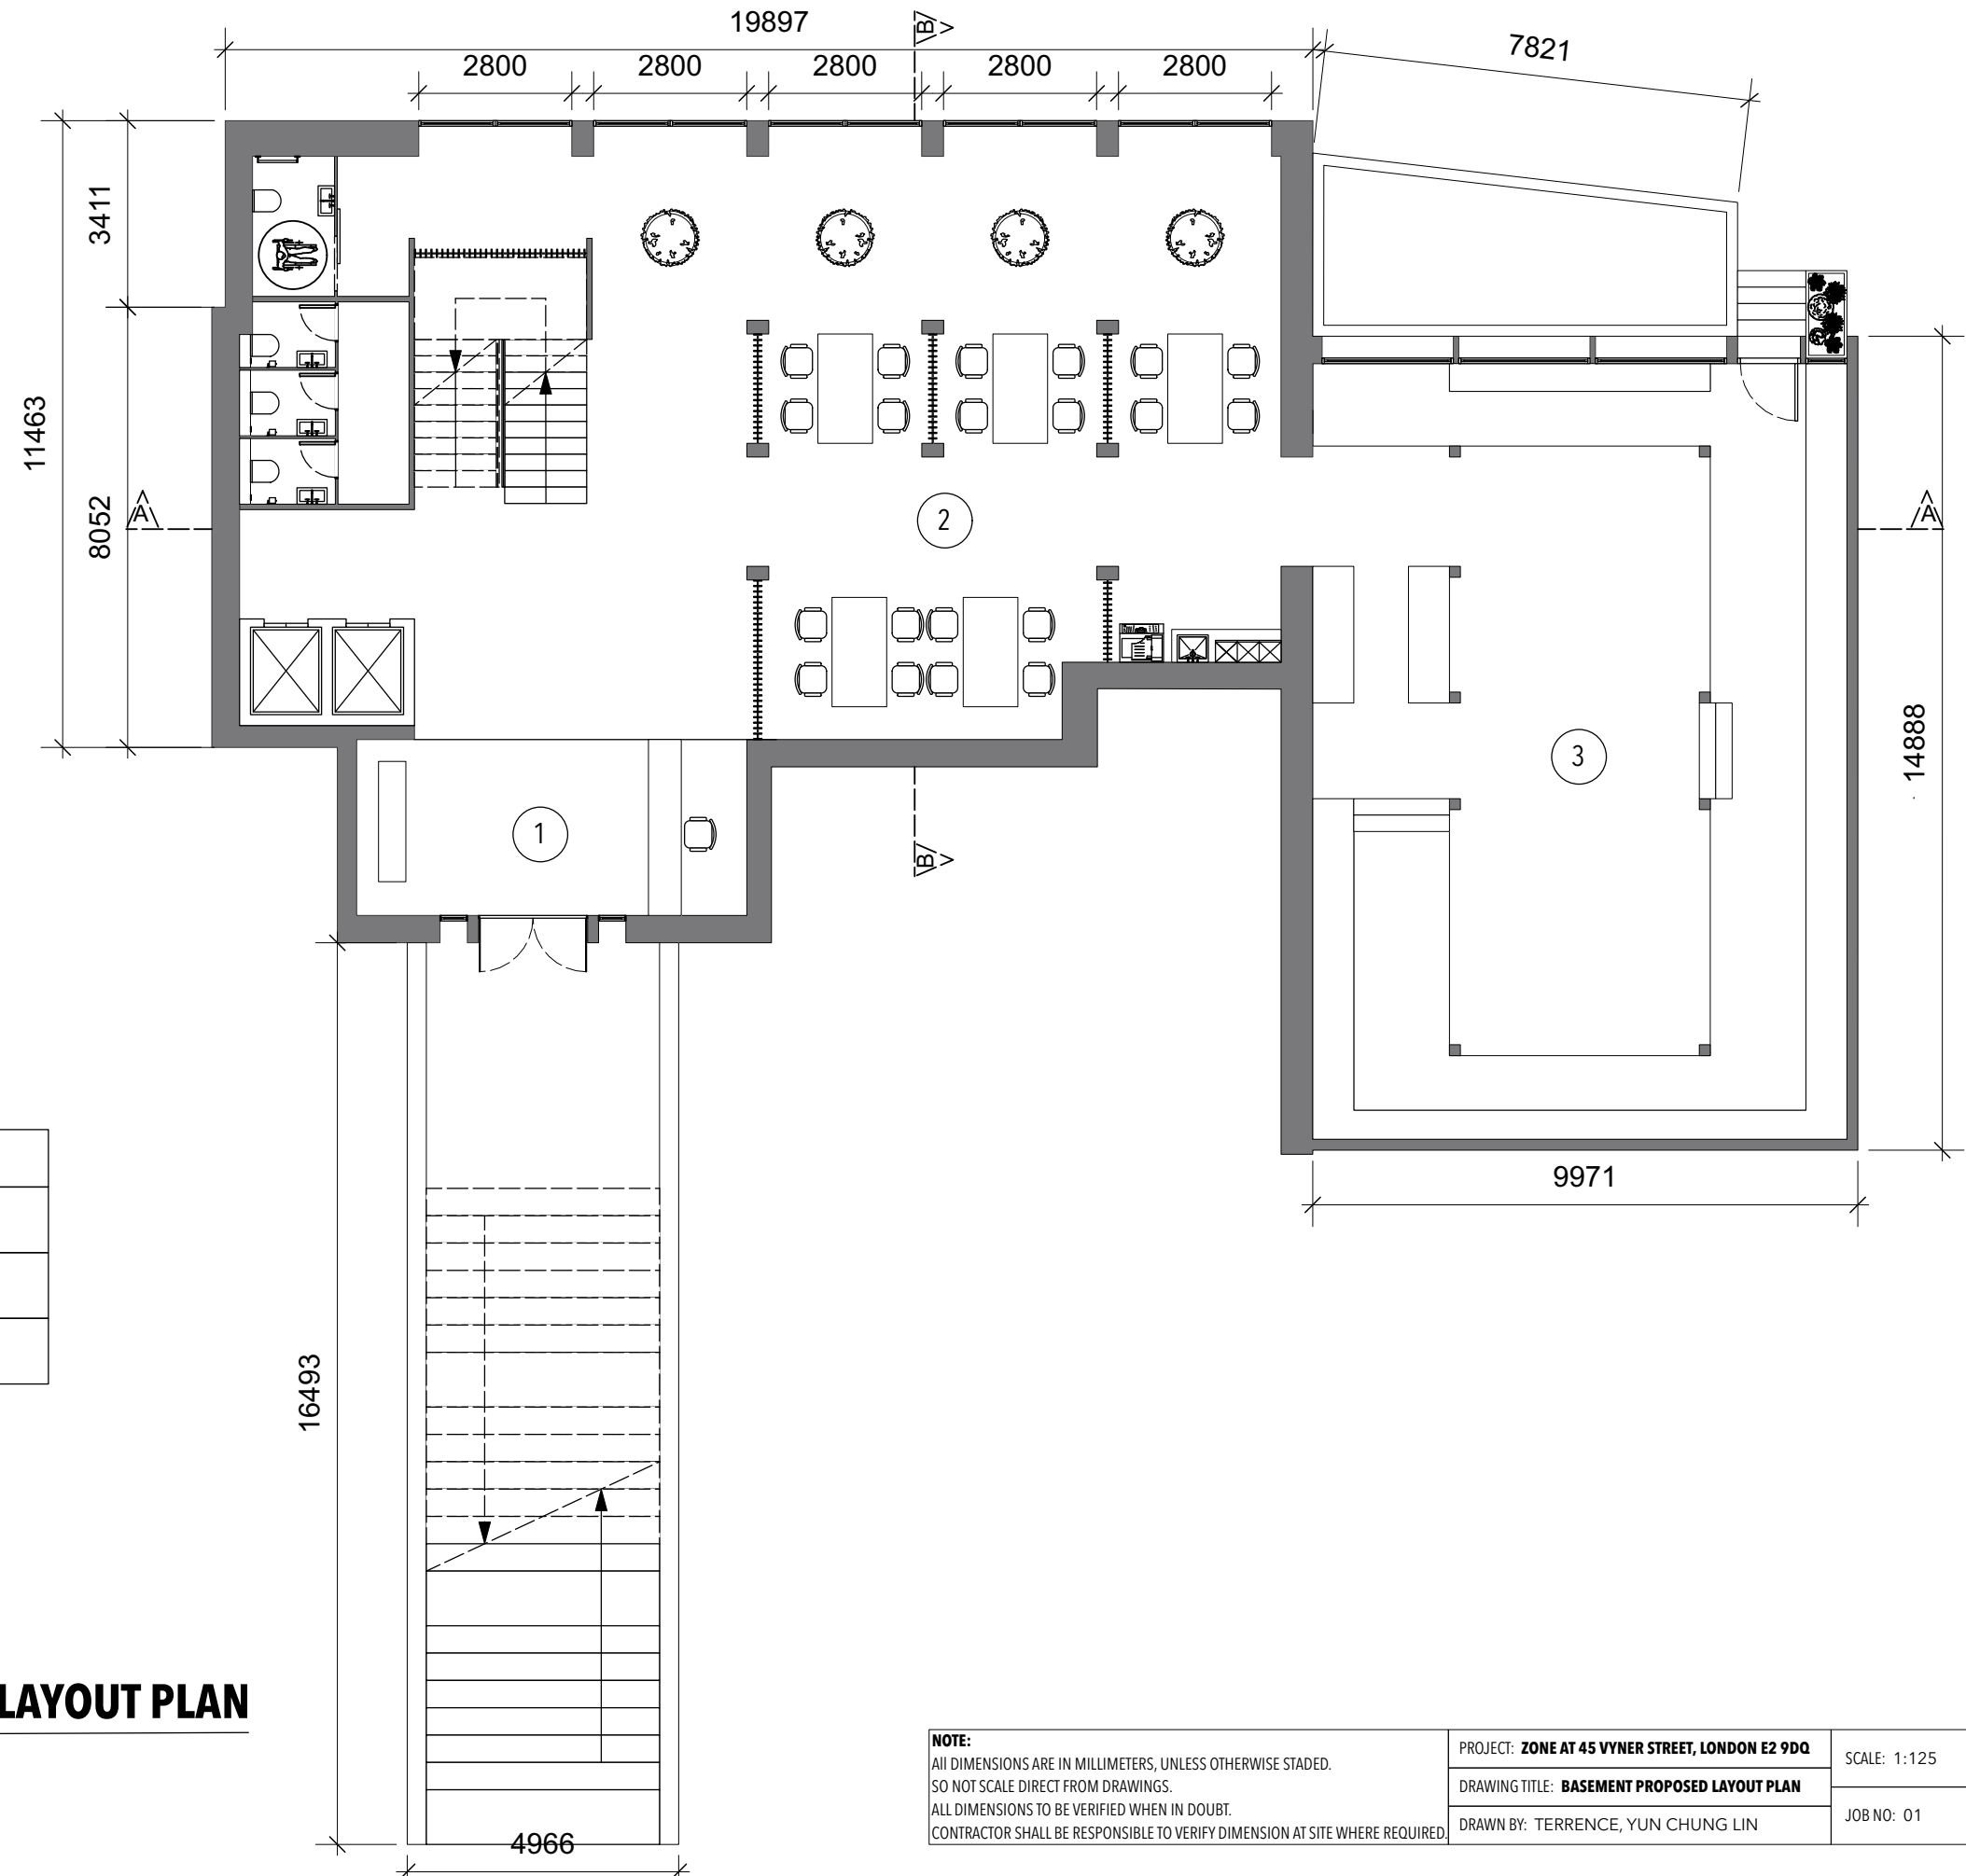


LEGEND	
1	MAIN ENTRANCE & RECEPTION
2	SHARED WORKING SPACE
3	EXHIBITION SPACE

BASEMENT PROPOSED LAYOUT PLAN
FLP-00 SCALE 1:125

NOTE: ALL DIMENSIONS ARE IN MILLIMETERS, UNLESS OTHERWISE STADED. SO NOT SCALE DIRECT FROM DRAWINGS. ALL DIMENSIONS TO BE VERIFIED WHEN IN DOUBT. CONTRACTOR SHALL BE RESPONSIBLE TO VERIFY DIMENSION AT SITE WHERE REQUIRED.	PROJECT: ZONE AT 45 VYNER STREET, LONDON E2 9DQ	SCALE: 1:125	DATE: APRIL 2021
	DRAWING TITLE: BASEMENT PROPOSED LAYOUT PLAN	JOB NO: 01	DRAWING NO: FLP-00
	DRAWN BY: TERRENCE, YUN CHUNG LIN		

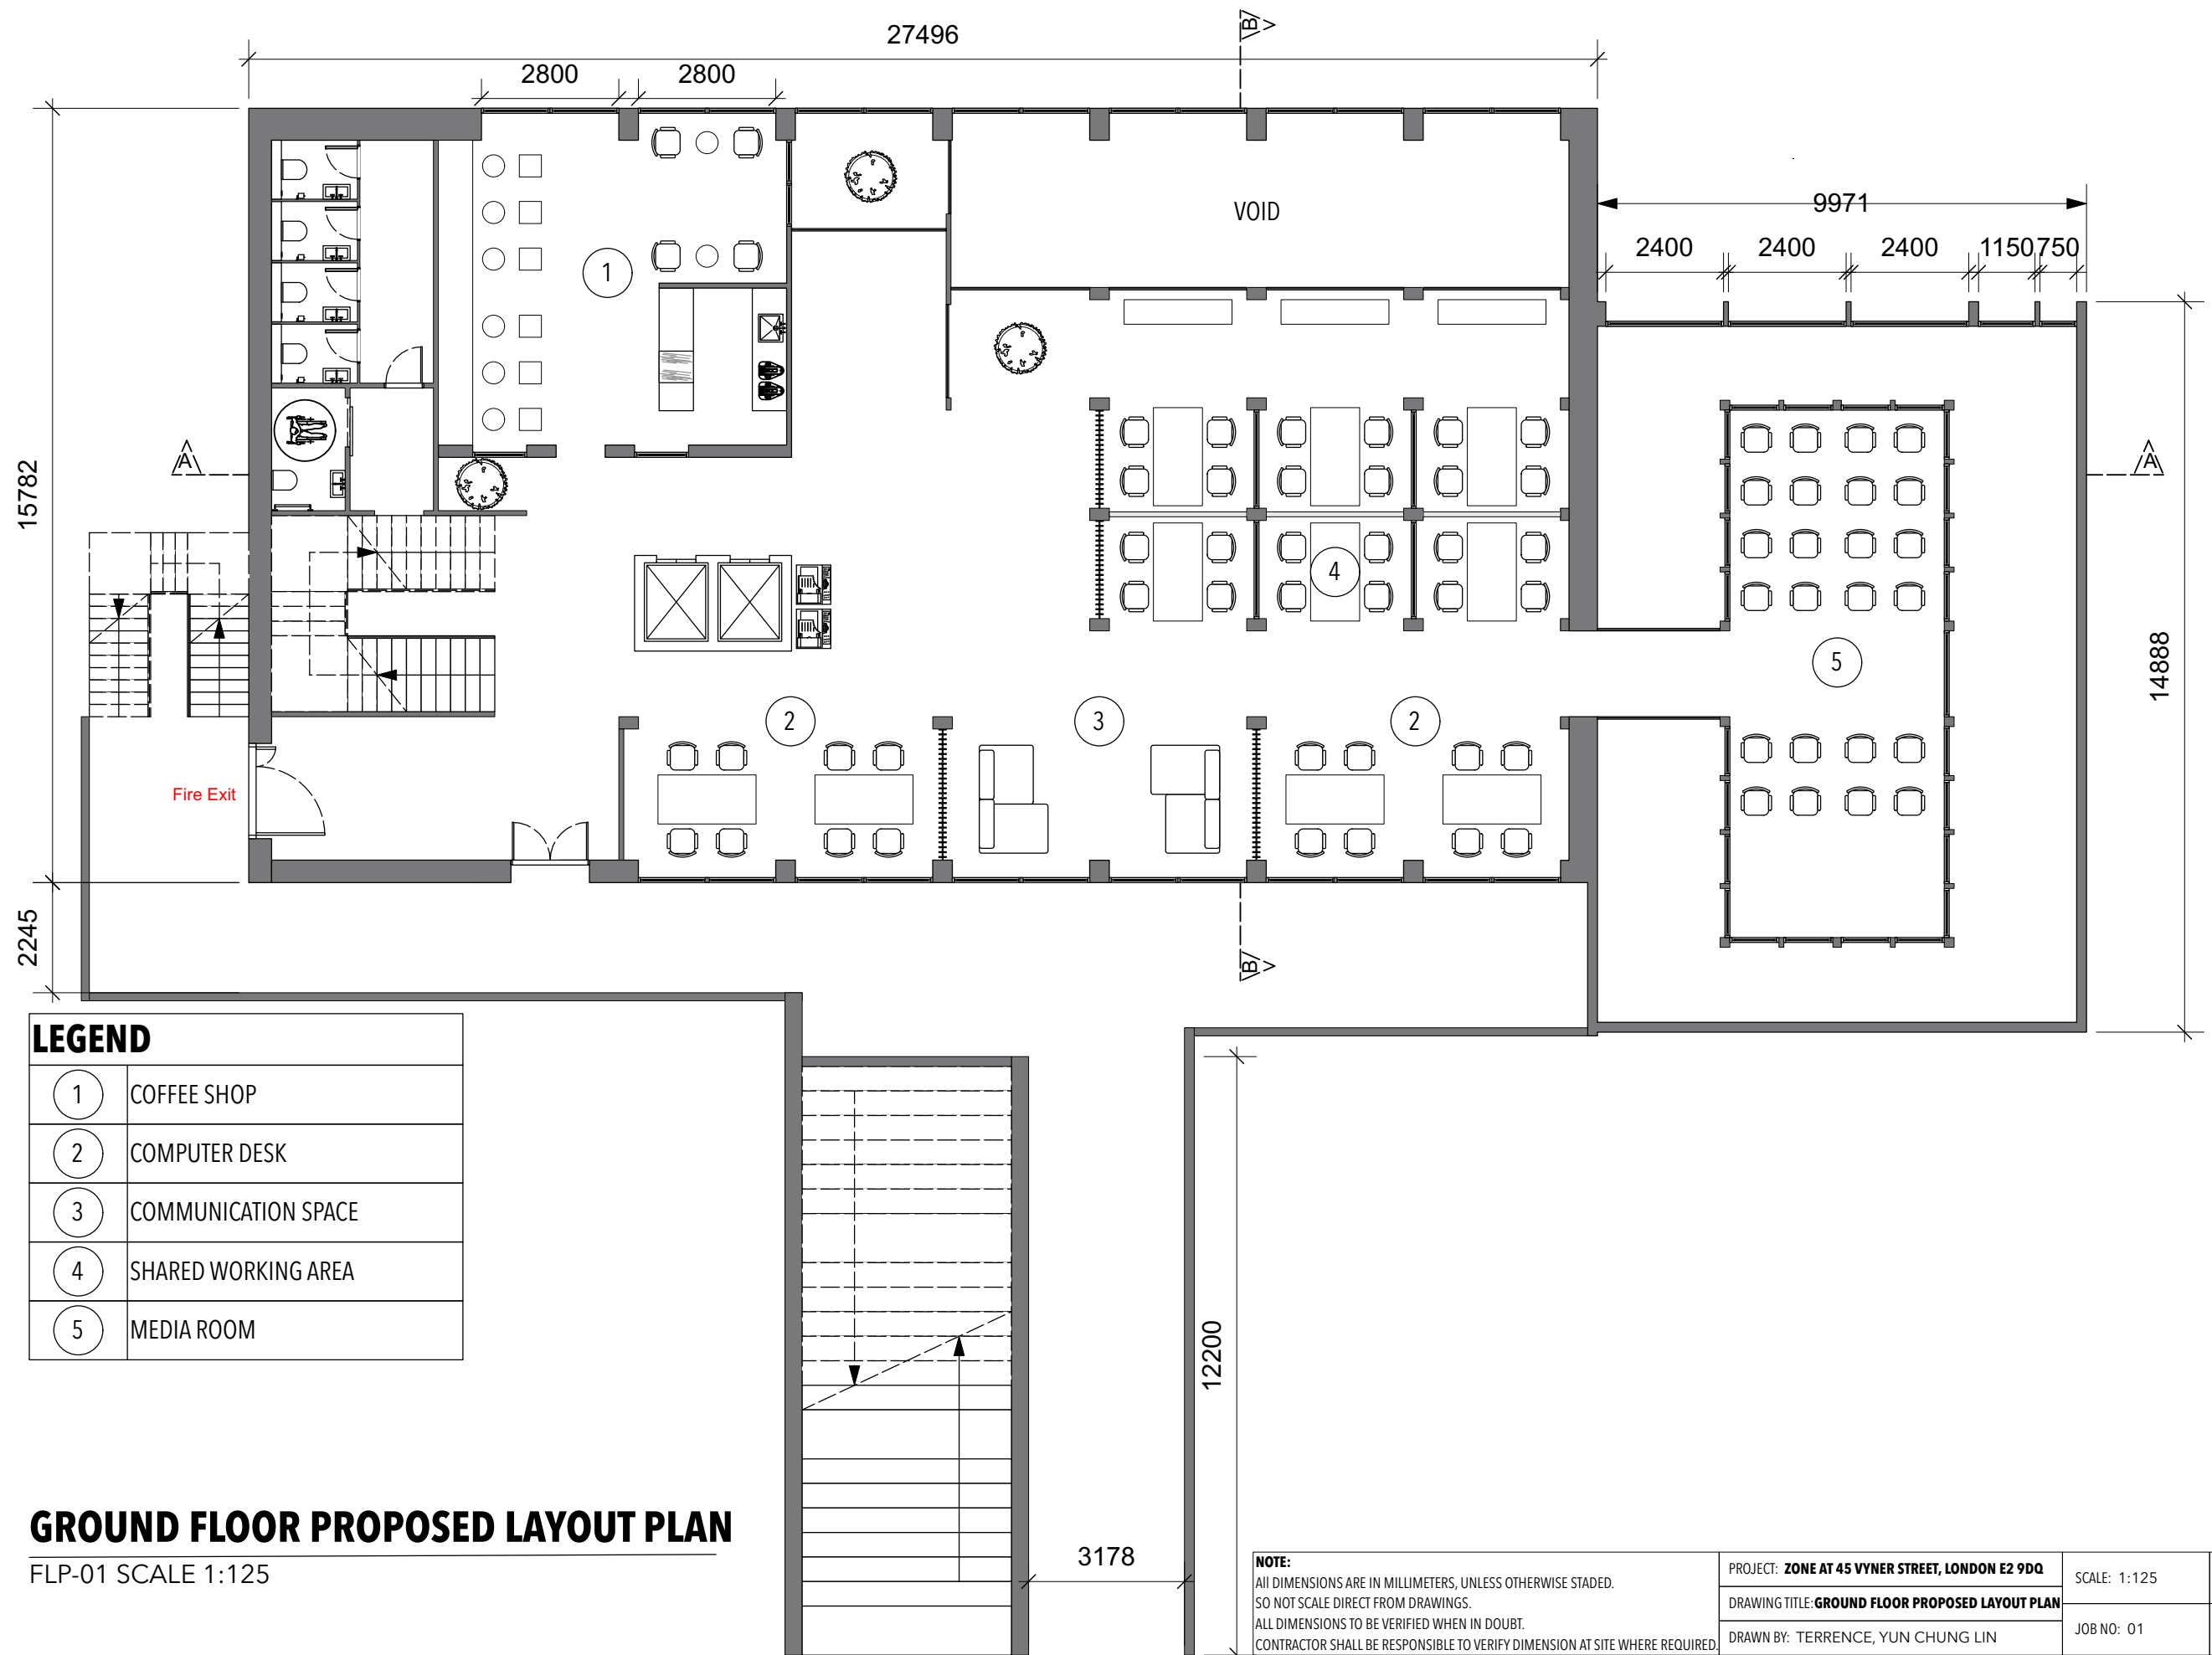

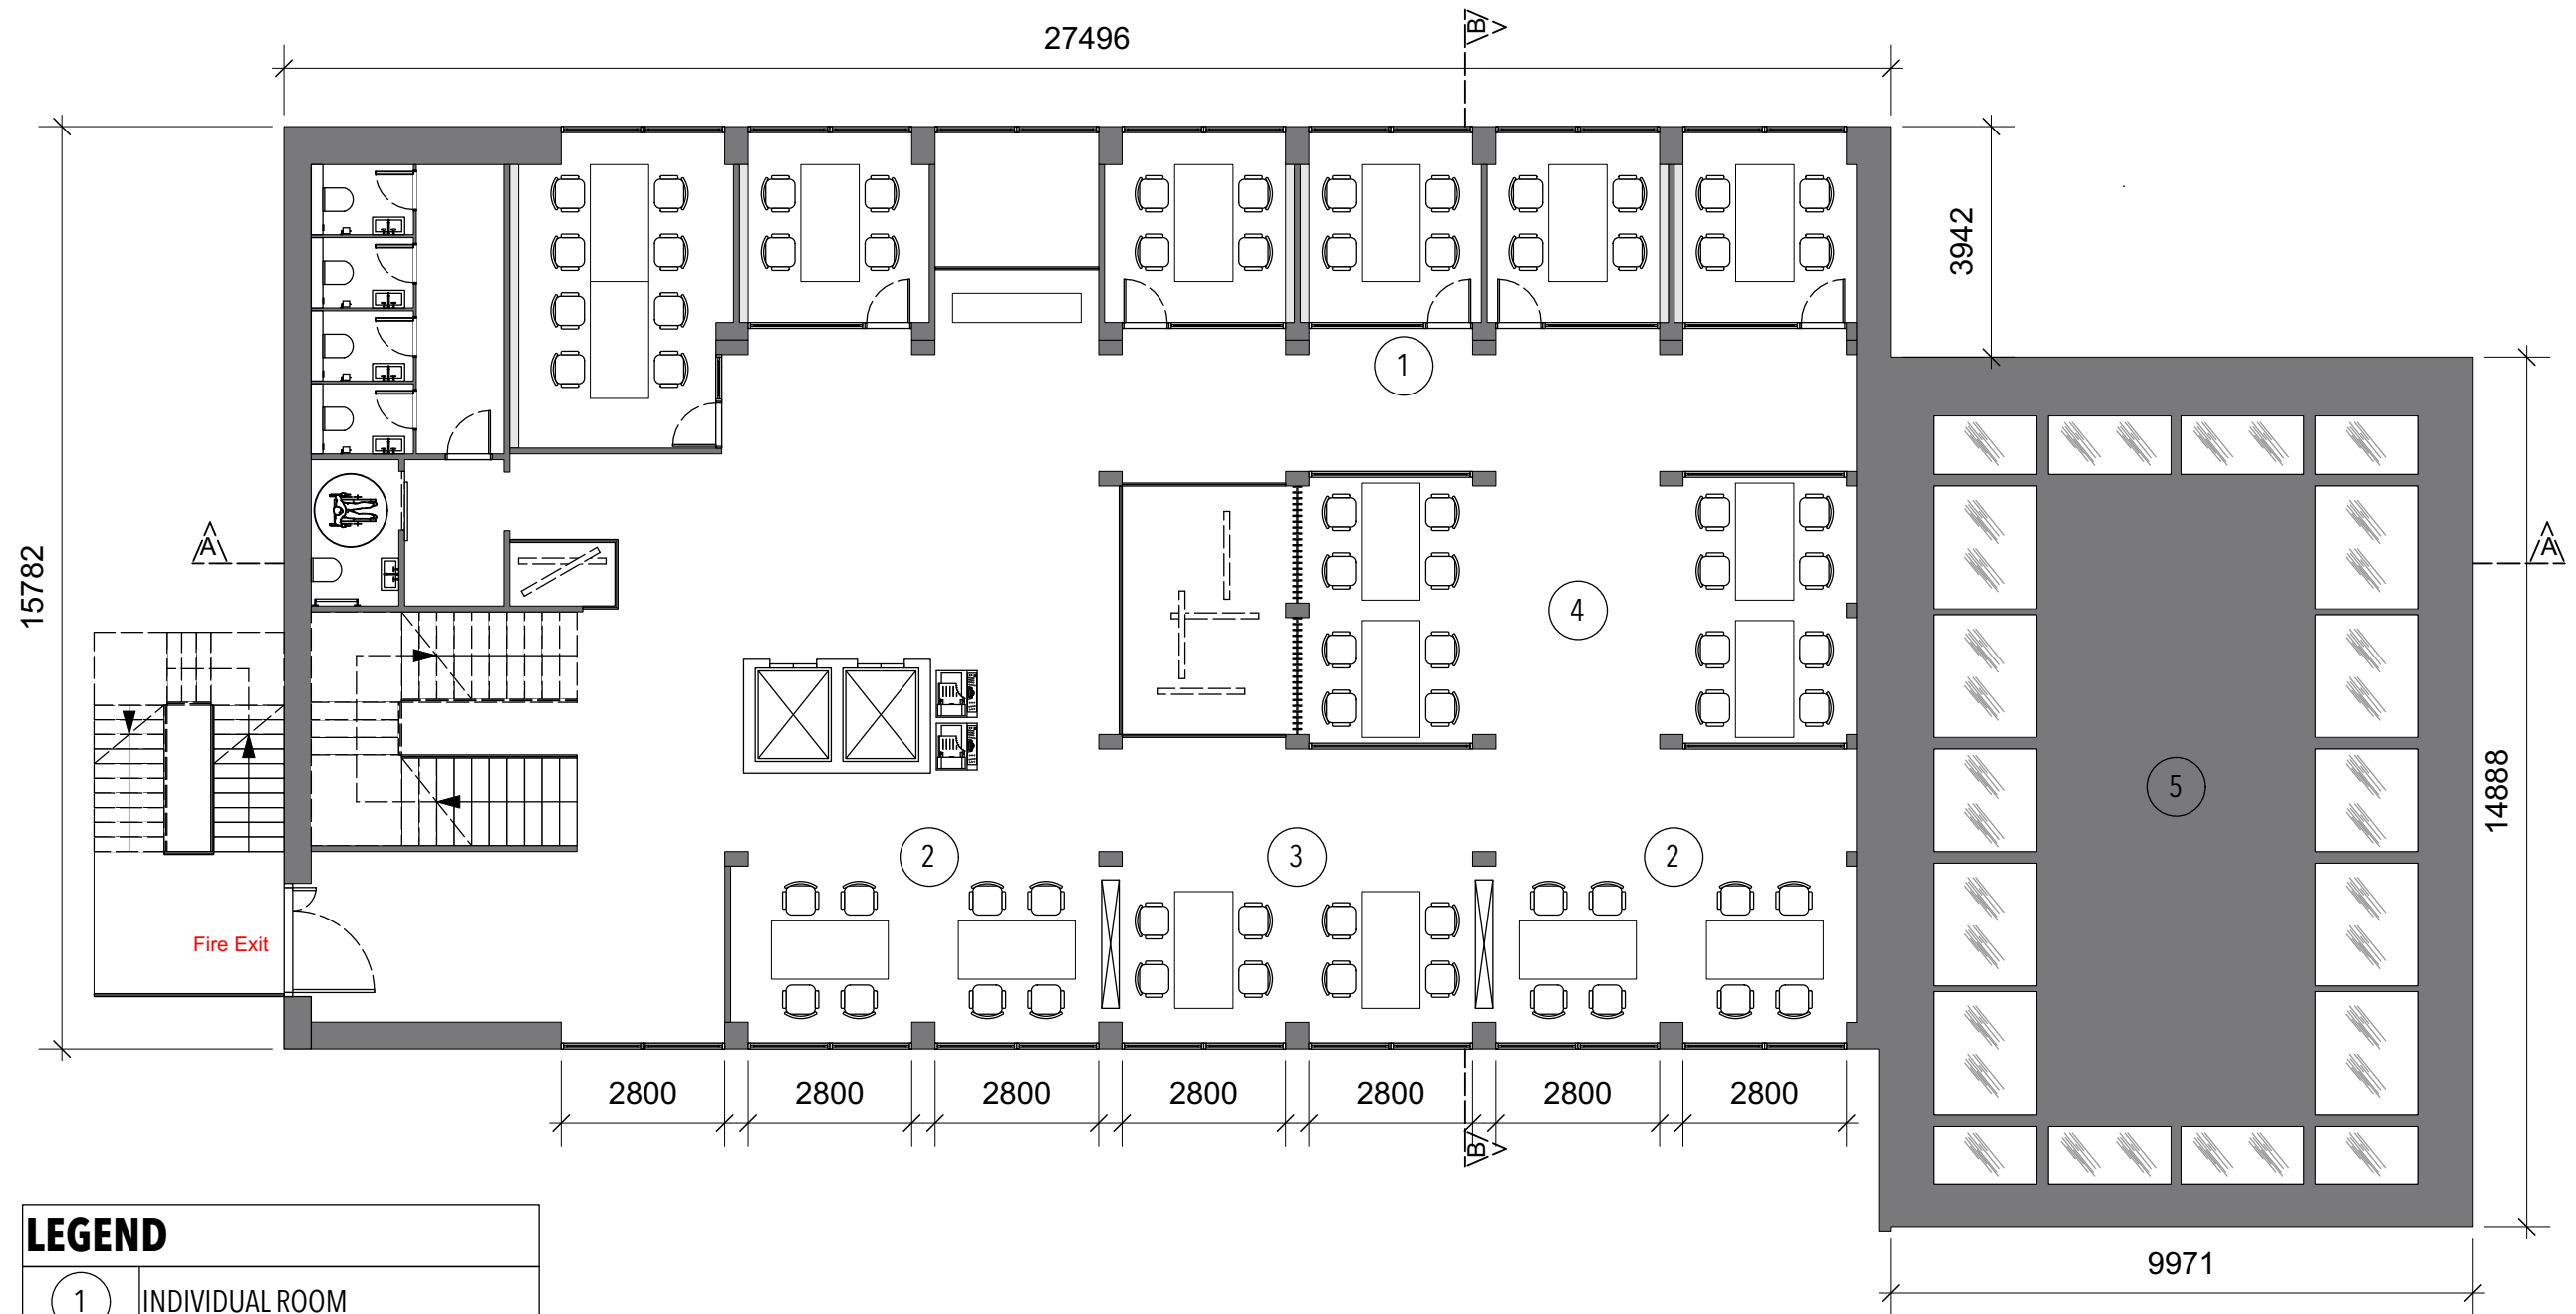


LEGEND	
1	INDIVIDUAL ROOM
2	COMPUTER DESK
3	COMMUNICATION SPACE
4	OPEN WORKING AREA
5	NONE ACCESSIBLE GREEN ROOF

1ST FLOOR PROPOSED LAYOUT PLAN

FLP-02 SCALE 1:125

NOTE: ALL DIMENSIONS ARE IN MILLIMETERS, UNLESS OTHERWISE STADED. SO NOT SCALE DIRECT FROM DRAWINGS. ALL DIMENSIONS TO BE VERIFIED WHEN IN DOUBT. CONTRACTOR SHALL BE RESPONSIBLE TO VERIFY DIMENSION AT SITE WHERE REQUIRED.	PROJECT: ZONE AT 45 VYNER STREET, LONDON E2 9DQ	SCALE: 1:125	DATE: APRIL 2021
	DRAWING TITLE: 1ST FLOOR PROPOSED LAYOUT PLAN	JOB NO: 01	DRAWING NO: FLP-02
	DRAWN BY: TERRENCE, YUN CHUNG LIN		

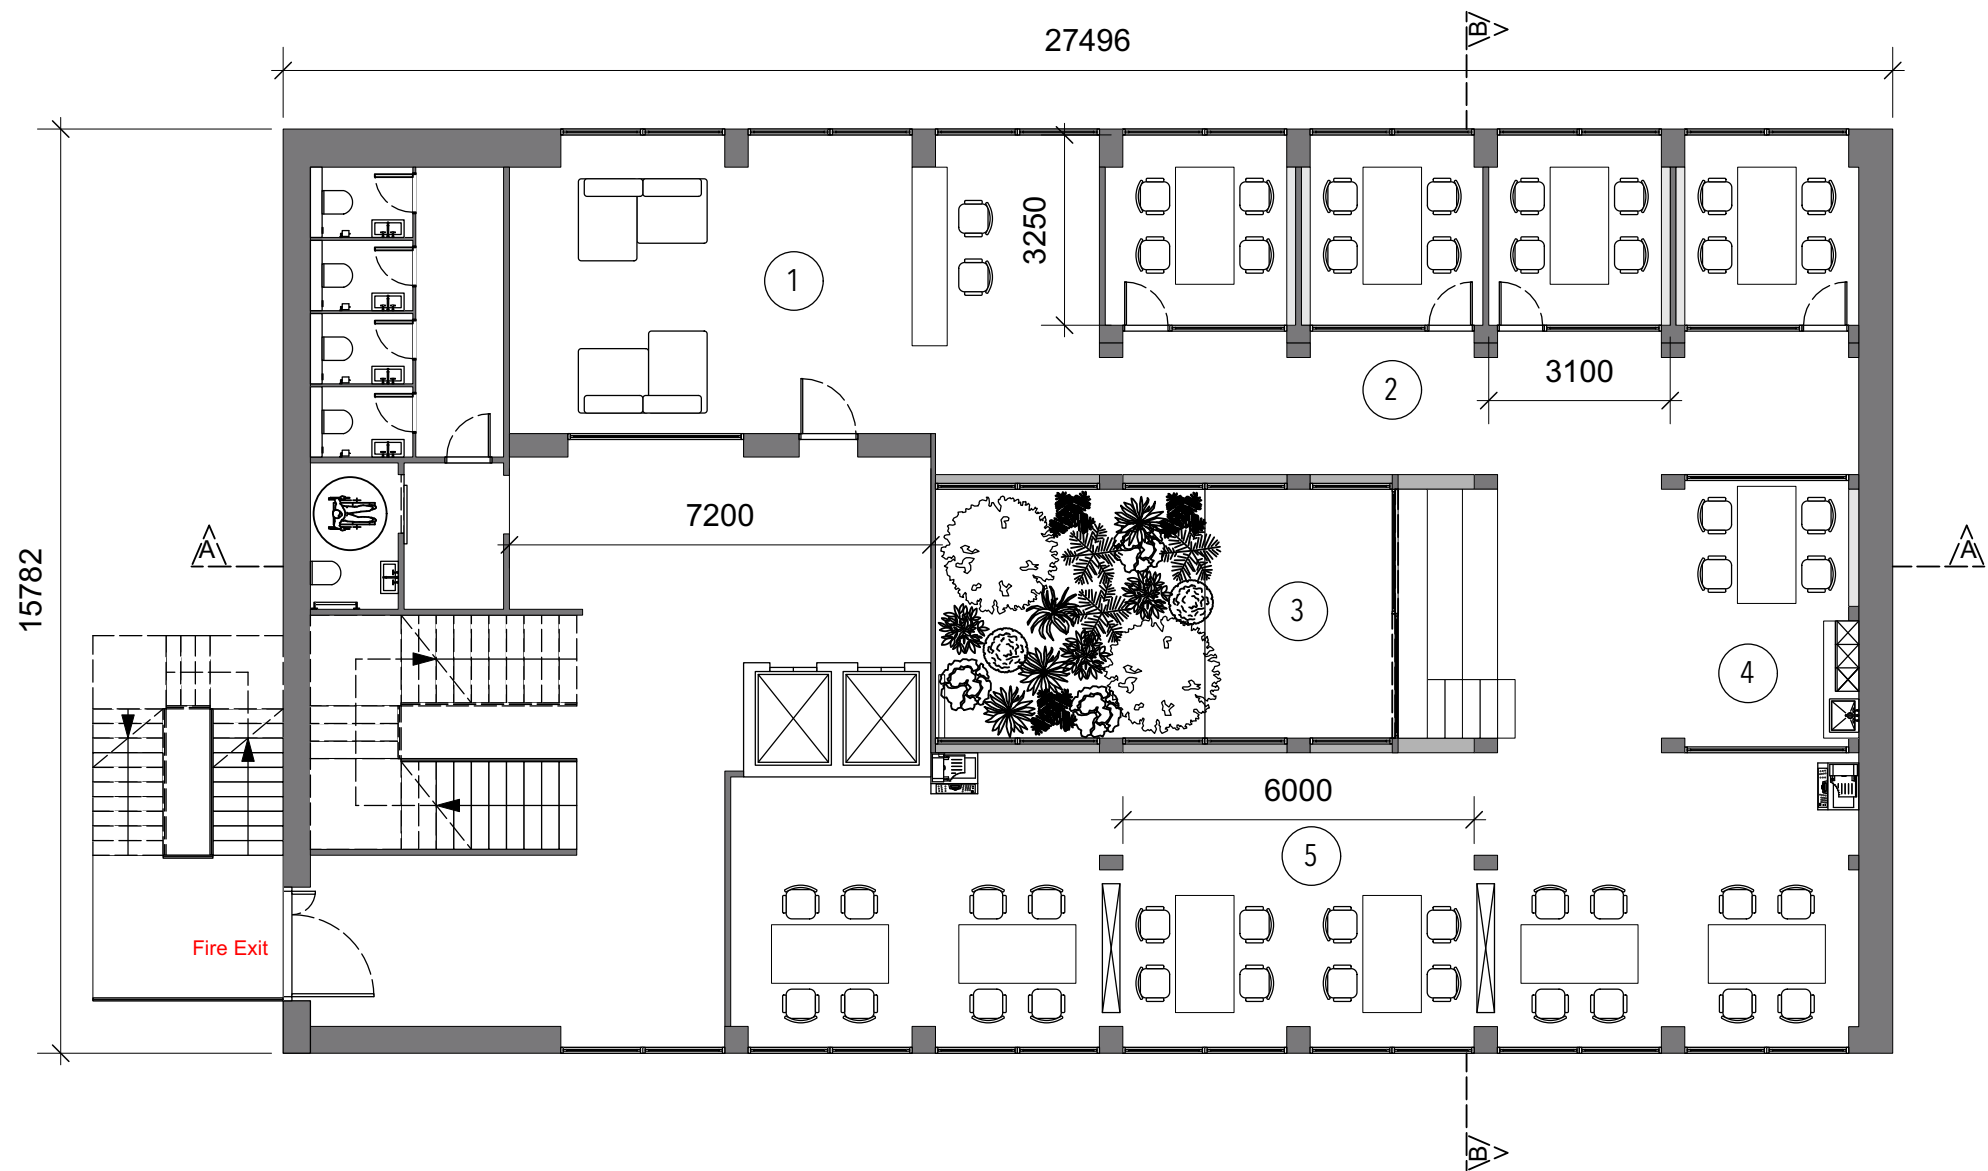


LEGEND	
1	STUDIO RECEPTION
2	PRIVATE WORKING ROOM
3	COURTYARD GARDEN
4	SERVICE STATION
5	COMPUTER WORK SPACE

2ND FLOOR PROPOSED LAYOUT PLAN

FLP-03 SCALE 1:125

NOTE: ALL DIMENSIONS ARE IN MILLIMETERS, UNLESS OTHERWISE STATED. SO NOT SCALE DIRECT FROM DRAWINGS. ALL DIMENSIONS TO BE VERIFIED WHEN IN DOUBT. CONTRACTOR SHALL BE RESPONSIBLE TO VERIFY DIMENSION AT SITE WHERE REQUIRED.	PROJECT: ZONE AT 45 VYNER STREET, LONDON E2 9DQ	SCALE: 1:125	DATE: APRIL 2021
	DRAWING TITLE: 2ND FLOOR PROPOSED LAYOUT PLAN		
	DRAWN BY: TERRENCE, YUN CHUNG LIN	JOB NO: 01	DRAWING NO: FLP-03

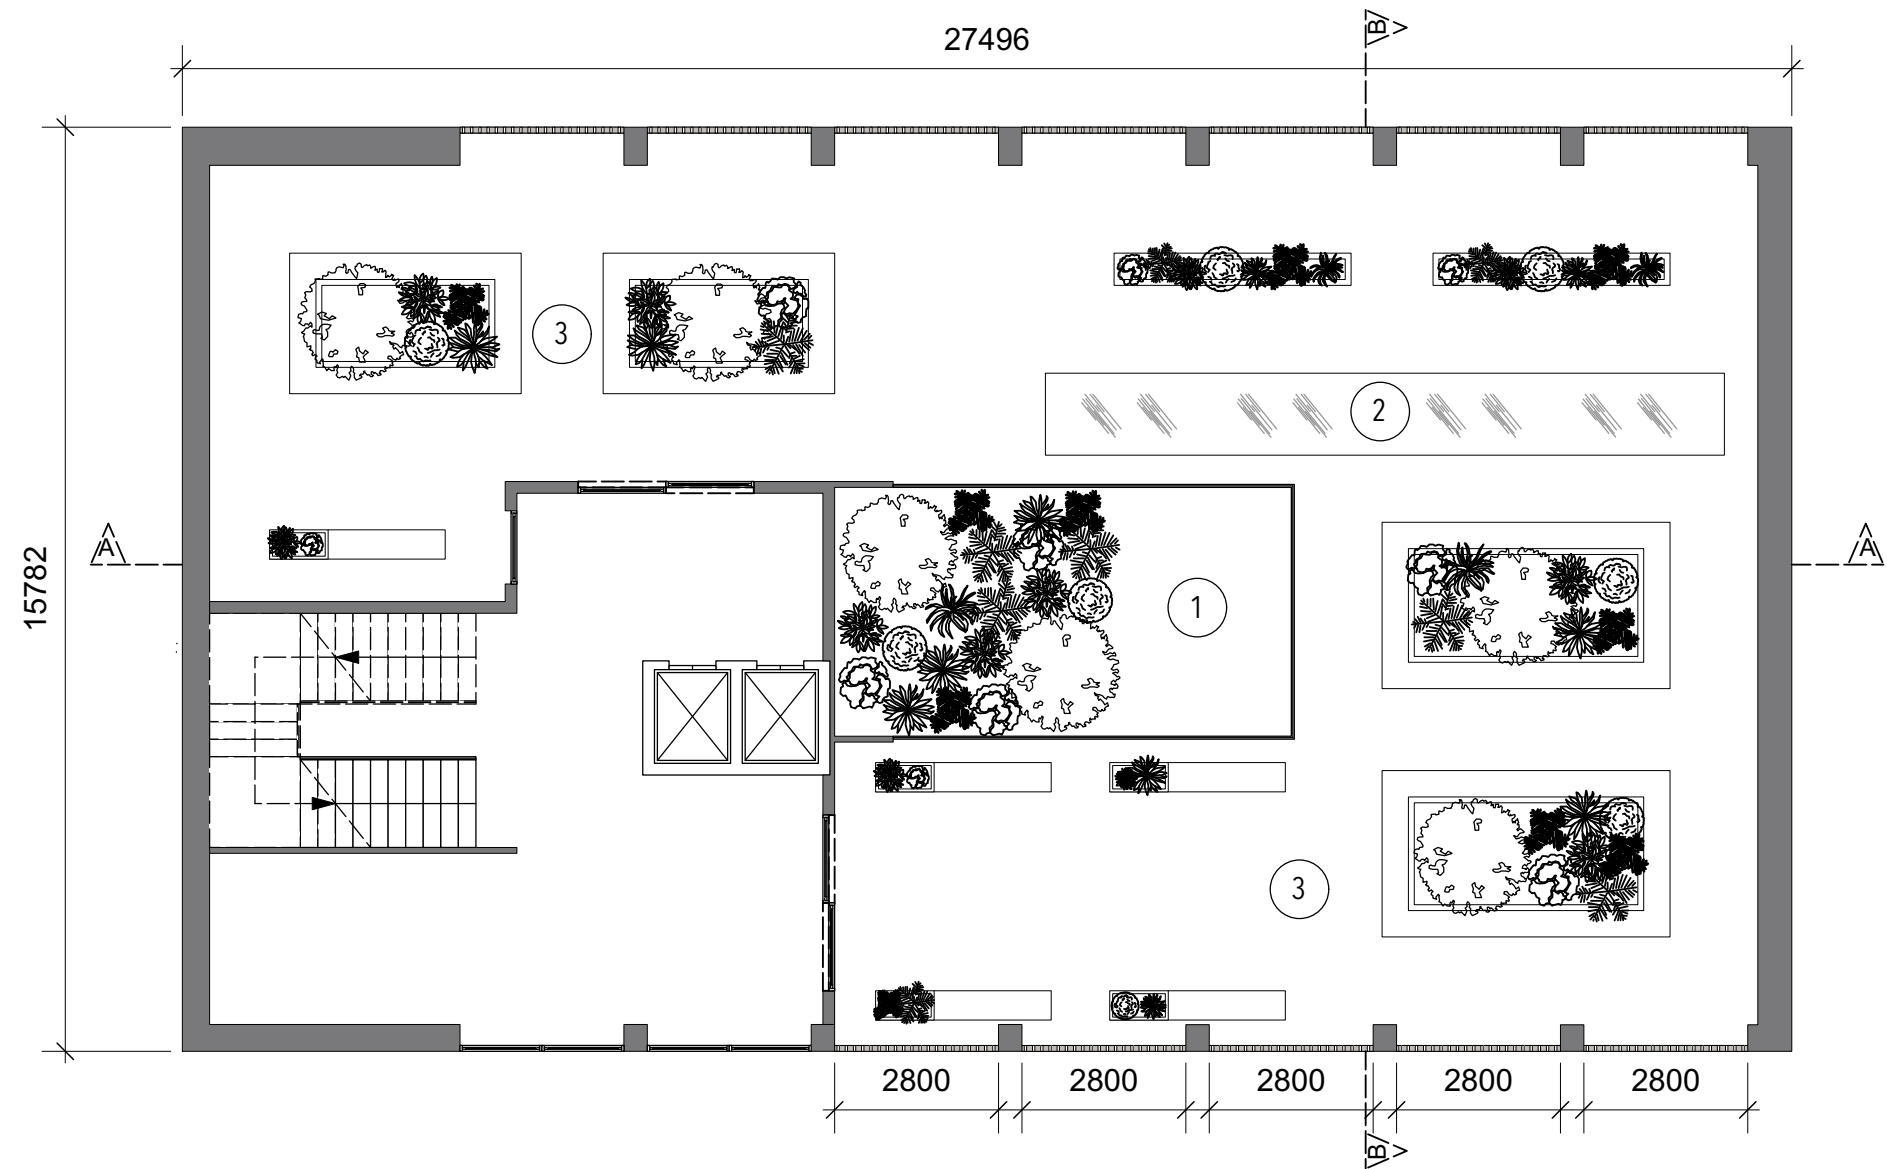


LEGEND	
1	COURTYARD GARDEN
2	WALKABLE FLAT ROOF GLASS
3	SEATING AREA

ROOFTOP PROPOSED LAYOUT PLAN

FLP-04 SCALE 1:125

NOTE: ALL DIMENSIONS ARE IN MILLIMETERS, UNLESS OTHERWISE STATED. SO NOT SCALE DIRECT FROM DRAWINGS. ALL DIMENSIONS TO BE VERIFIED WHEN IN DOUBT. CONTRACTOR SHALL BE RESPONSIBLE TO VERIFY DIMENSION AT SITE WHERE REQUIRED.	PROJECT: ZONE AT 45 VYNER STREET, LONDON E2 9DQ	SCALE: 1:125	DATE: APRIL 2021
	DRAWING TITLE: ROOFTOP PROPOSED LAYOUT PLAN	JOB NO: 01	DRAWING NO: FLP-04
	DRAWN BY: TERRENCE, YUN CHUNG LIN		

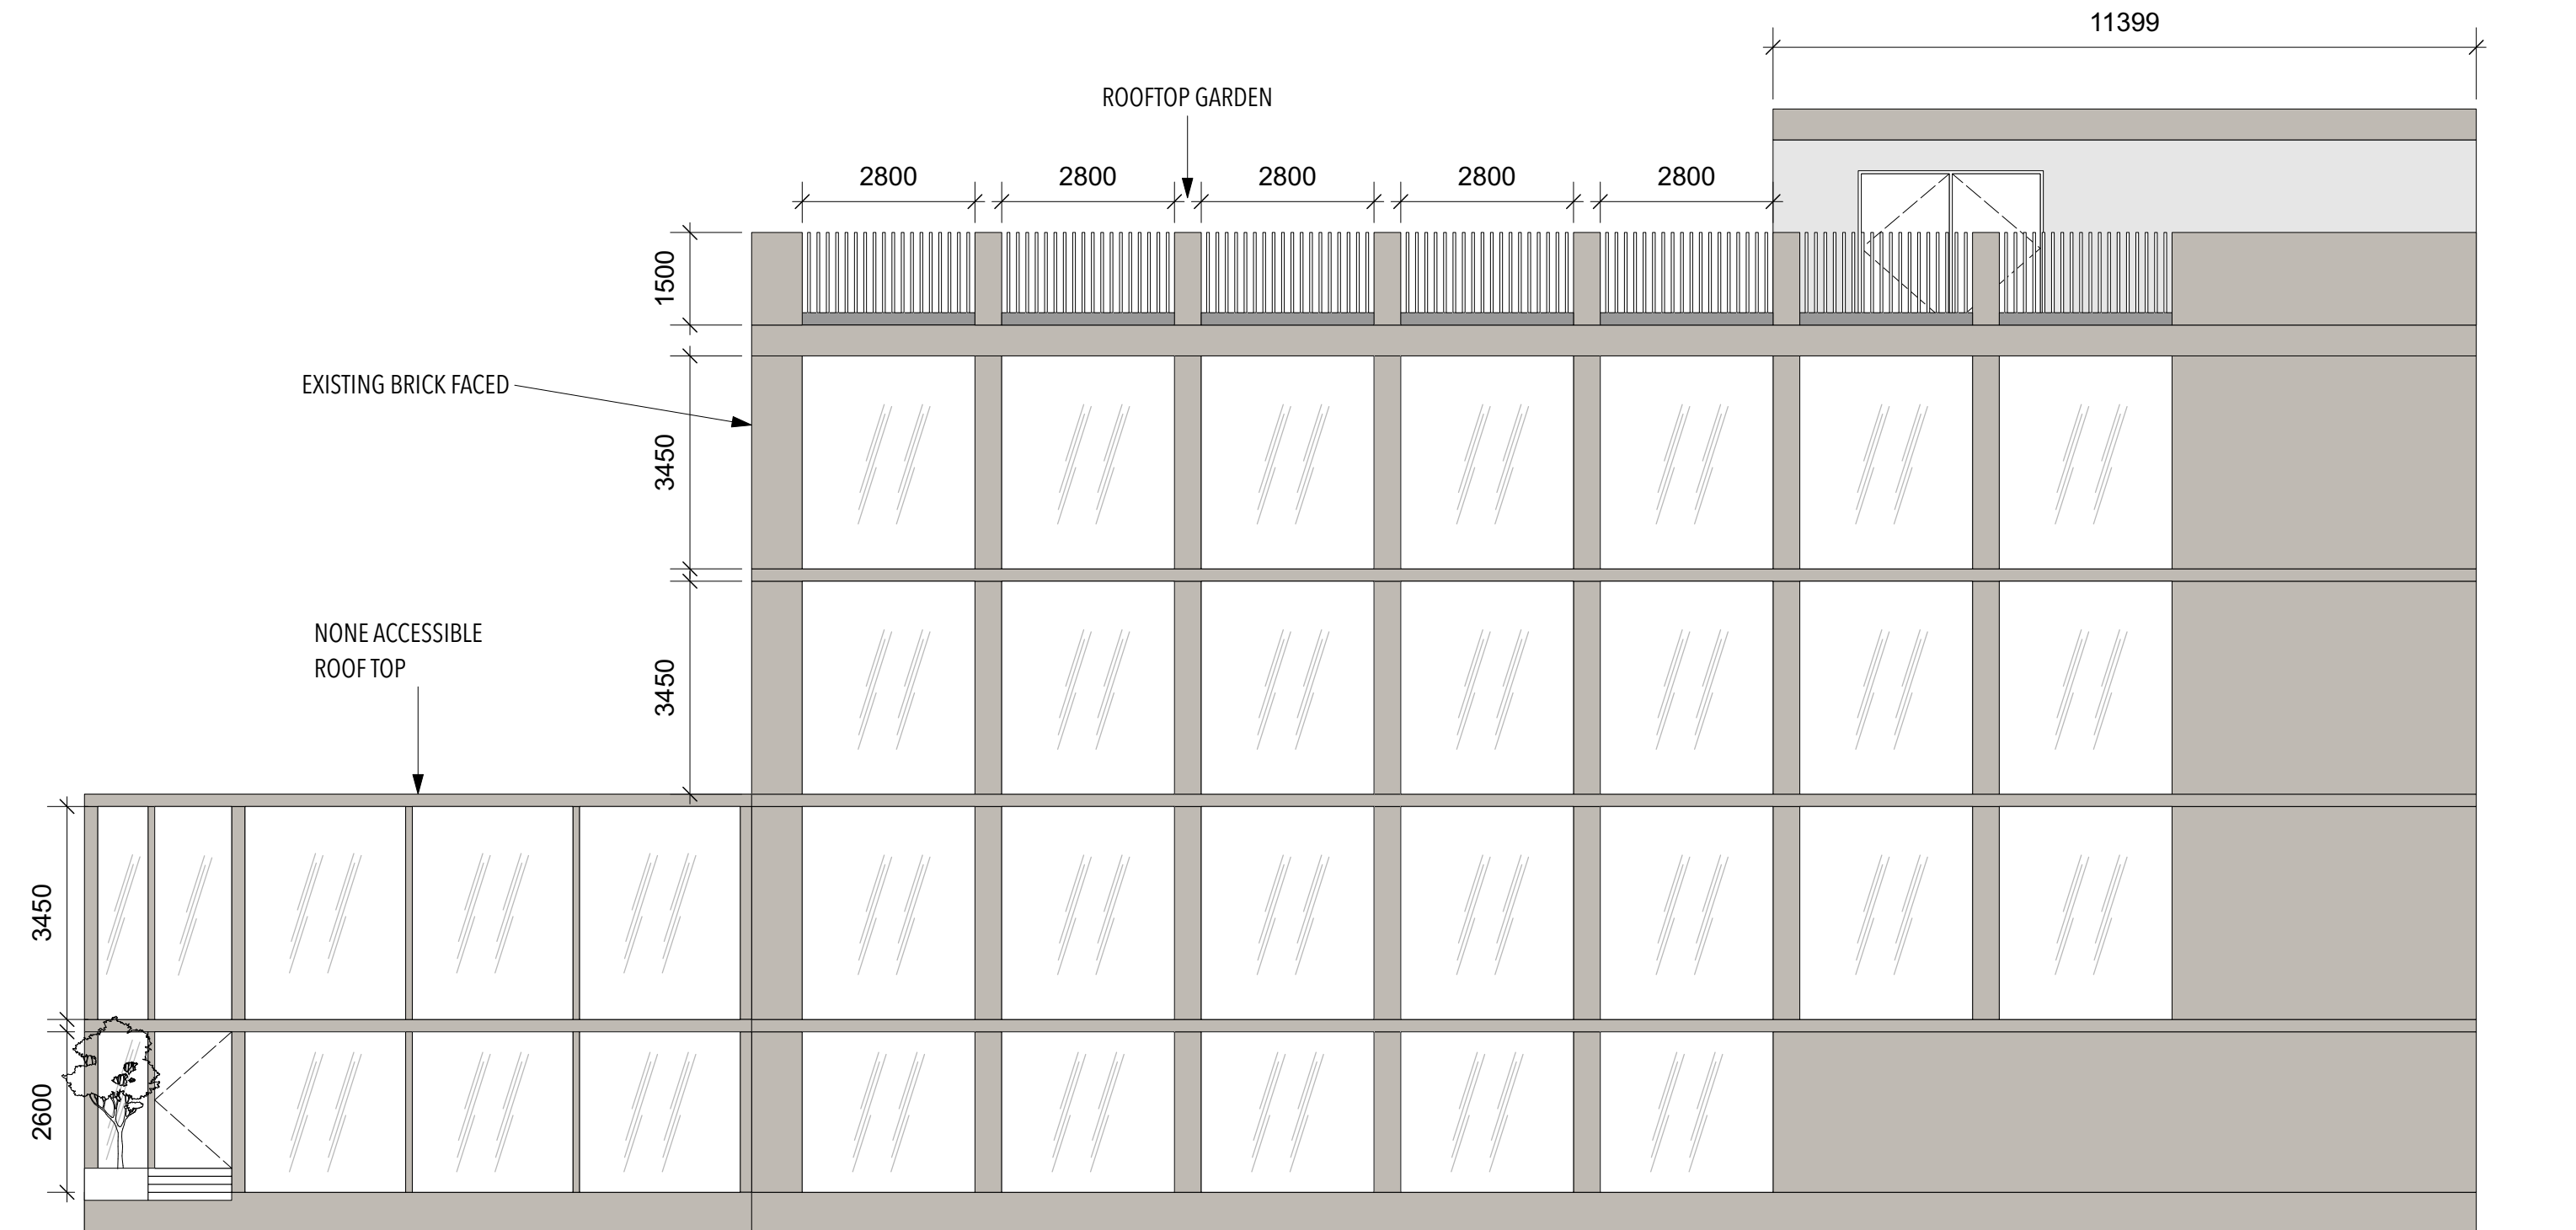


REGENT'S CANAL

EXTERIOR ELEVATION A

EE-01 SCALE 1:100

NOTE: ALL DIMENSIONS ARE IN MILLIMETERS, UNLESS OTHERWISE STATED. SO NOT SCALE DIRECT FROM DRAWINGS. ALL DIMENSIONS TO BE VERIFIED WHEN IN DOUBT. CONTRACTOR SHALL BE RESPONSIBLE TO VERIFY DIMENSION AT SITE WHERE REQUIRED.	PROJECT: ZONE AT 45 VYNER STREET, LONDON E2 9DQ	SCALE: 1:100	DATE: APRIL 2021
	DRAWING TITLE: EXTERIOR ELEVATION A		
	DRAWN BY: TERRENCE, YUN CHUNG LIN	JOB NO: 01	DRAWING NO: EE-01

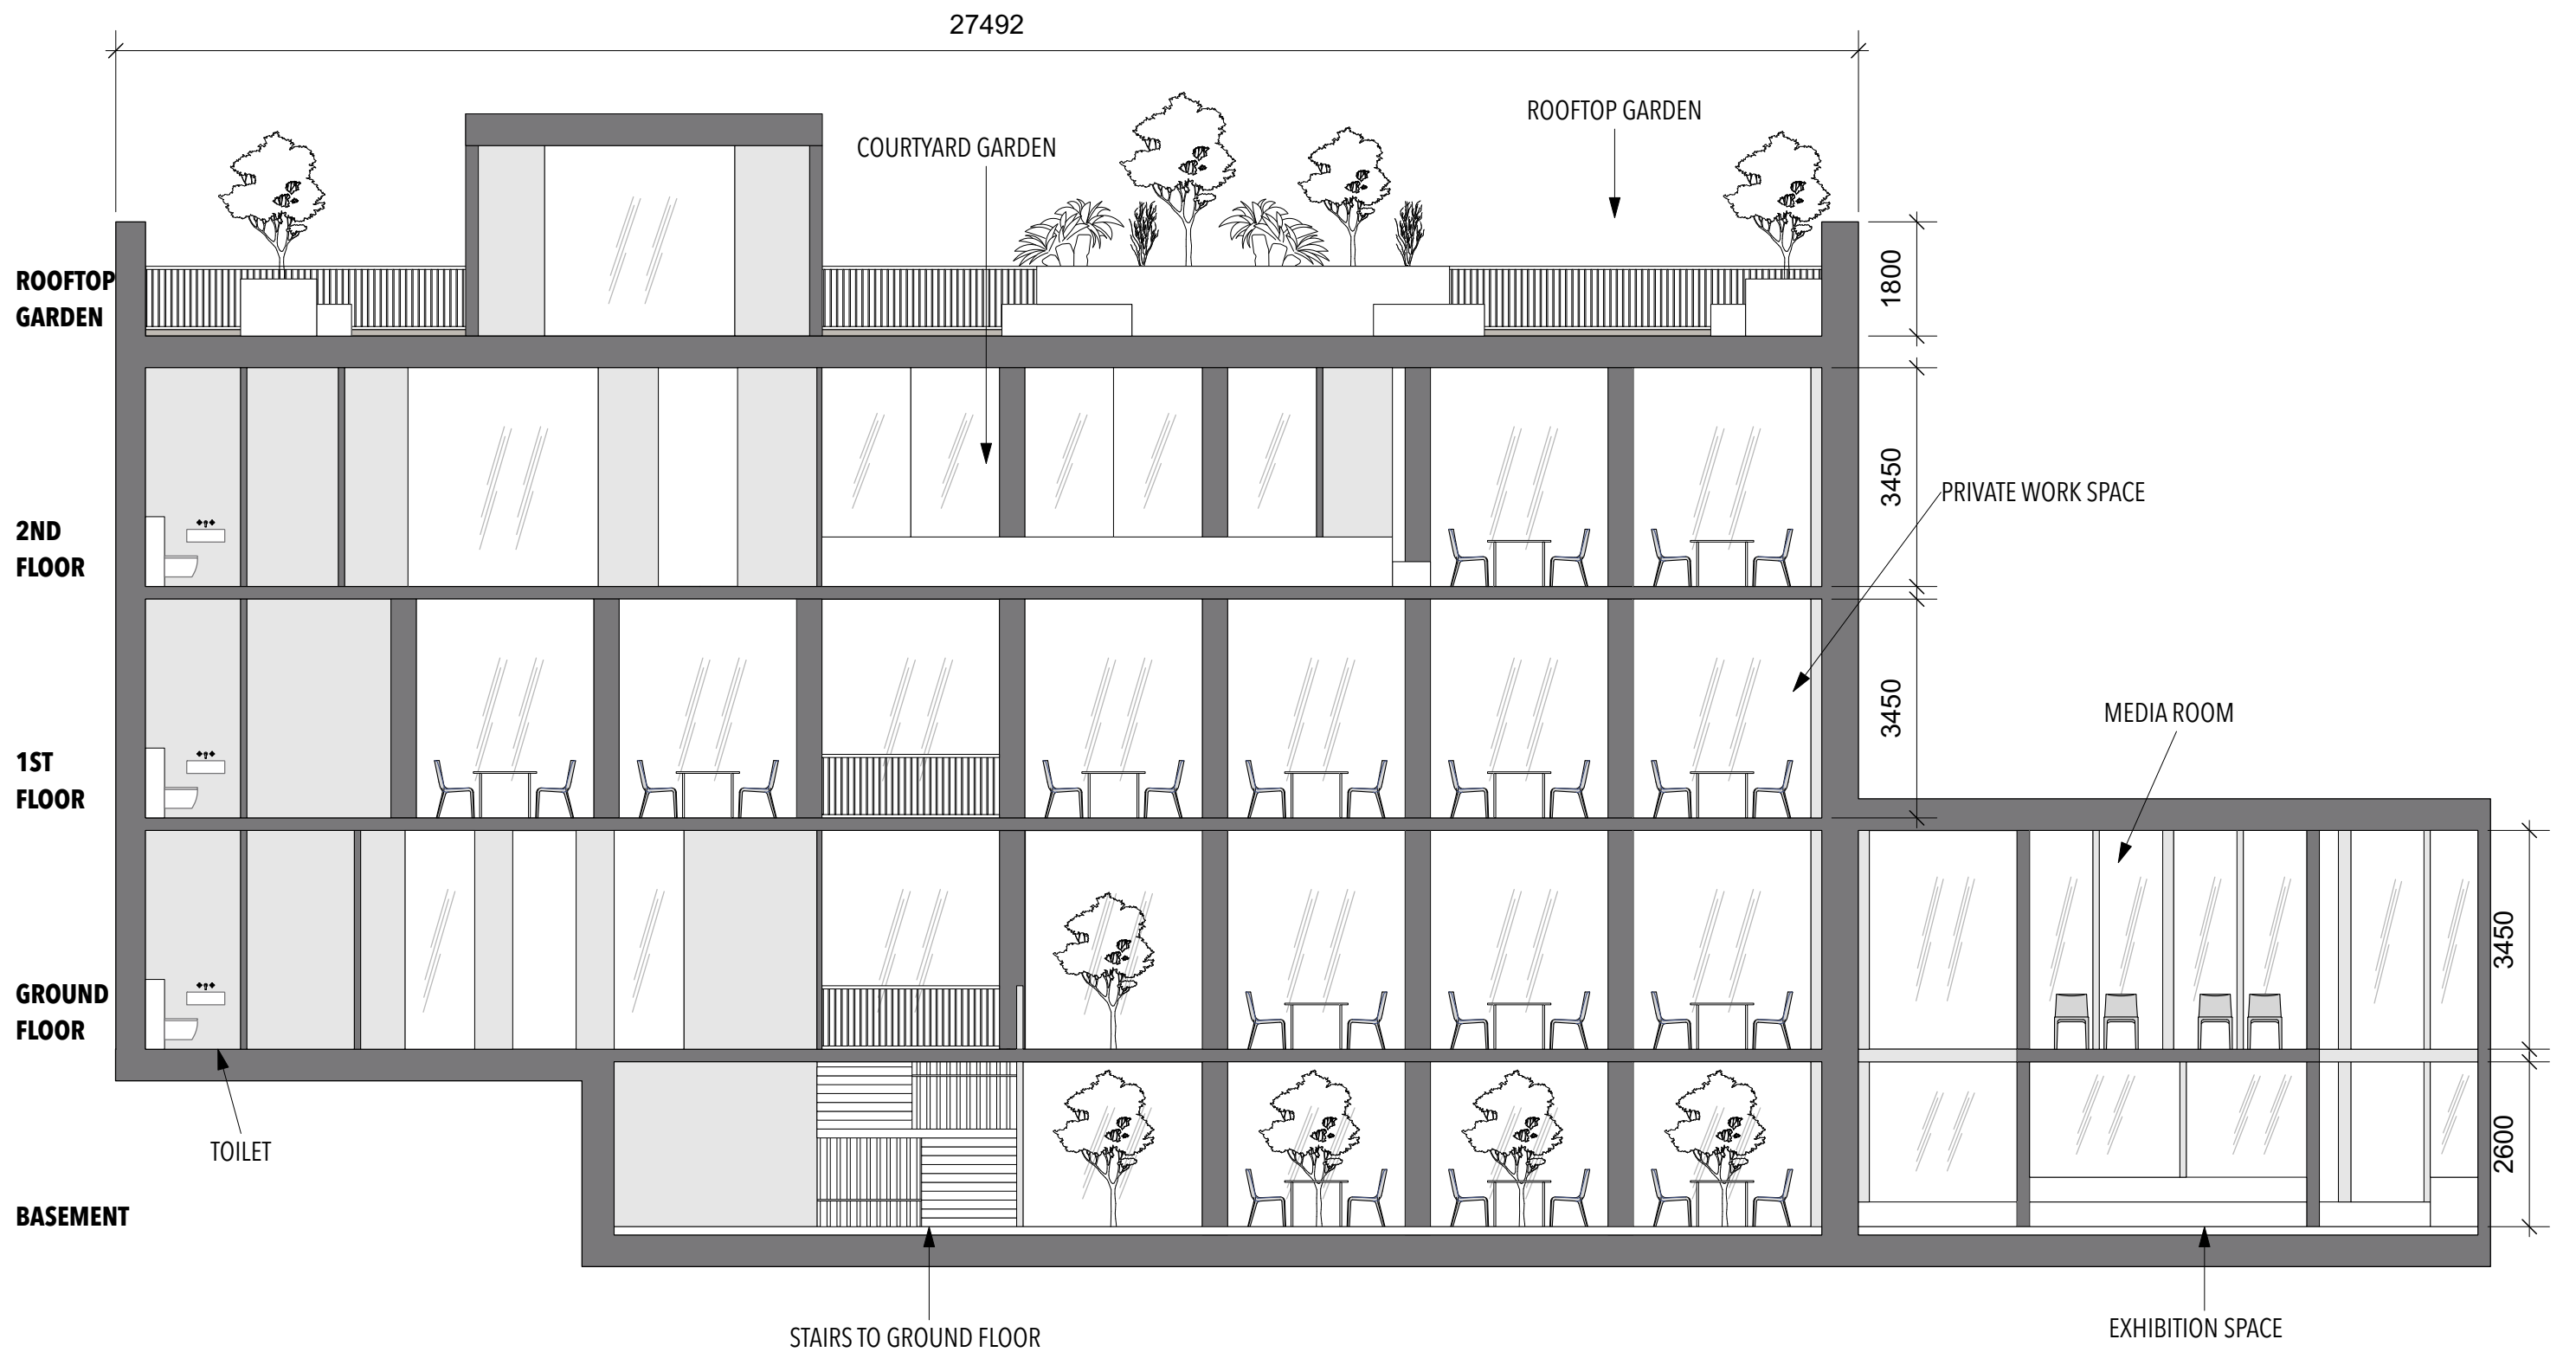

SECTION ELEVATION A-A

SE-01 SCALE 1:100

NOTE:

ALL DIMENSIONS ARE IN MILLIMETERS, UNLESS OTHERWISE STATED.
SO NOT SCALE DIRECT FROM DRAWINGS.
ALL DIMENSIONS TO BE VERIFIED WHEN IN DOUBT.
CONTRACTOR SHALL BE RESPONSIBLE TO VERIFY DIMENSION AT SITE WHERE REQUIRED.

PROJECT: **ZONE AT 45 VYNER STREET, LONDON E2 9DQ**

SCALE: 1:100


DATE: APRIL 2021

DRAWING TITLE: **SECTIONAL ELEVATION A-A**

DRAWN BY: TERRENCE, YUN CHUNG LIN

JOB NO: 01

DRAWING NO: SE-01

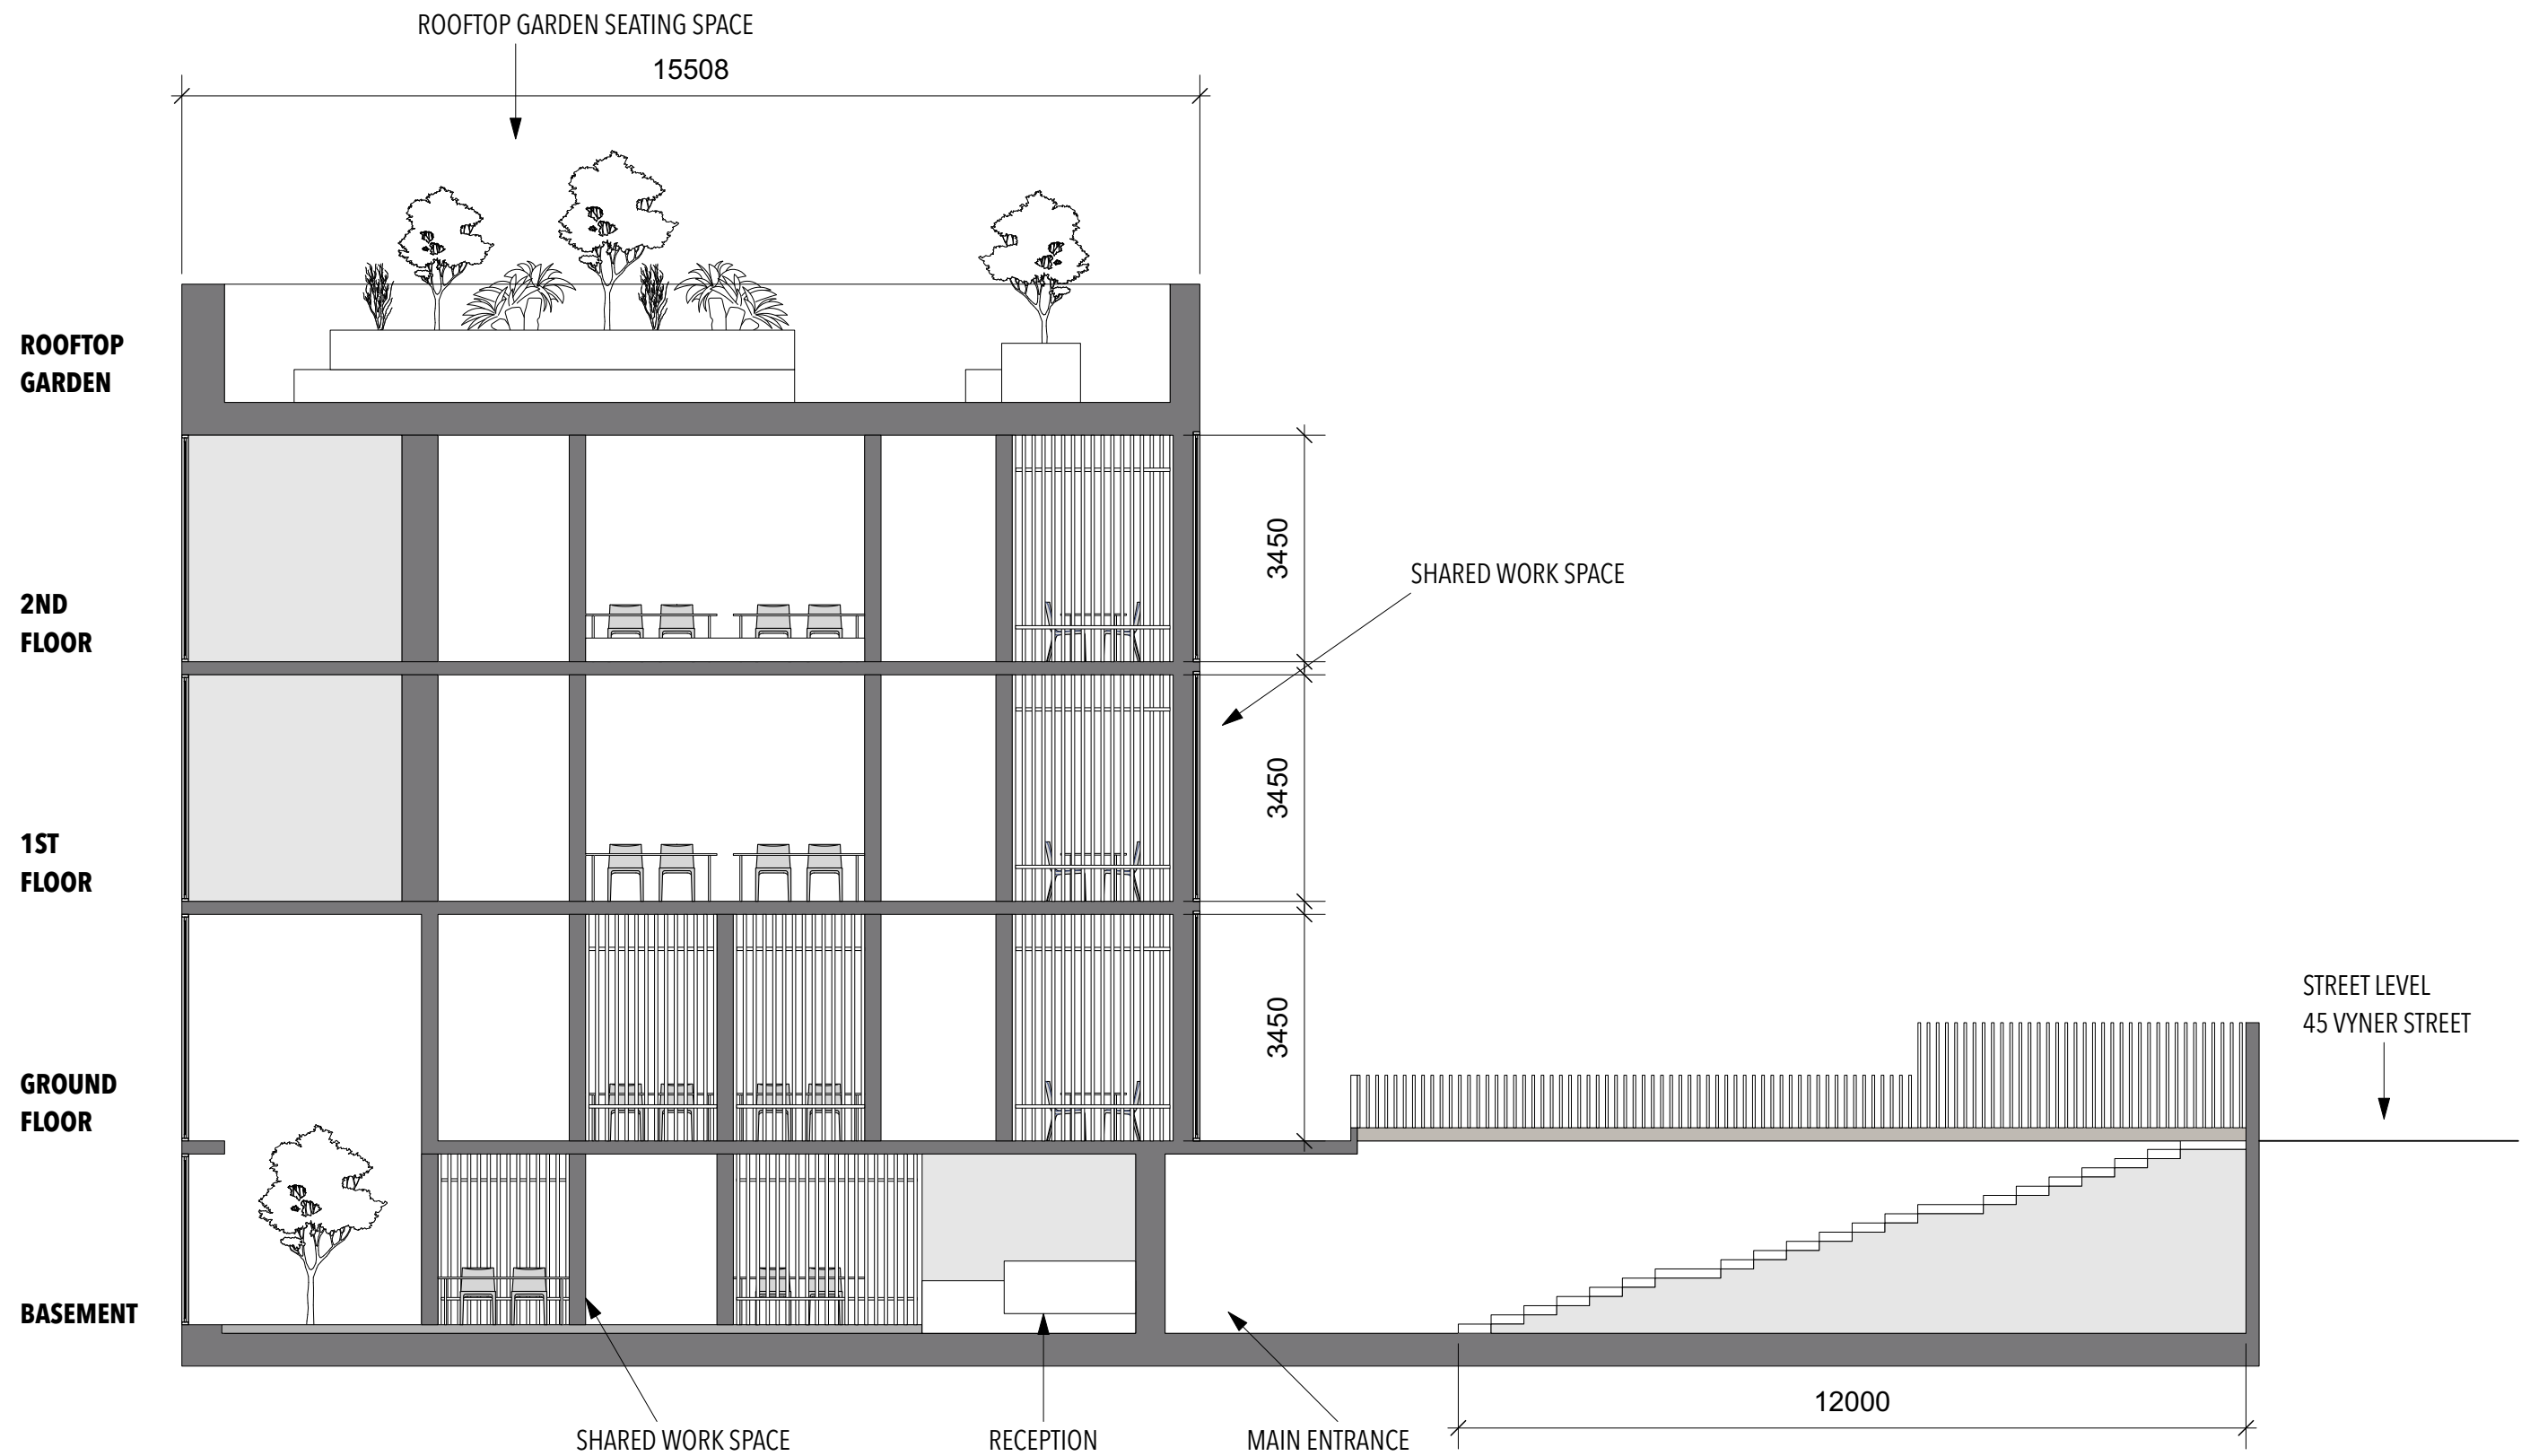

SECTION ELEVATION B-B

SE-02 SCALE 1:100

NOTE:

ALL DIMENSIONS ARE IN MILLIMETERS, UNLESS OTHERWISE STATED.

SO NOT SCALE DIRECT FROM DRAWINGS.

ALL DIMENSIONS TO BE VERIFIED WHEN IN DOUBT.

CONTRACTOR SHALL BE RESPONSIBLE TO VERIFY DIMENSION AT SITE WHERE REQUIRED.

PROJECT: **ZONE AT 45 VYNER STREET, LONDON E2 9DQ**

SCALE: 1:100


DATE: APRIL 2021

DRAWING TITLE: **SECTIONAL ELEVATION B-B**

DRAWN BY: TERRENCE, YUN CHUNG LIN

JOB NO: 01


DRAWING NO: SE-02

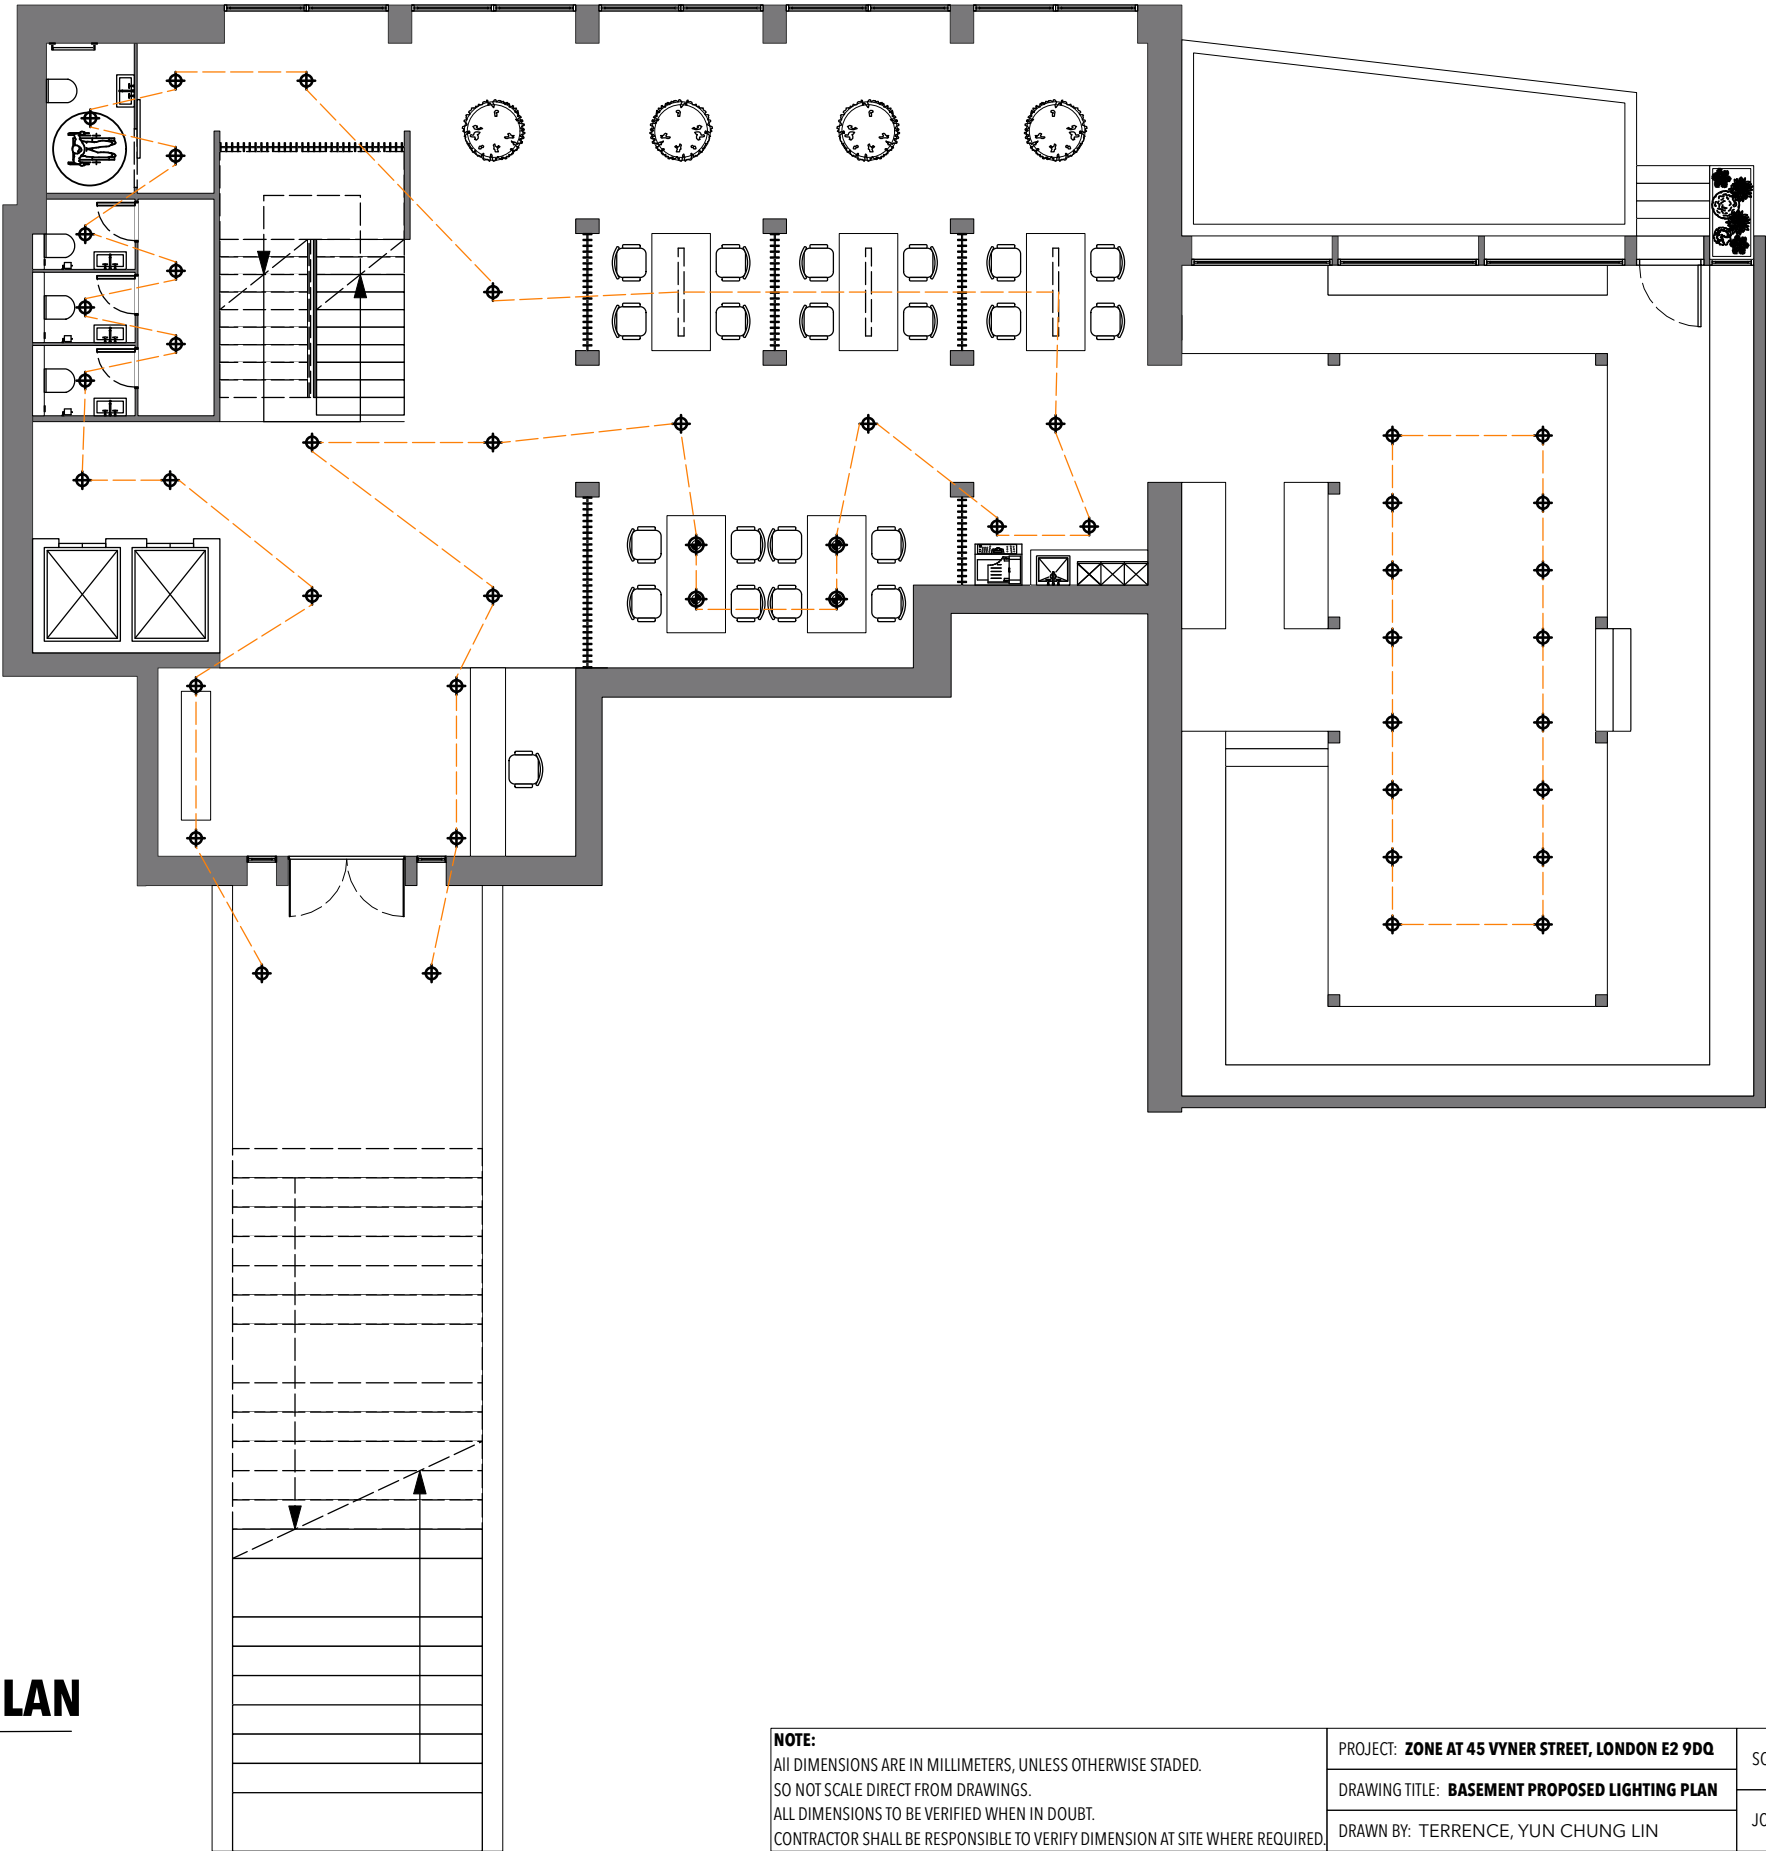

LEGEND	
SYMBOL	DESCRIPTION
	TUBE DOWNLIGHT WITH GLASS COVER
	PENDANT LIGHT
	RECTANGLE SHAPE PENDANT LIGHT
	COVER LIGHT (LED STRIP)


BASEMENT PROPOSED LIGHTING PLAN
LP-00 SCALE 1:125

NOTE: ALL DIMENSIONS ARE IN MILLIMETERS, UNLESS OTHERWISE STATED. SO NOT SCALE DIRECT FROM DRAWINGS. ALL DIMENSIONS TO BE VERIFIED WHEN IN DOUBT. CONTRACTOR SHALL BE RESPONSIBLE TO VERIFY DIMENSION AT SITE WHERE REQUIRED.	PROJECT: ZONE AT 45 VYNER STREET, LONDON E2 9DQ	SCALE: 1:125	DATE: APRIL 2021
	DRAWING TITLE: BASEMENT PROPOSED LIGHTING PLAN	JOB NO: 01	DRAWING NO: LP-00
	DRAWN BY: TERRENCE, YUN CHUNG LIN		

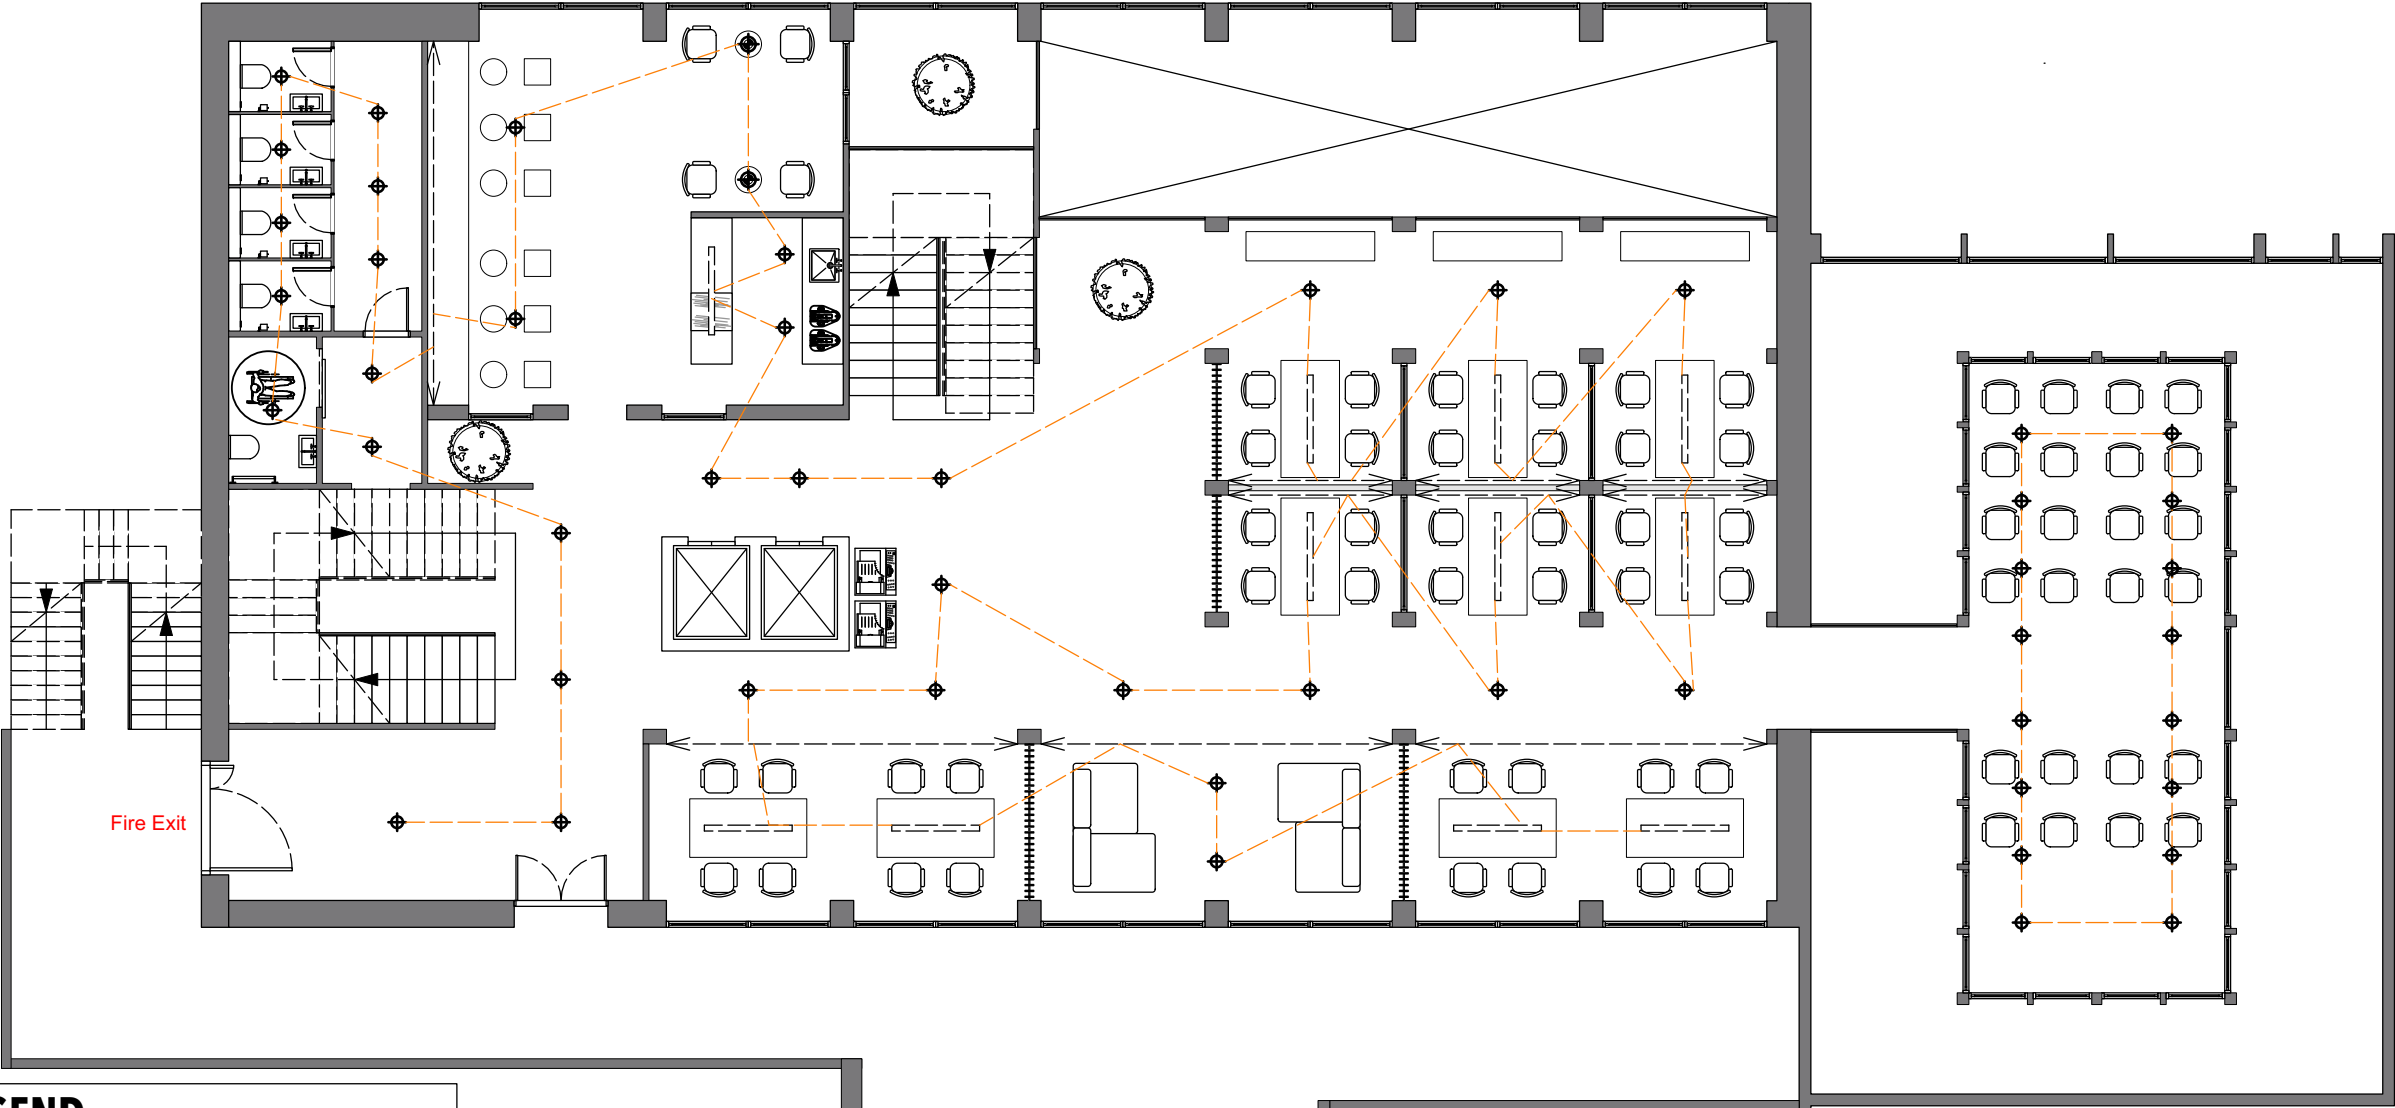


LEGEND	
SYMBOL	DESCRIPTION
	TUBE DOWNLIGHT WITH GLASS COVER
	PENDANT LIGHT
	RECTANGLE SHAPE PENDANT LIGHT
	COVER LIGHT (LED STRIP)

GROUND FLOOR PROPOSED LIGHTING PLAN
LP-01 SCALE 1:125

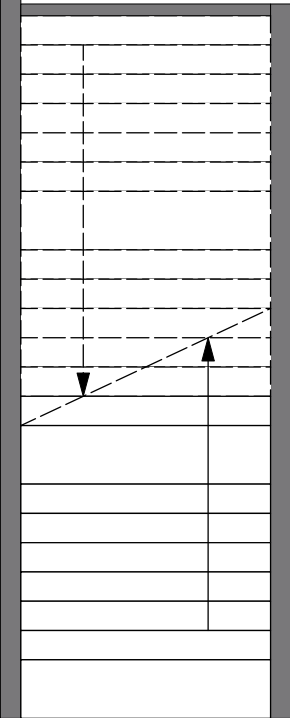

NOTE: ALL DIMENSIONS ARE IN MILLIMETERS, UNLESS OTHERWISE STATED. SO NOT SCALE DIRECT FROM DRAWINGS. ALL DIMENSIONS TO BE VERIFIED WHEN IN DOUBT. CONTRACTOR SHALL BE RESPONSIBLE TO VERIFY DIMENSION AT SITE WHERE REQUIRED.	PROJECT: ZONE AT 45 VYNER STREET, LONDON E2 9DQ	SCALE: 1:125	DATE: APRIL 2021
	DRAWING TITLE: GROUND FLOOR PROPOSED LIGHTING PLAN	JOB NO: 01	DRAWING NO: LP-01
	DRAWN BY: TERRENCE, YUN CHUNG LIN		

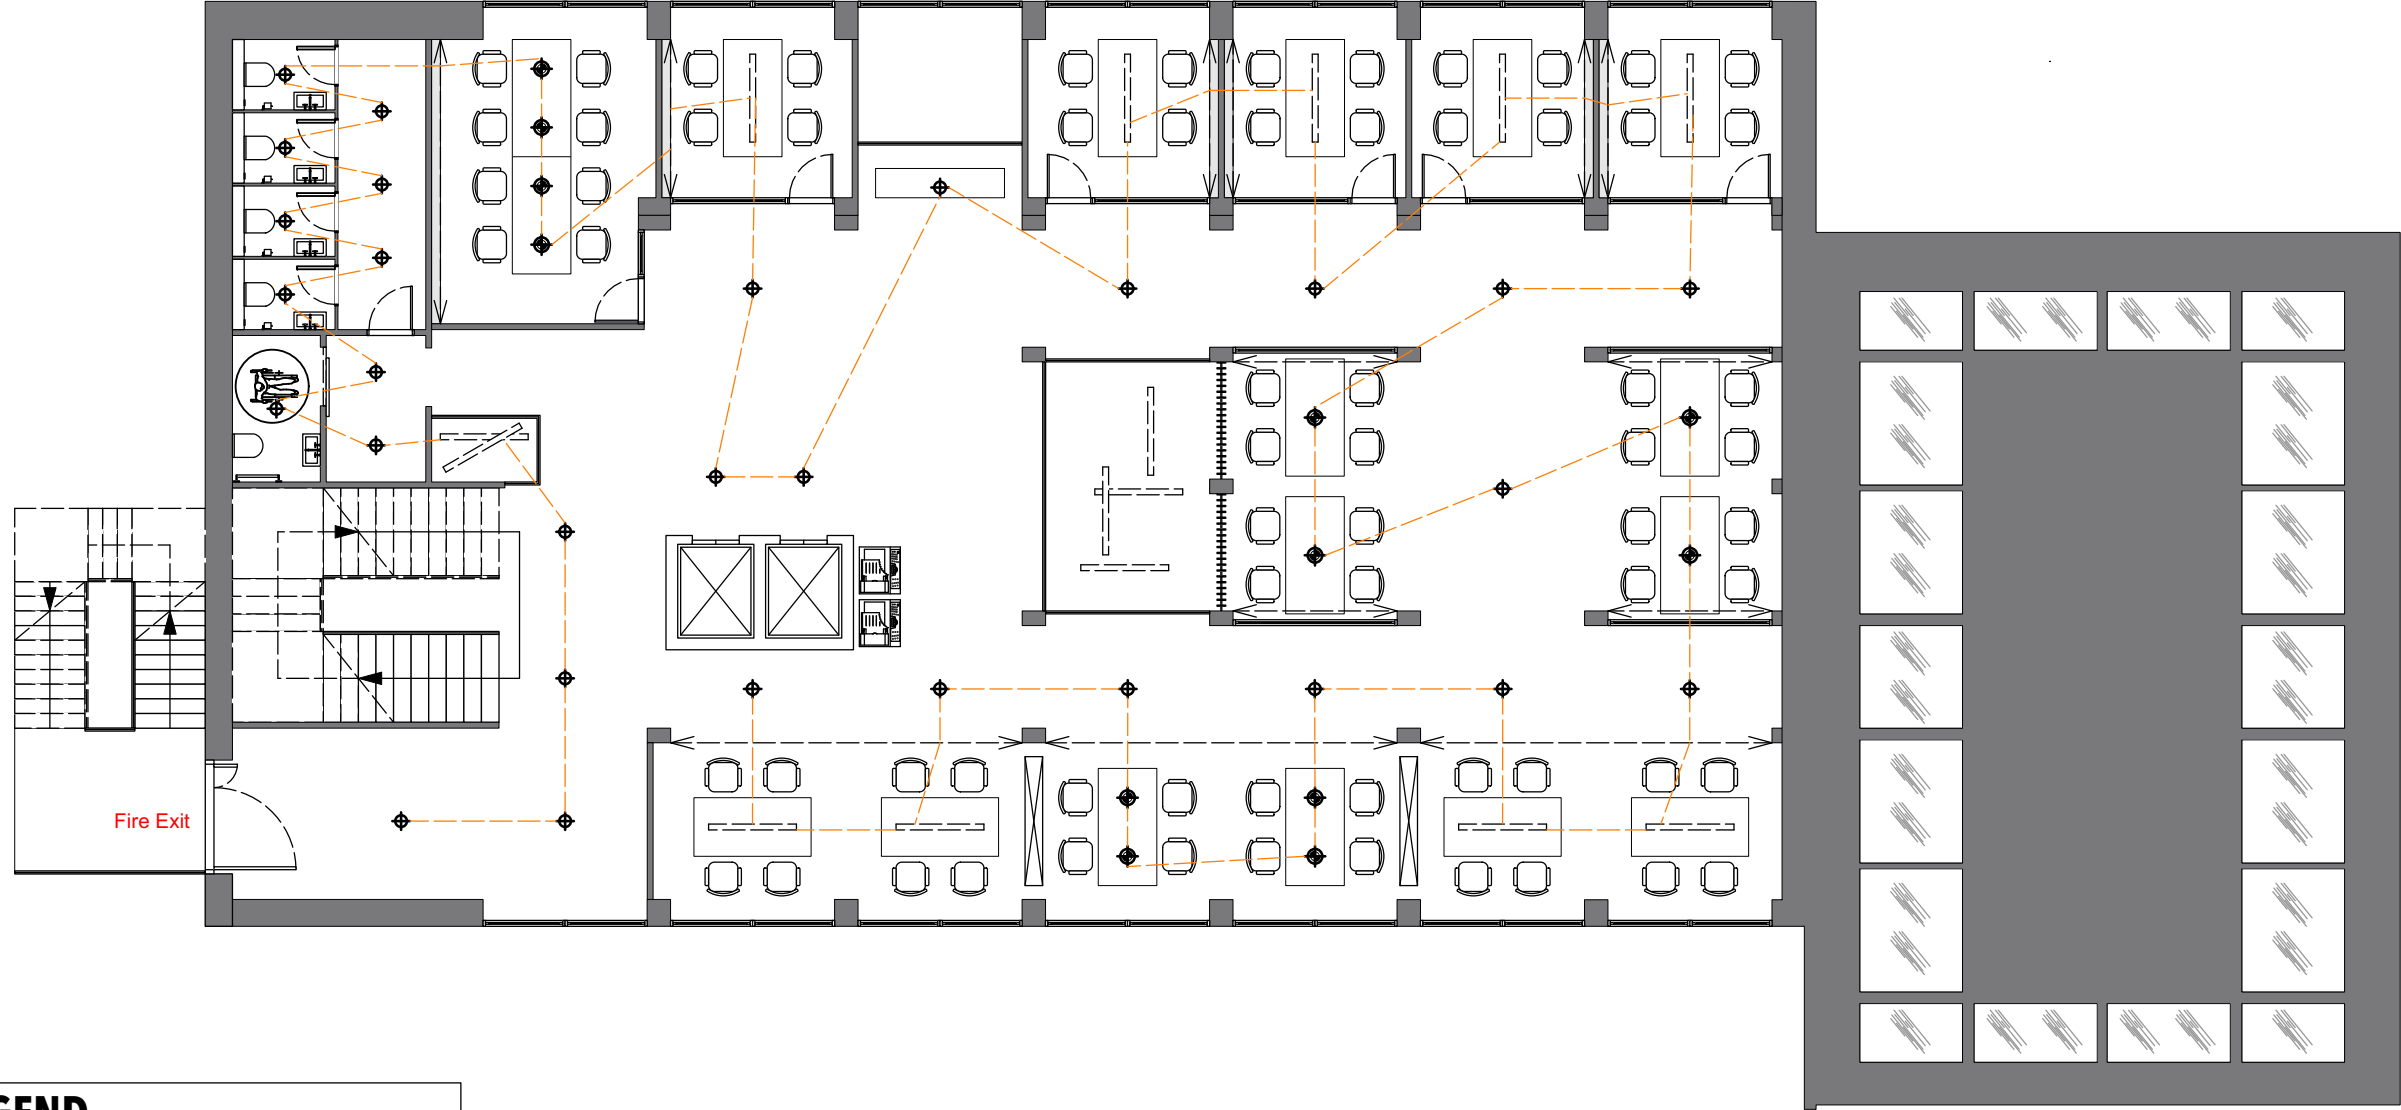


LEGEND	
SYMBOL	DESCRIPTION
	TUBE DOWNLIGHT WITH GLASS COVER
	PENDANT LIGHT
	RECTANGLE SHAPE PENDANT LIGHT
	COVER LIGHT (LED STRIP)

1ST FLOOR PROPOSED LIGHTING PLAN

LP-02 SCALE 1:125

NOTE: ALL DIMENSIONS ARE IN MILLIMETERS, UNLESS OTHERWISE STATED. SO NOT SCALE DIRECT FROM DRAWINGS. ALL DIMENSIONS TO BE VERIFIED WHEN IN DOUBT. CONTRACTOR SHALL BE RESPONSIBLE TO VERIFY DIMENSION AT SITE WHERE REQUIRED.	PROJECT: ZONE AT 45 VYNER STREET, LONDON E2 9DQ	SCALE: 1:125	DATE: APRIL 2021
	DRAWING TITLE: 1ST FLOOR PROPOSED LIGHTING PLAN	JOB NO: 01	DRAWING NO: LP-02
	DRAWN BY: TERRENCE, YUN CHUNG LIN		

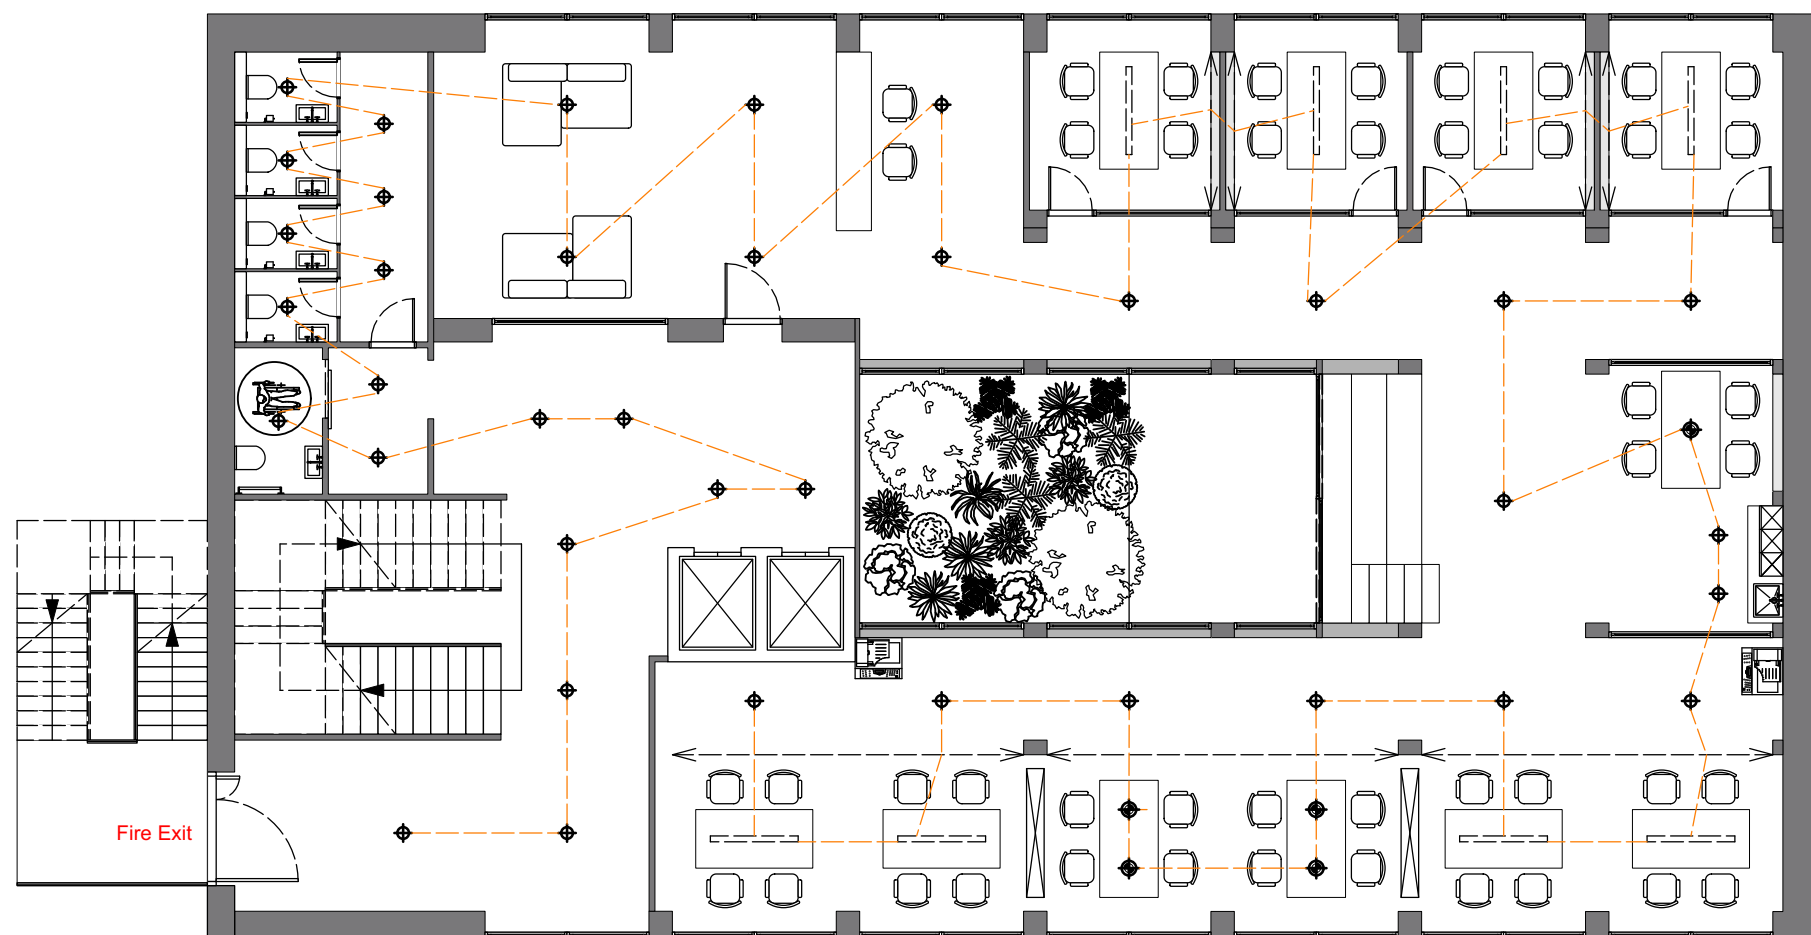


LEGEND	
SYMBOL	DESCRIPTION
	TUBE DOWNLIGHT WITH GLASS COVER
	PENDANT LIGHT
	RECTANGLE SHAPE PENDANT LIGHT
	COVER LIGHT (LED STRIP)

2ND FLOOR PROPOSED LIGHTING PLAN

LP-03 SCALE 1:125

NOTE: ALL DIMENSIONS ARE IN MILLIMETERS, UNLESS OTHERWISE STATED. SO NOT SCALE DIRECT FROM DRAWINGS. ALL DIMENSIONS TO BE VERIFIED WHEN IN DOUBT. CONTRACTOR SHALL BE RESPONSIBLE TO VERIFY DIMENSION AT SITE WHERE REQUIRED.	PROJECT: ZONE AT 45 VYNER STREET, LONDON E2 9DQ	SCALE: 1:125	DATE: APRIL 2021
	DRAWING TITLE: 2ND FLOOR PROPOSED LIGHTING PLAN	JOB NO: 01	DRAWING NO: LP-03
	DRAWN BY: TERRENCE, YUN CHUNG LIN		

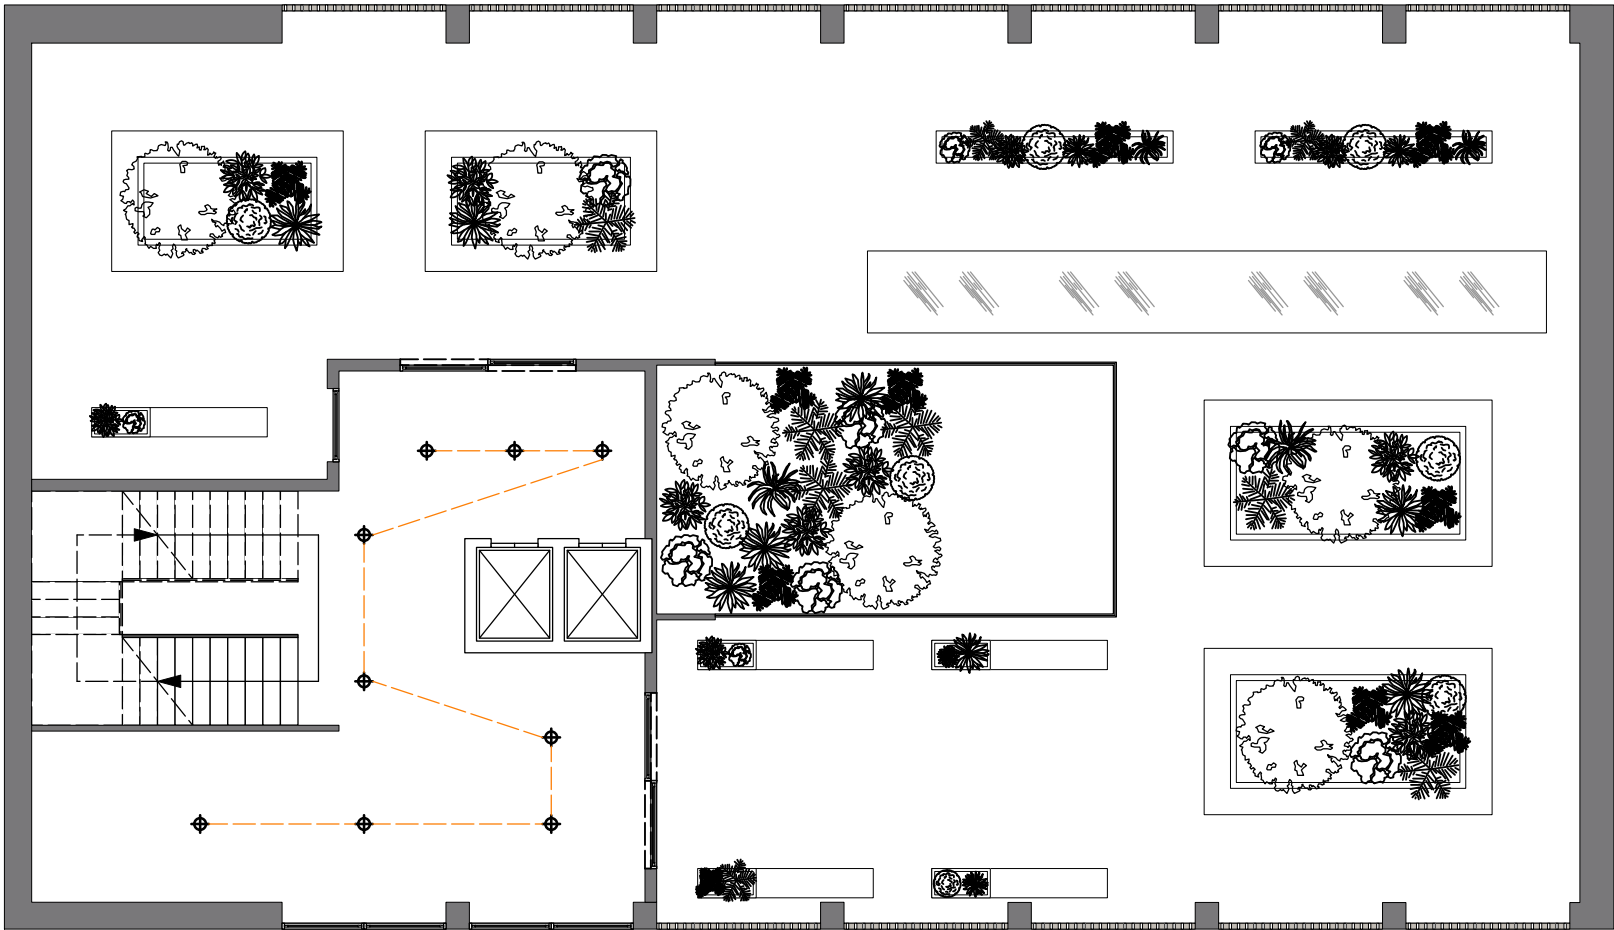


LEGEND	
SYMBOL	DESCRIPTION
	TUBE DOWNLIGHT WITH GLASS COVER
	PENDANT LIGHT
	RECTANGLE SHAPE PENDANT LIGHT
	COVER LIGHT (LED STRIP)

ROOFTOP PROPOSED LIGHTING PLAN

LP-04 SCALE 1:125

NOTE: ALL DIMENSIONS ARE IN MILLIMETERS, UNLESS OTHERWISE STATED. SO NOT SCALE DIRECT FROM DRAWINGS. ALL DIMENSIONS TO BE VERIFIED WHEN IN DOUBT. CONTRACTOR SHALL BE RESPONSIBLE TO VERIFY DIMENSION AT SITE WHERE REQUIRED.	PROJECT: ZONE AT 45 VYNER STREET, LONDON E2 9DQ	SCALE: 1:125	DATE: APRIL 2021
	DRAWING TITLE: ROOFTOP PROPOSED LIGHTING PLAN	JOB NO: 01	DRAWING NO: LP-04
	DRAWN BY: TERRENCE, YUN CHUNG LIN		

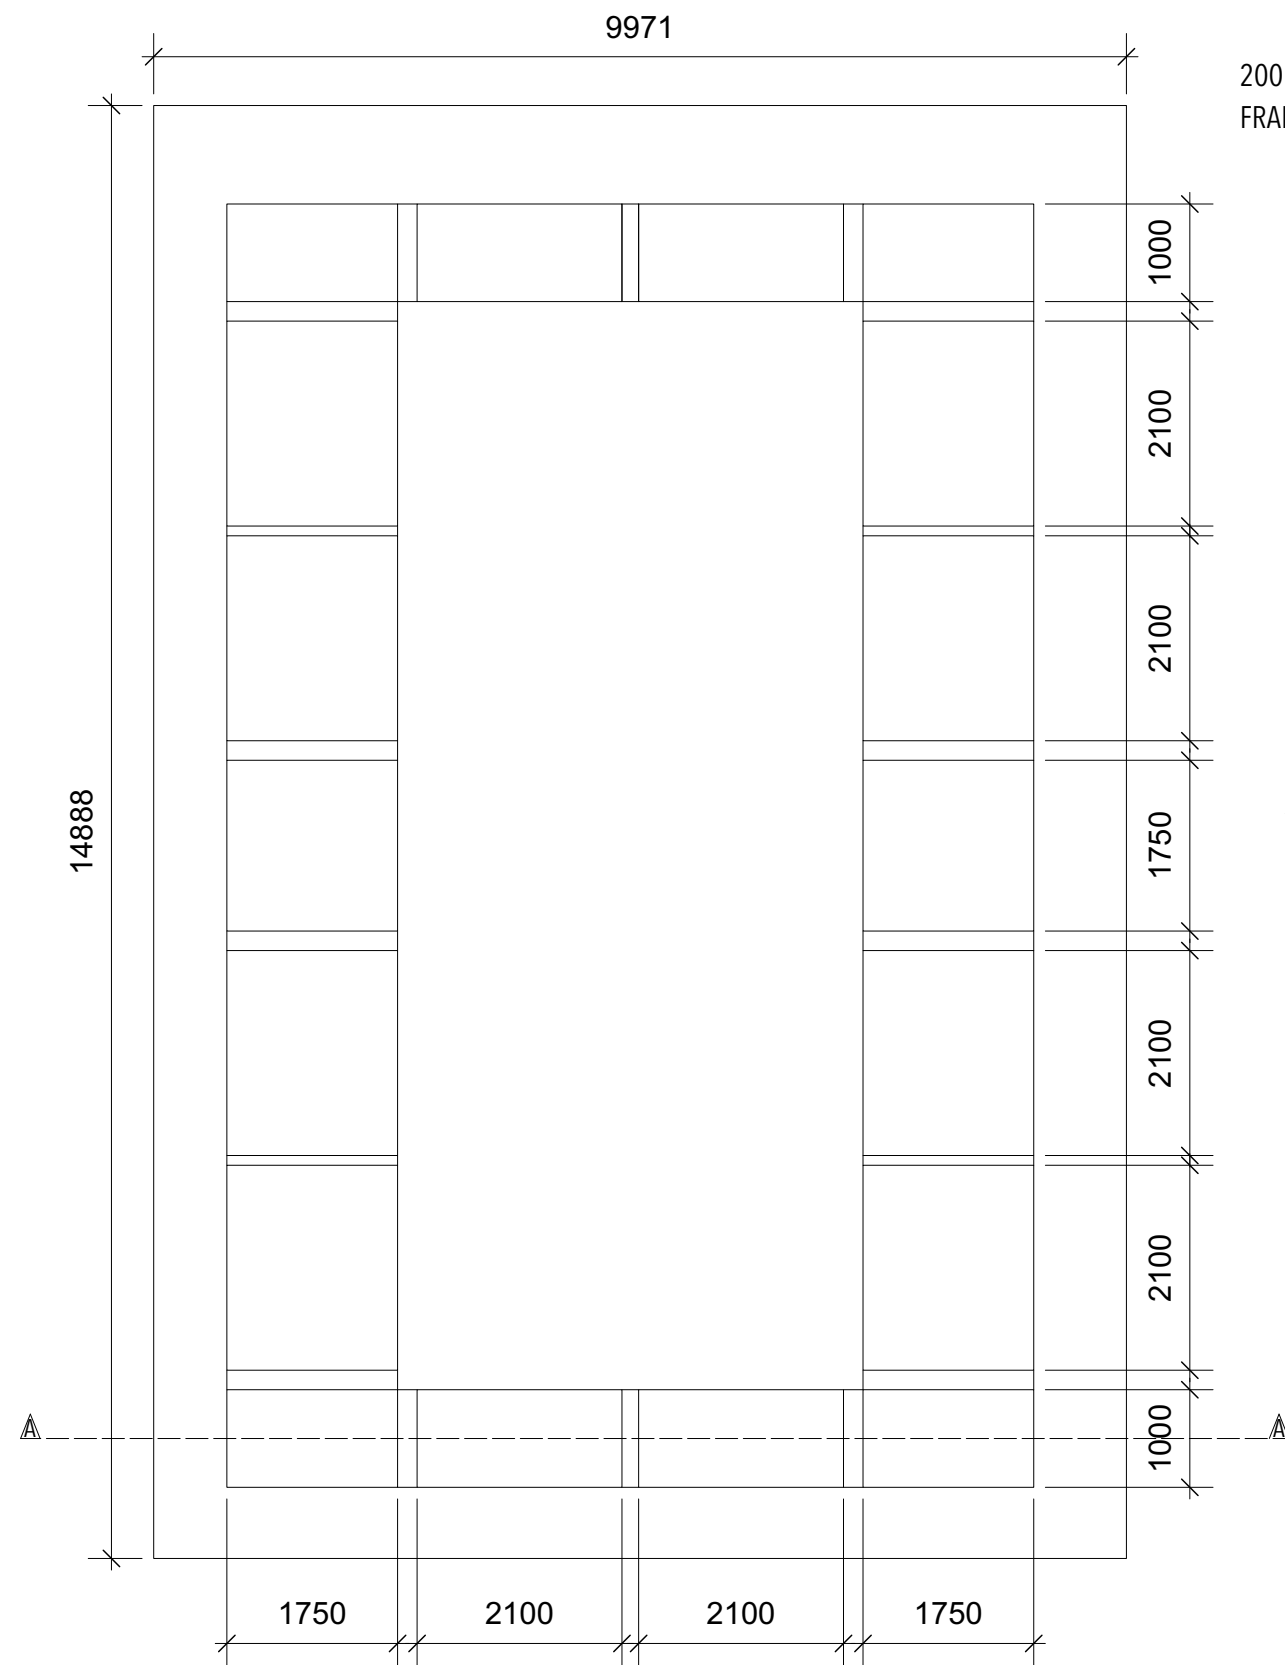


PLAN SCALE 1:75

DOUBLE GLAZED FLAT SKYLIGHT ROOF DETAILING

DE - 01 SCALE AS SHOWN

200MM THK BLACK ALUMINUM GLASS
FRAME FIXED TO CURB

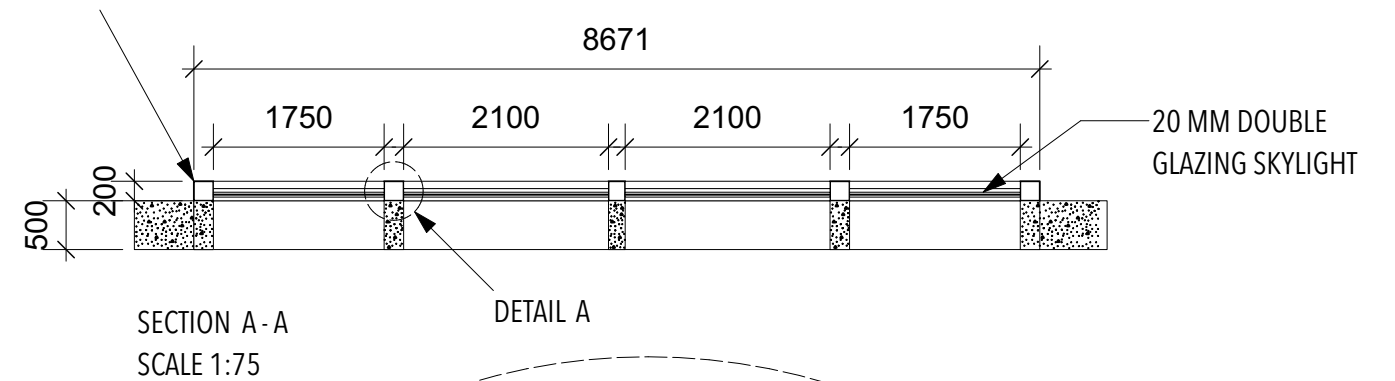

ALUMINUM SNAP CAP
ALUMINUM PESSURE CAP

GLAZING

GLAZING GASKET

FASTENER
ALUMINUM PURLIN CLIP

ALUMINUM

DETAIL A
SCALE 1:2

NOTE:

ALL DIMENSIONS ARE IN MILLIMETERS, UNLESS OTHERWISE STATED.

SO NOT SCALE DIRECT FROM DRAWINGS.

ALL DIMENSIONS TO BE VERIFIED WHEN IN DOUBT.

CONTRACTOR SHALL BE RESPONSIBLE TO VERIFY DIMENSION AT SITE WHERE REQUIRED.

PROJECT: **ZONE AT 45 VYNER STREET, LONDON E2 9DQ**

DRAWING TITLE: **DOUBLE GLAZE SKYLIGHT DETAILING**




DRAWN BY: **TERRENCE, YUN CHUNG LIN**

SCALE: AS SHOWN

DATE: APRIL 2021

JOB NO: 01

DRAWING NO: DE-01

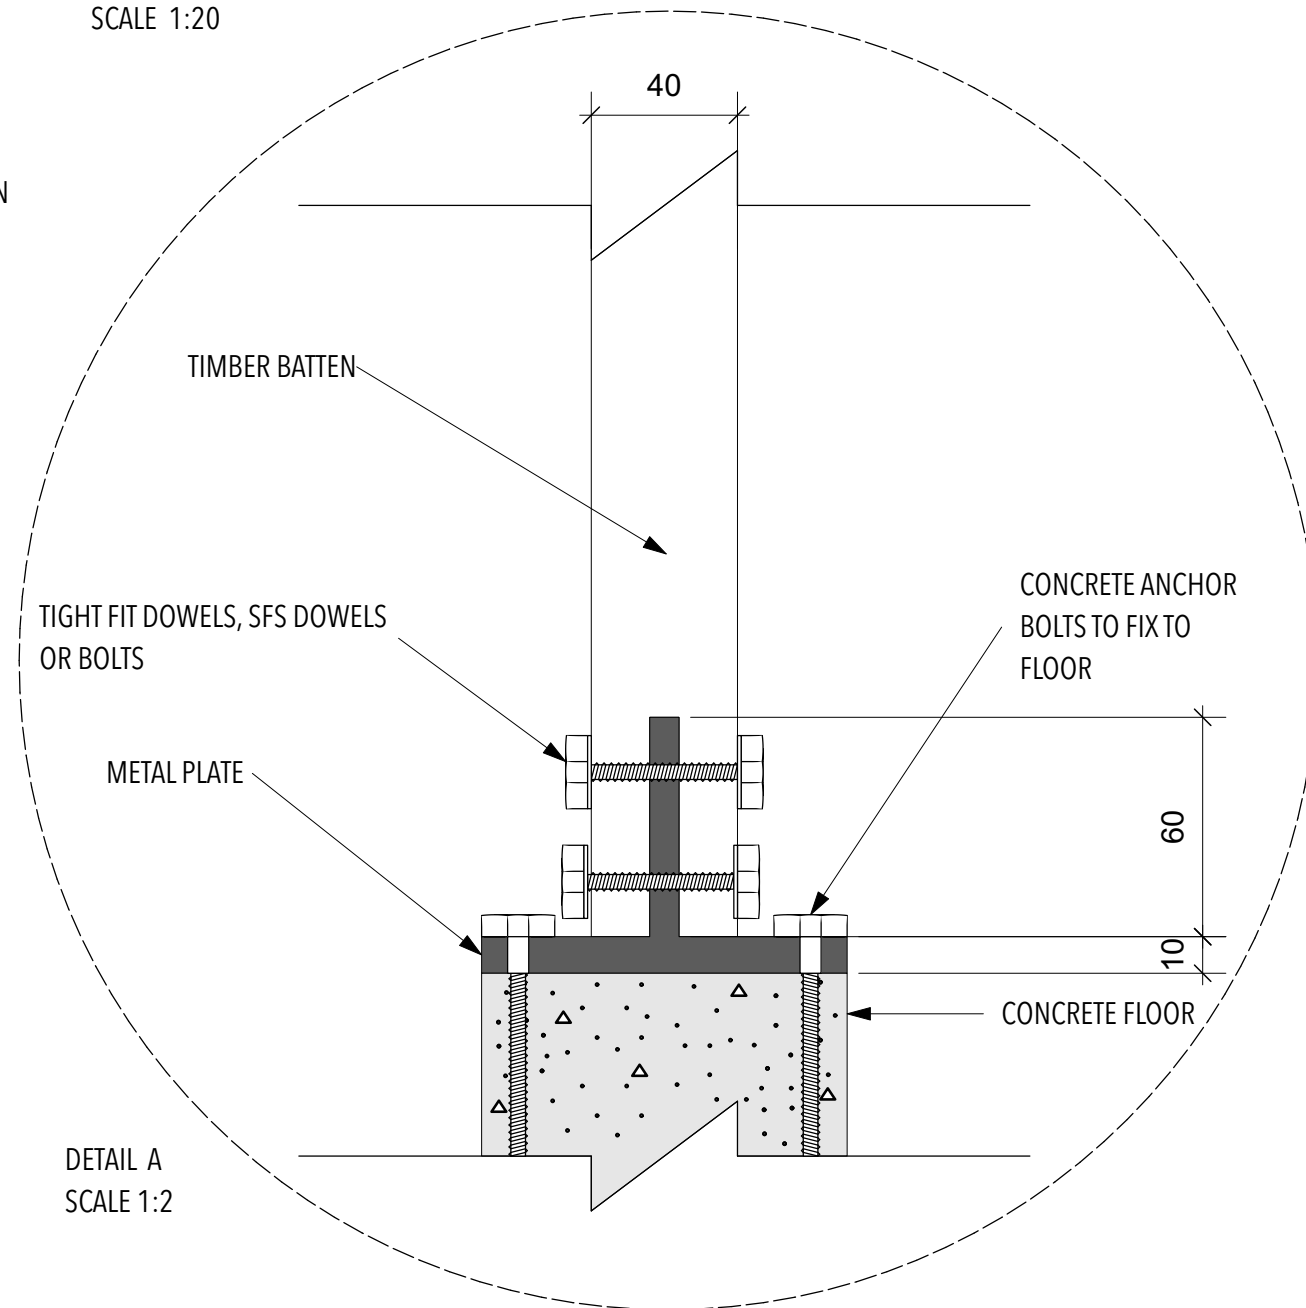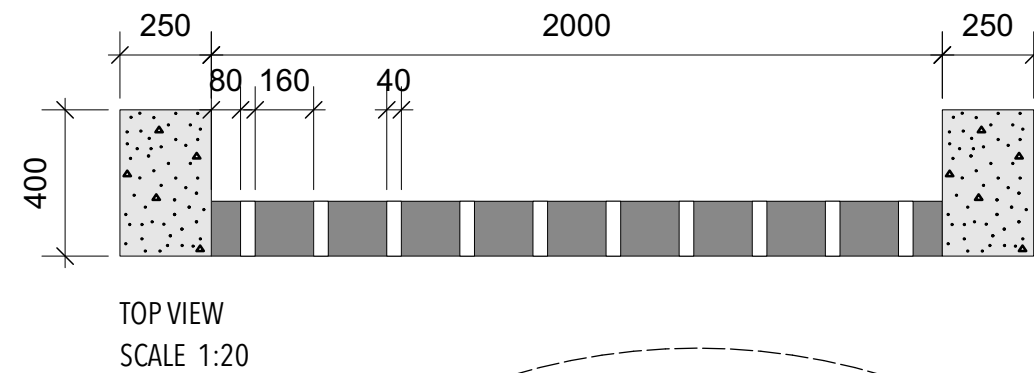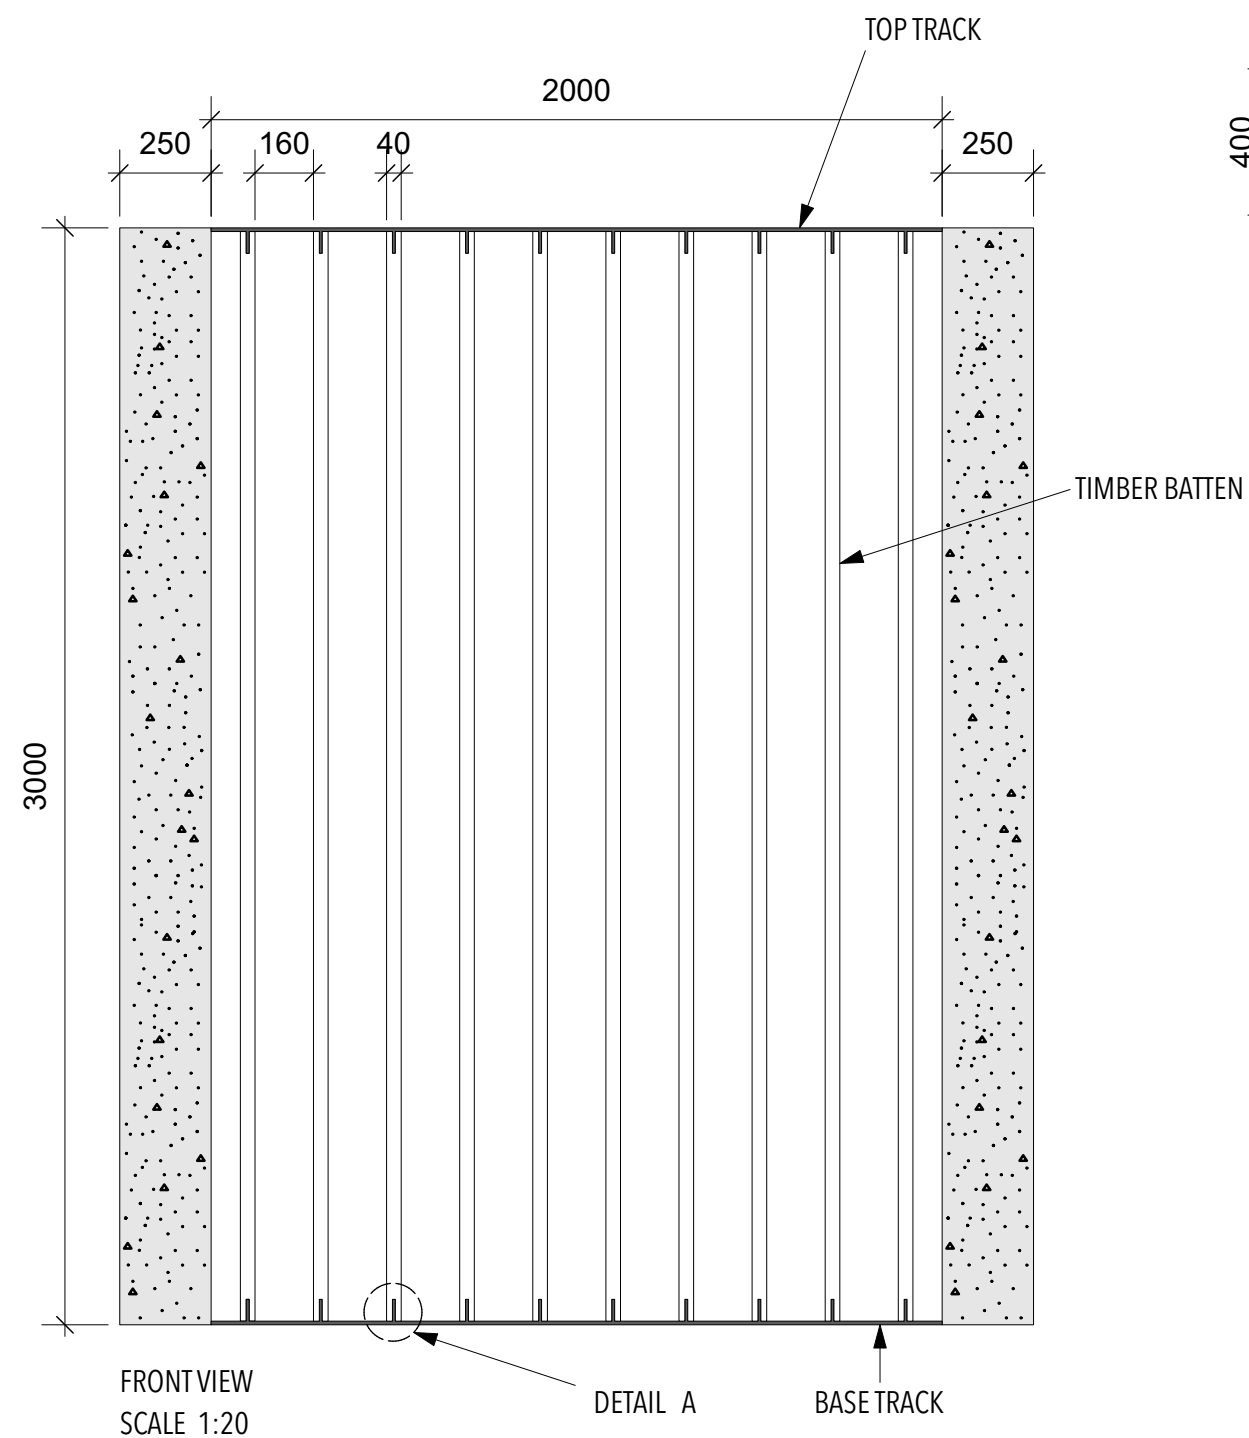

WOOD DIVIDER DETAILING

DE - 02 SCALE AS SHOWN

NOTE:

ALL DIMENSIONS ARE IN MILLIMETERS, UNLESS OTHERWISE STATED.
SO NOT SCALE DIRECT FROM DRAWINGS.
ALL DIMENSIONS TO BE VERIFIED WHEN IN DOUBT.
CONTRACTOR SHALL BE RESPONSIBLE TO VERIFY DIMENSION AT SITE WHERE REQUIRED.

PROJECT: **ZONE AT 45 VYNER STREET, LONDON E2 9DQ**

SCALE: AS SHOWN


DATE: APRIL 2021

DRAWING TITLE: **WOOD DIVIDER DETAILING**


DRAWN BY: TERRENCE, YUN CHUNG LIN

JOB NO: 01


DRAWING NO: DE-02

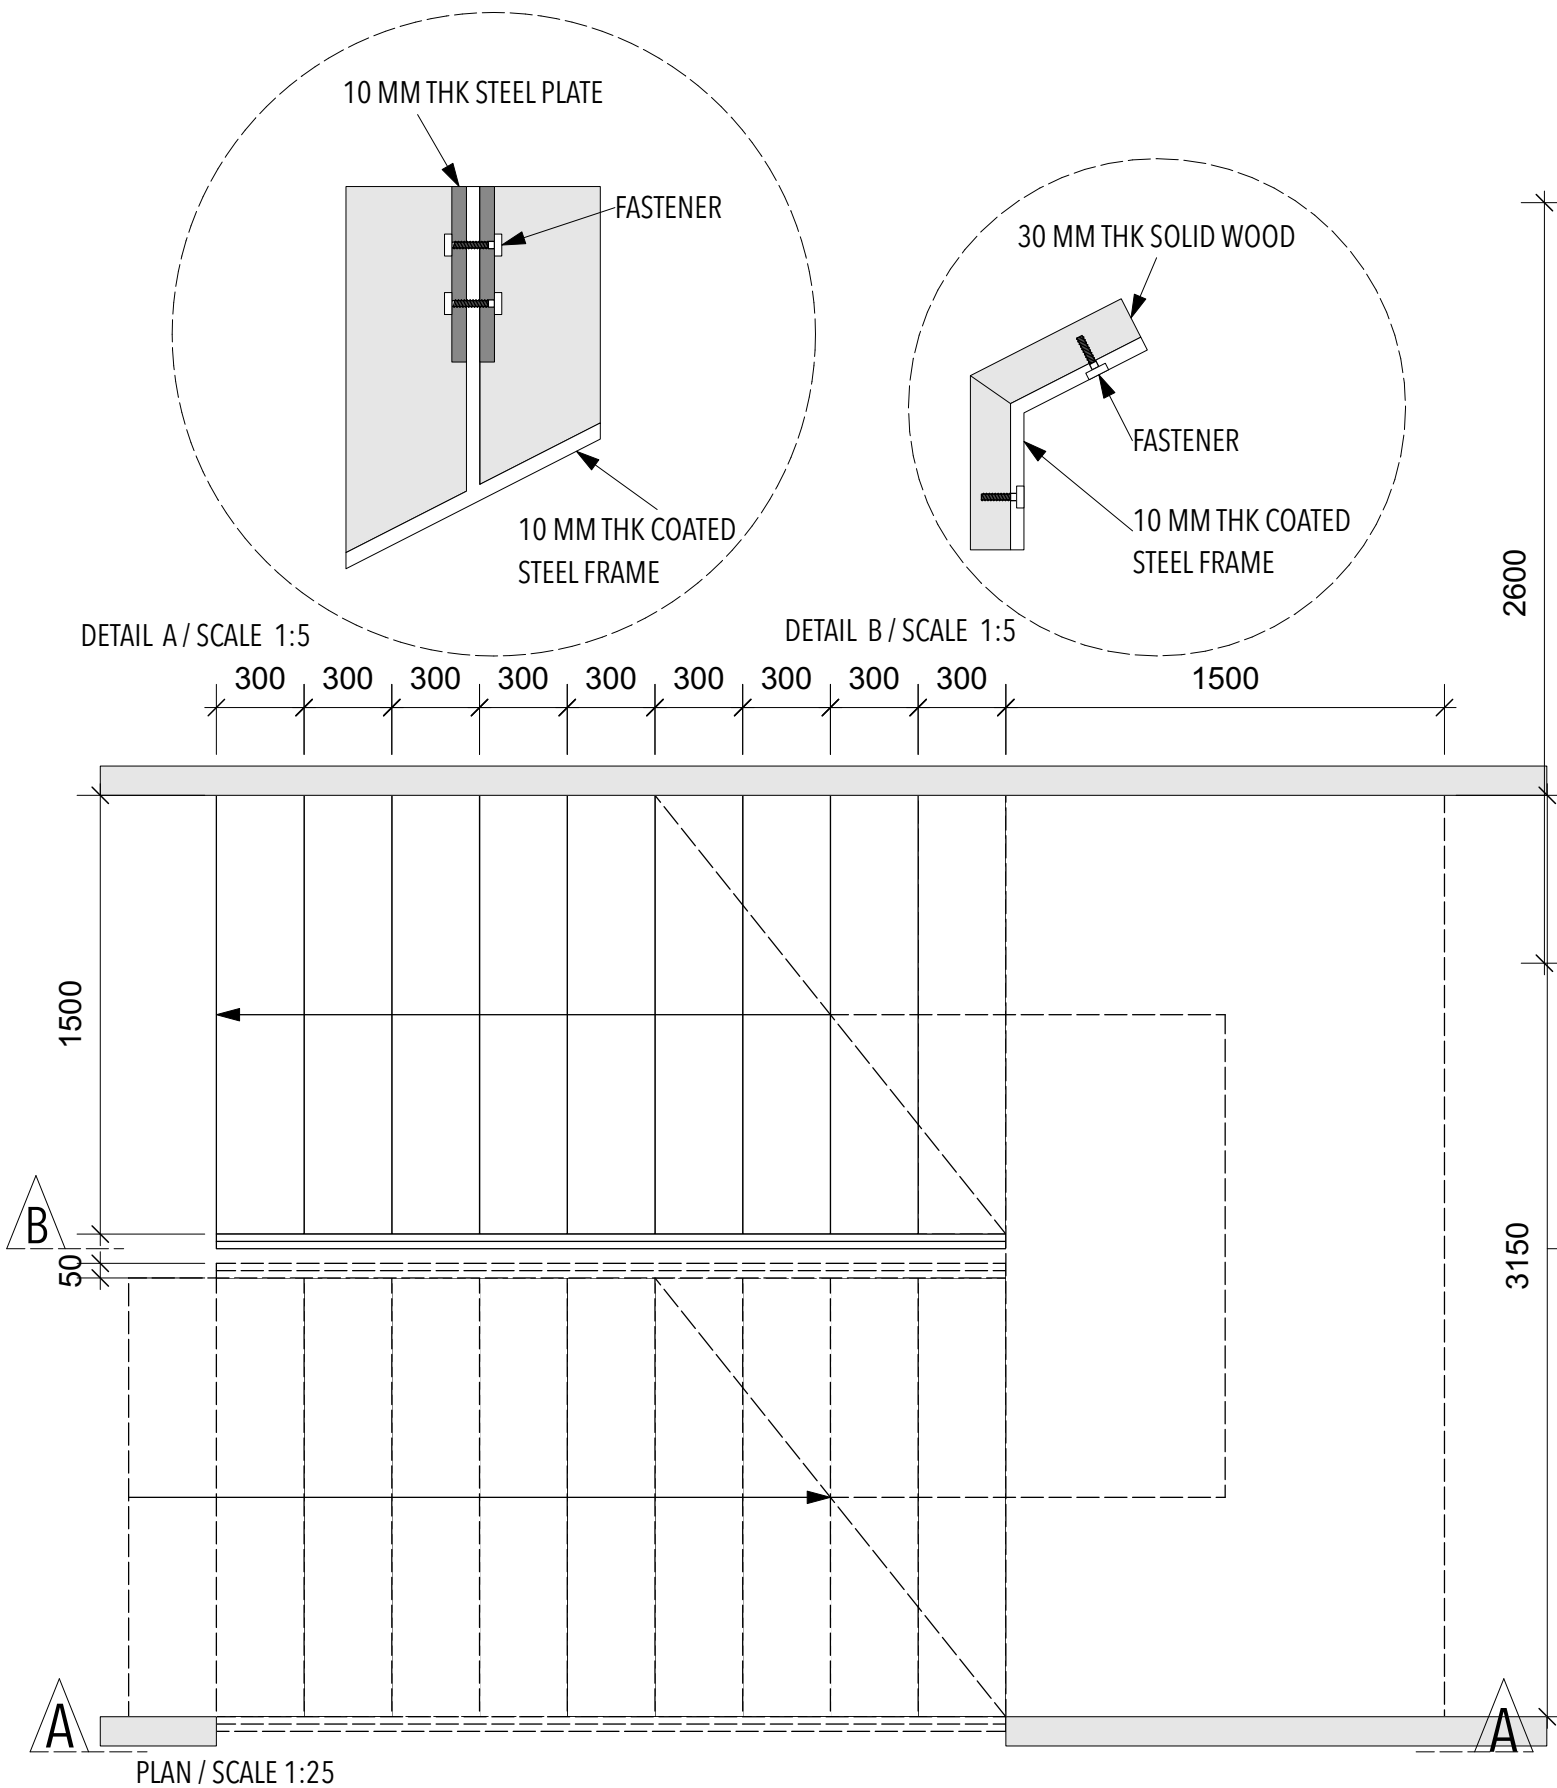


GROUND FLOOR STAIR HANDRAIL DETAILING
DE - 03 SCALE AS SHOWN

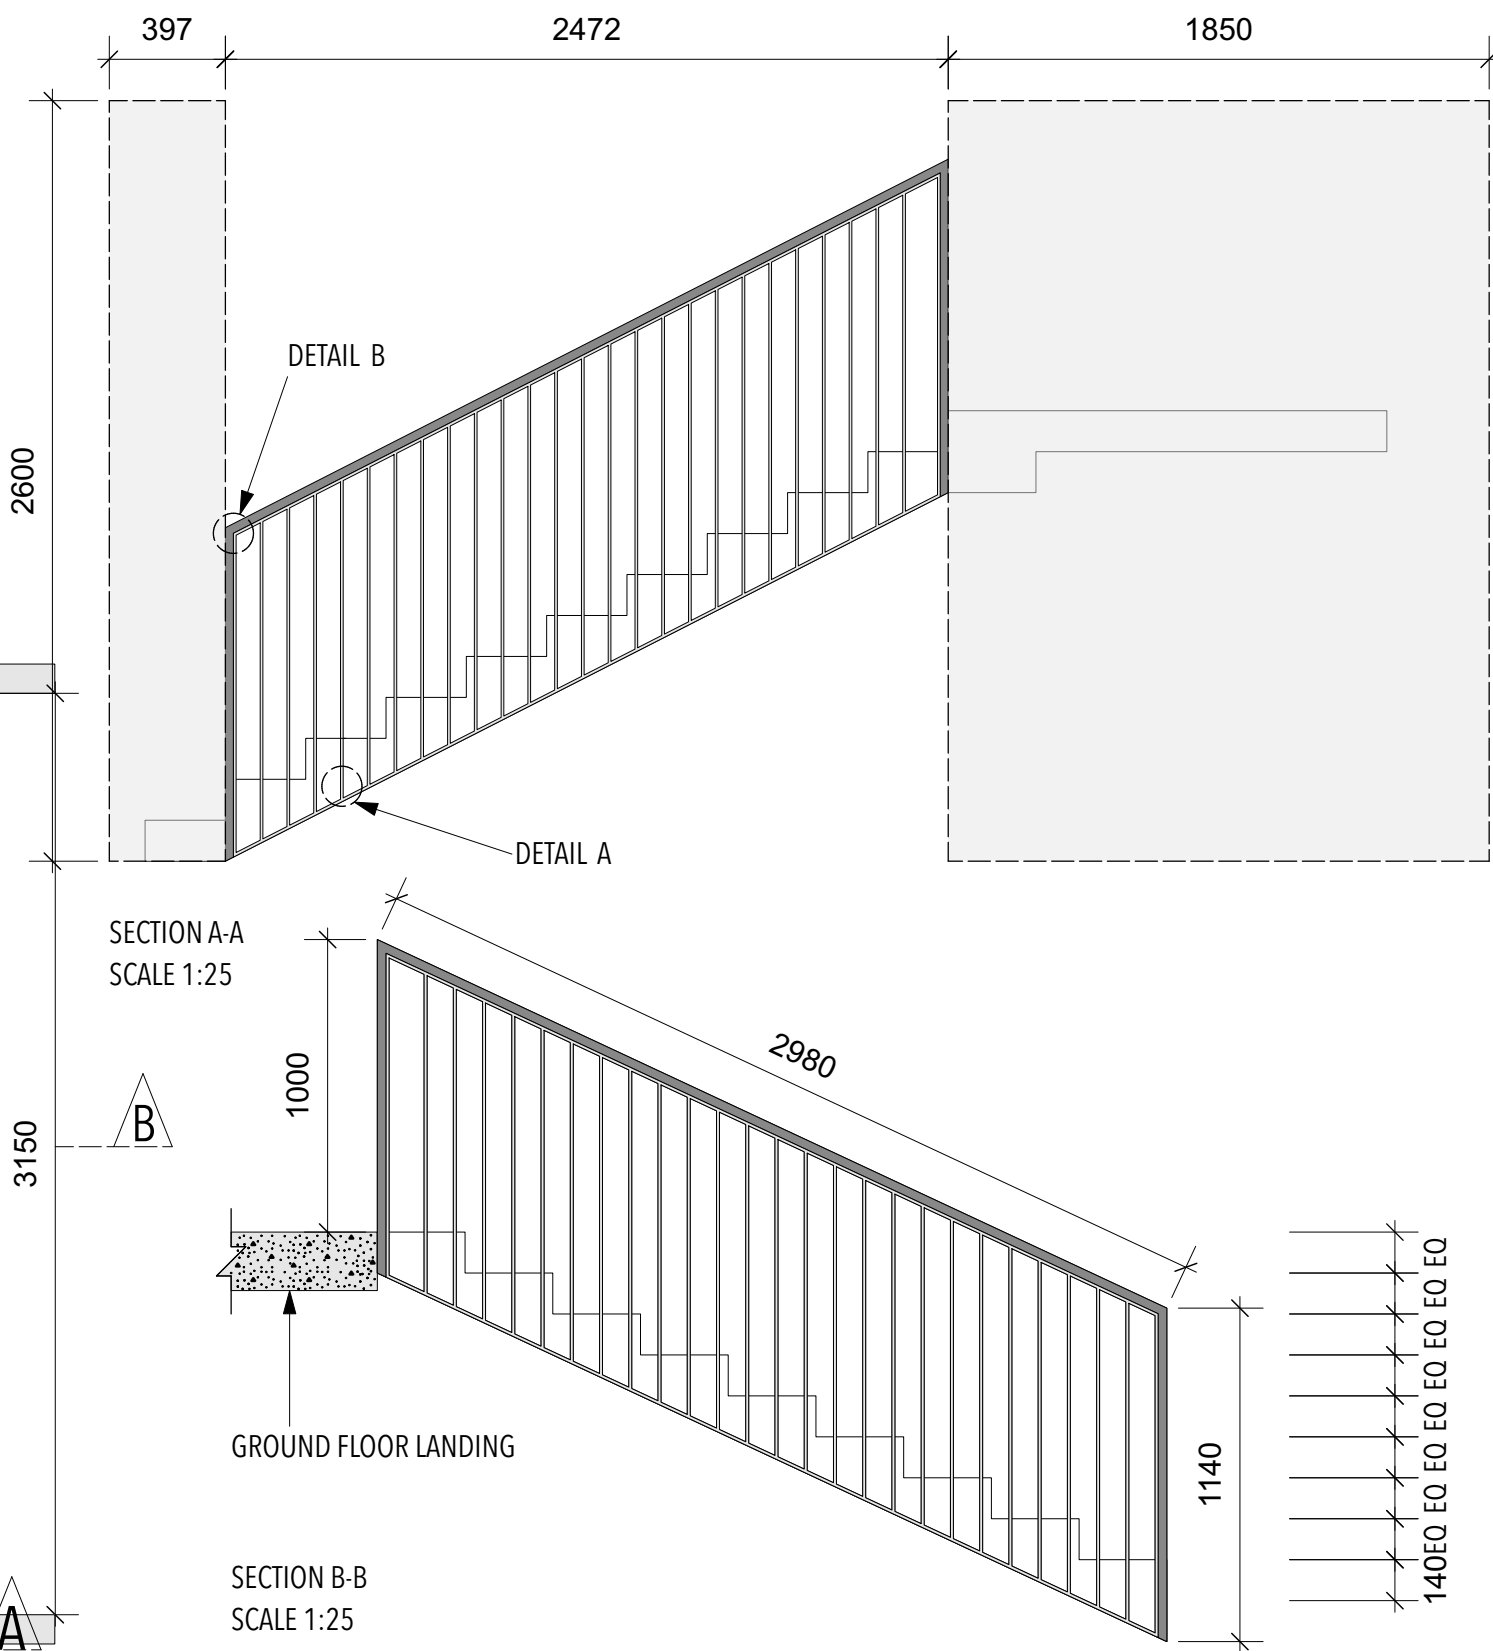


NOTE: ALL DIMENSIONS ARE IN MILLIMETERS, UNLESS OTHERWISE STATED. SO NOT SCALE DIRECT FROM DRAWINGS. ALL DIMENSIONS TO BE VERIFIED WHEN IN DOUBT. CONTRACTOR SHALL BE RESPONSIBLE TO VERIFY DIMENSION AT SITE WHERE REQUIRED.	PROJECT: ZONE AT 45 VYNER STREET, LONDON E2 9DQ	SCALE: AS SHOWN	DATE: APRIL 2021
	DRAWING TITLE: GF STAIR HANDRAIL DETAILING	JOB NO: 01	DRAWING NO: DE-03
	DRAWN BY: TERRENCE, YUN CHUNG LIN		

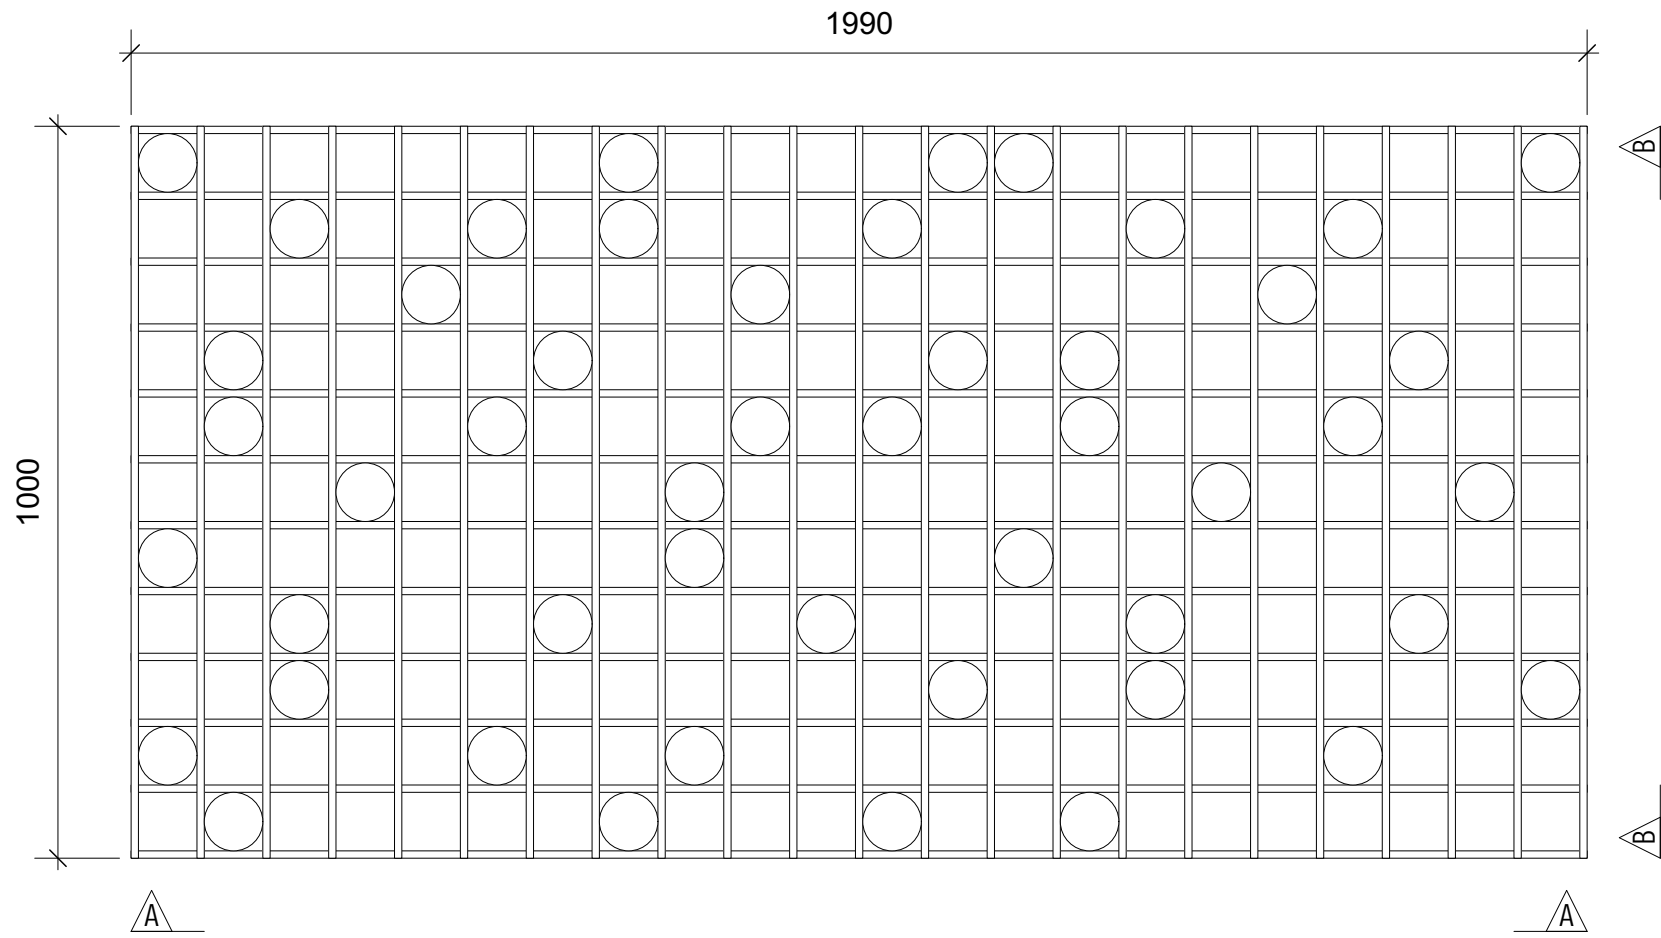



PLAN / SCALE 1:10

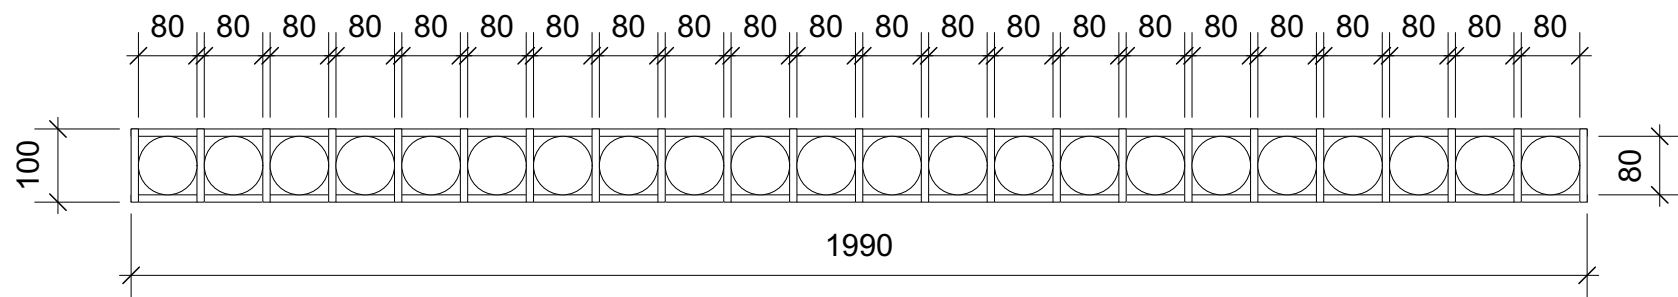


SECTION A-A / SCALE 1:10

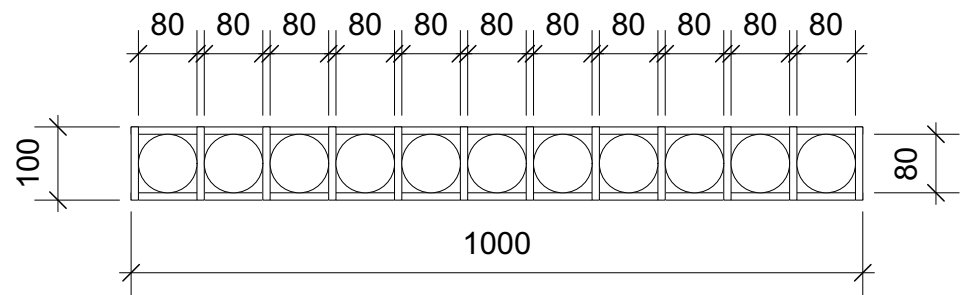

SECTION B-B / SCALE 1:10

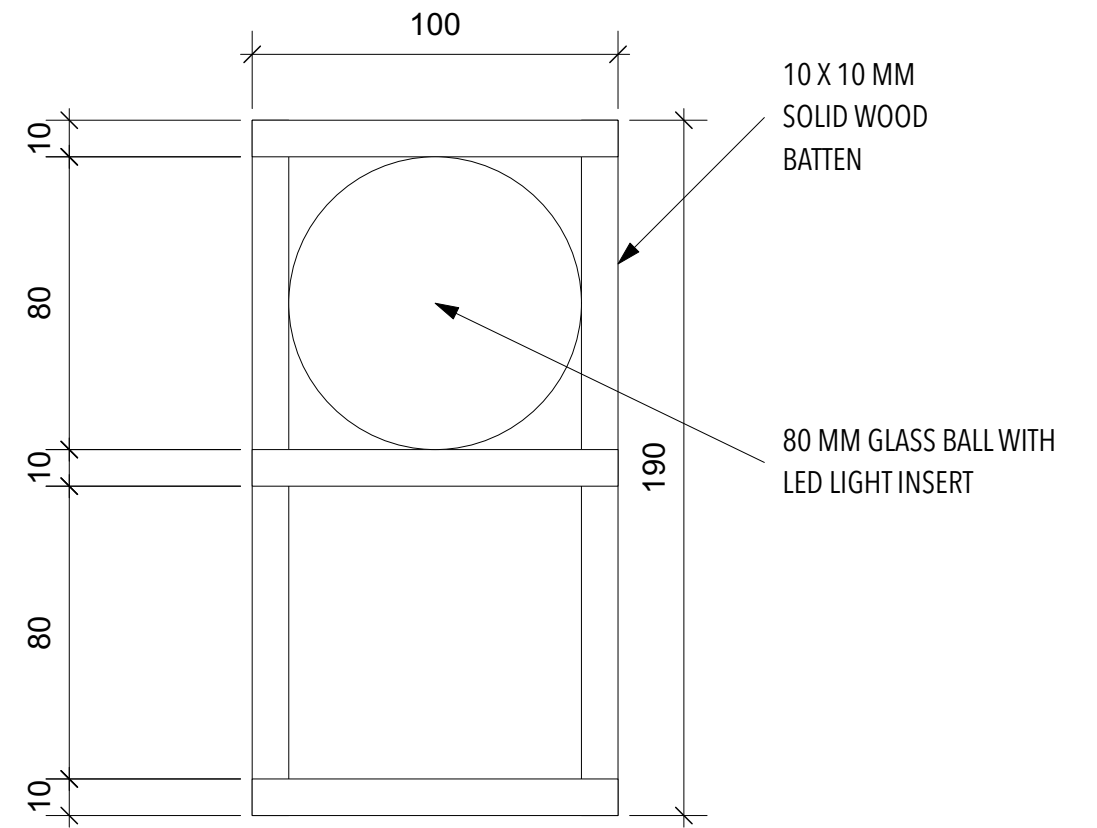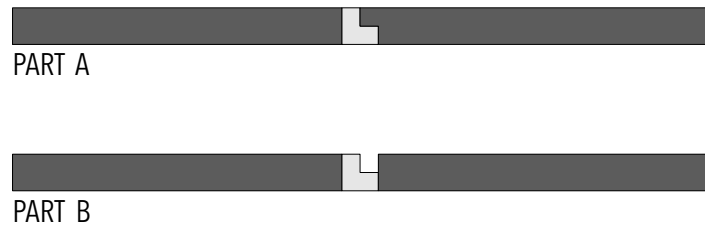

DETAIL A
SCALE 1:2

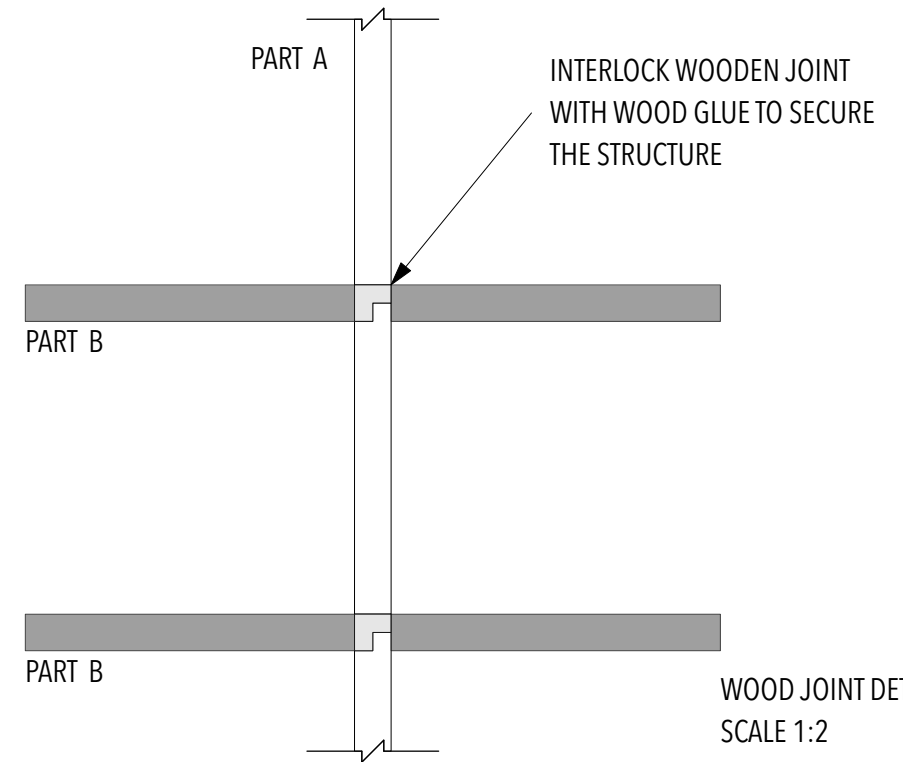

WOOD JOINT DETAIL
SCALE 1:2

CENTER LIGHT DETAILING

DE - 04 SCALE AS SHOWN

NOTE: ALL DIMENSIONS ARE IN MILLIMETERS, UNLESS OTHERWISE STATED. SO NOT SCALE DIRECT FROM DRAWINGS. ALL DIMENSIONS TO BE VERIFIED WHEN IN DOUBT. CONTRACTOR SHALL BE RESPONSIBLE TO VERIFY DIMENSION AT SITE WHERE REQUIRED.	PROJECT: ZONE AT 45 VYNER STREET, LONDON E2 9DQ	SCALE: AS SHOWN	DATE: APRIL 2021
	DRAWING TITLE: CENTER LIGHT DETAILING	JOB NO: 01	DRAWING NO: DE-04
	DRAWN BY: TERRENCE, YUN CHUNG LIN		